


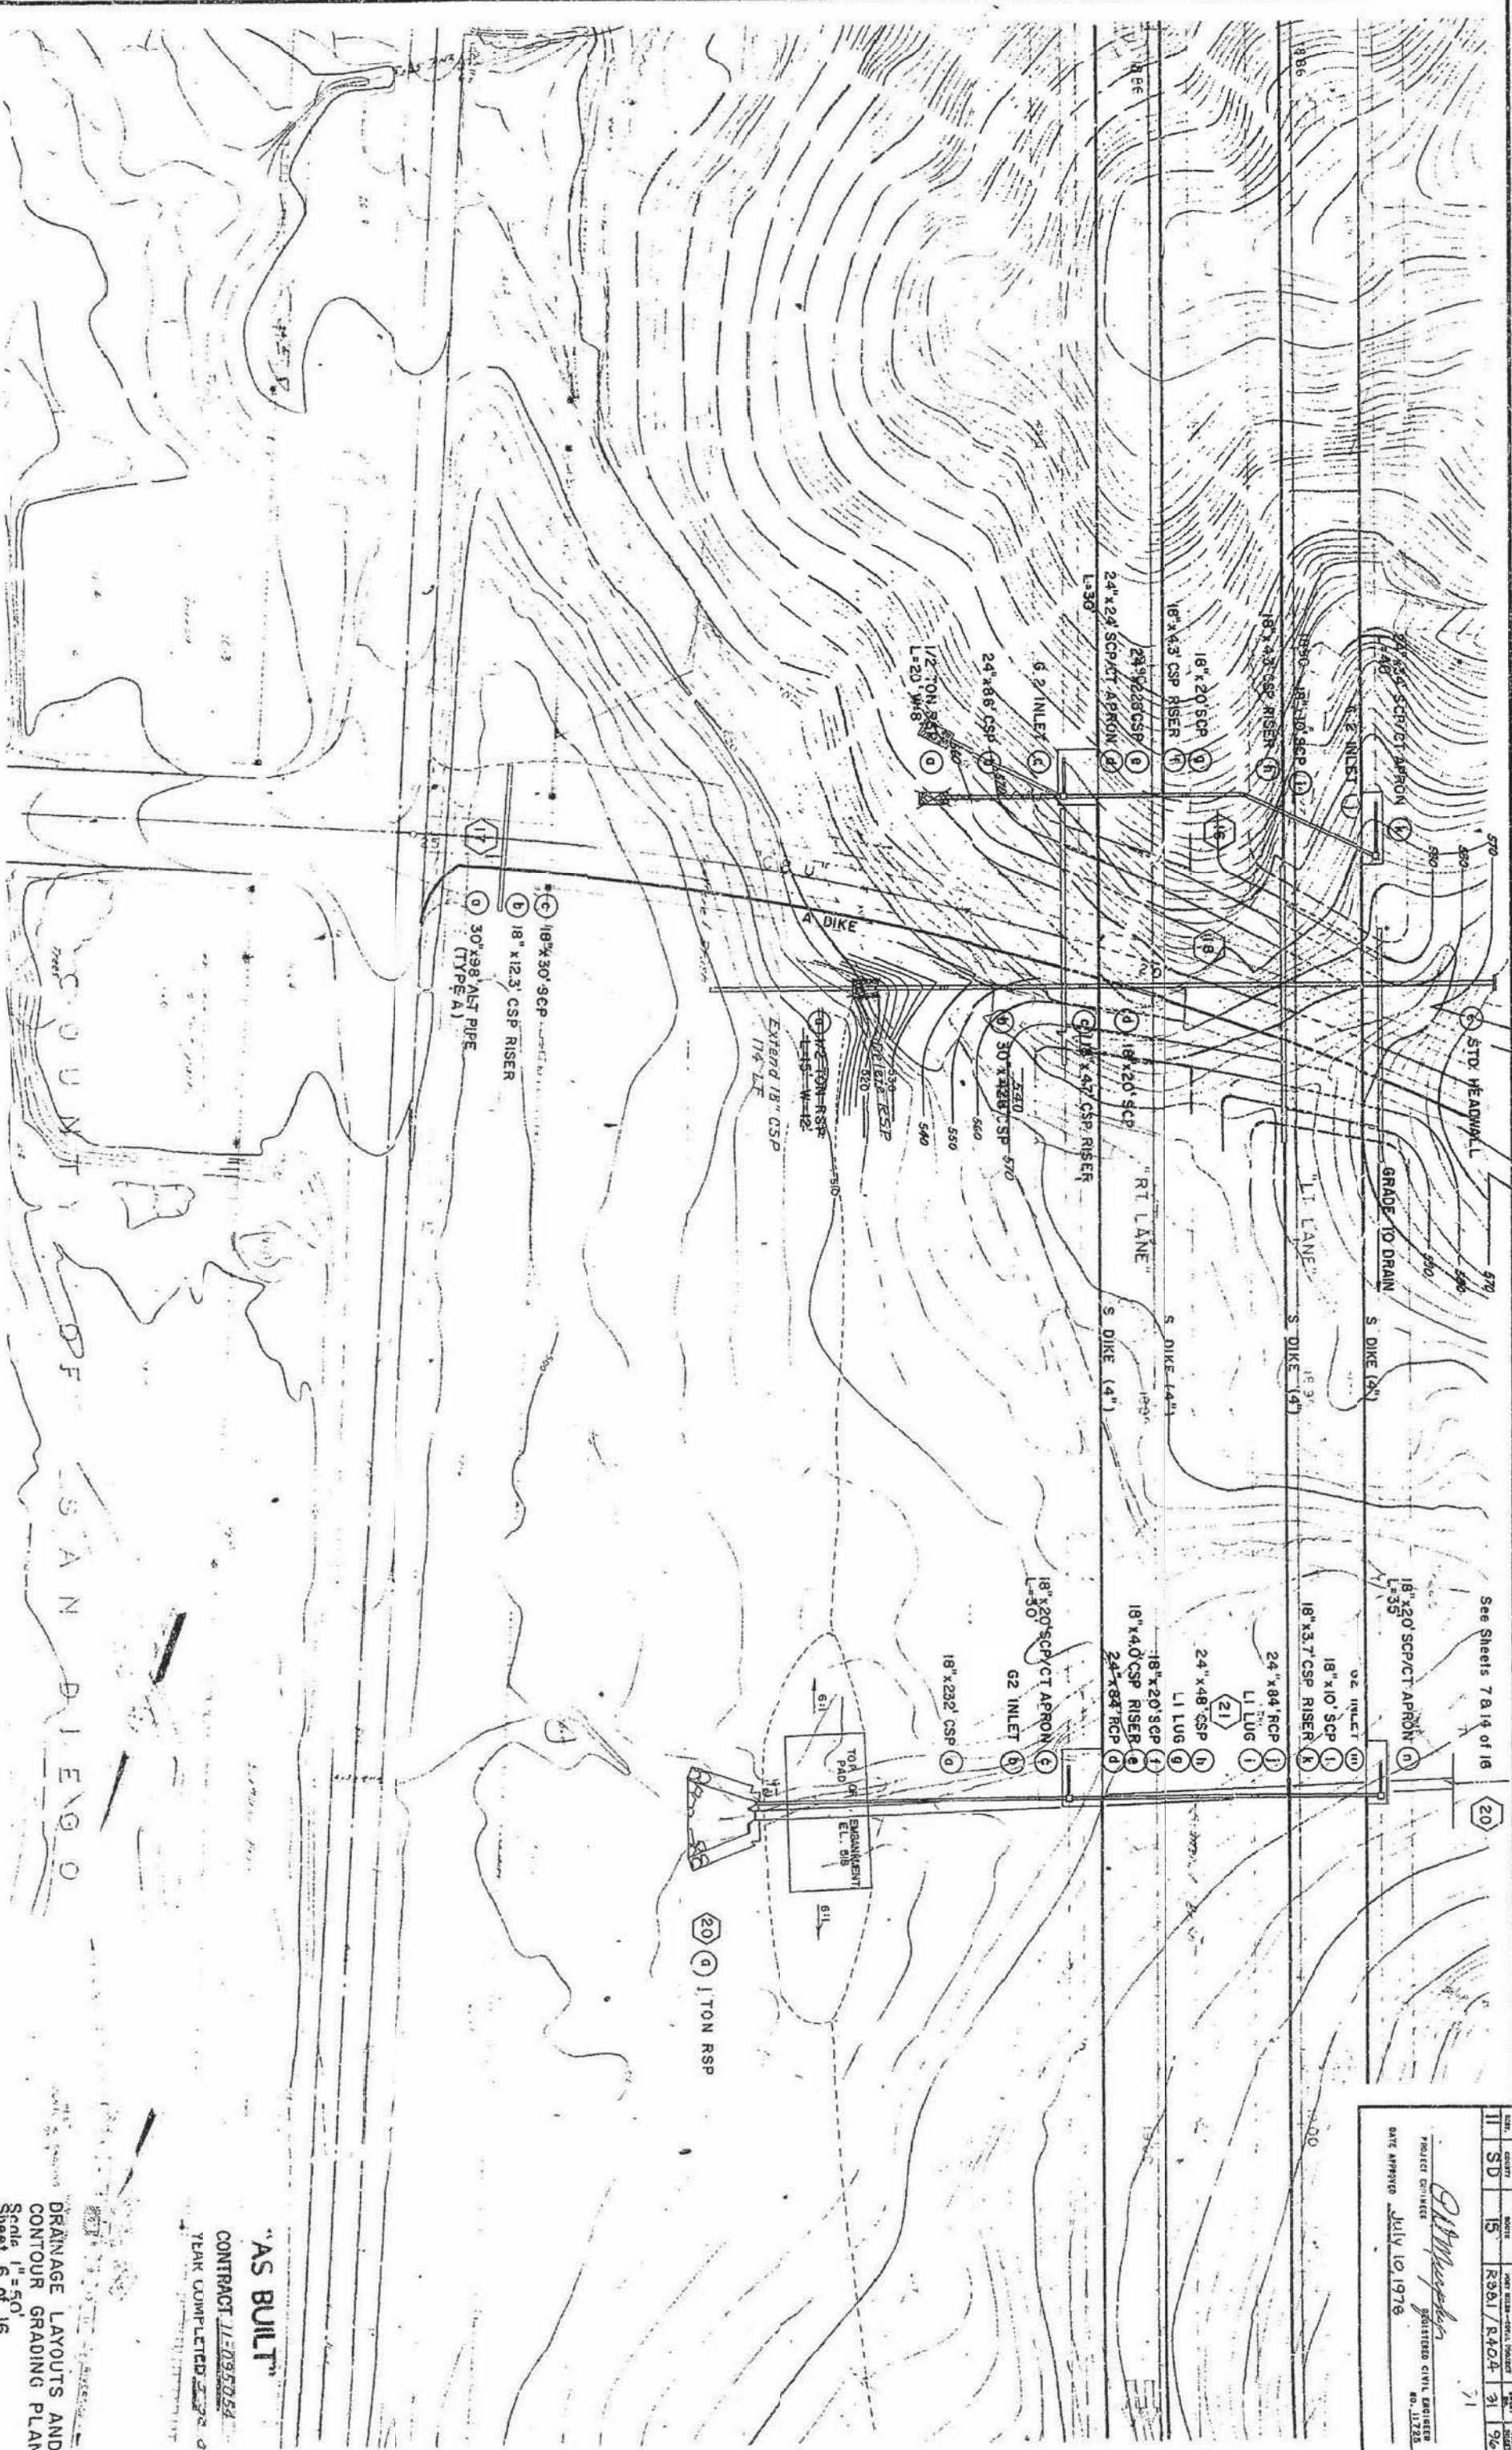

31

3

AS BUILT

CONTRACT 11-035054


YEAR COMPLETED 1972

DRAINAGE LAYOUTS AND
CONTOUR GRADING PLAN


Scale 1"=50'

Sheet 6 of 16

DATE	SD	11	DATE	SD	15	DATE	SD	15
PROJECT	SD	11	PROJECT	SD	15	PROJECT	SD	15
ENGINEER	SD	11	ENGINEER	SD	15	ENGINEER	SD	15
REGISTERED CIVIL ENGINEER	SD	11	REGISTERED CIVIL ENGINEER	SD	15	REGISTERED CIVIL ENGINEER	SD	15
NO. 11723	SD	11	NO. 11723	SD	15	NO. 11723	SD	15

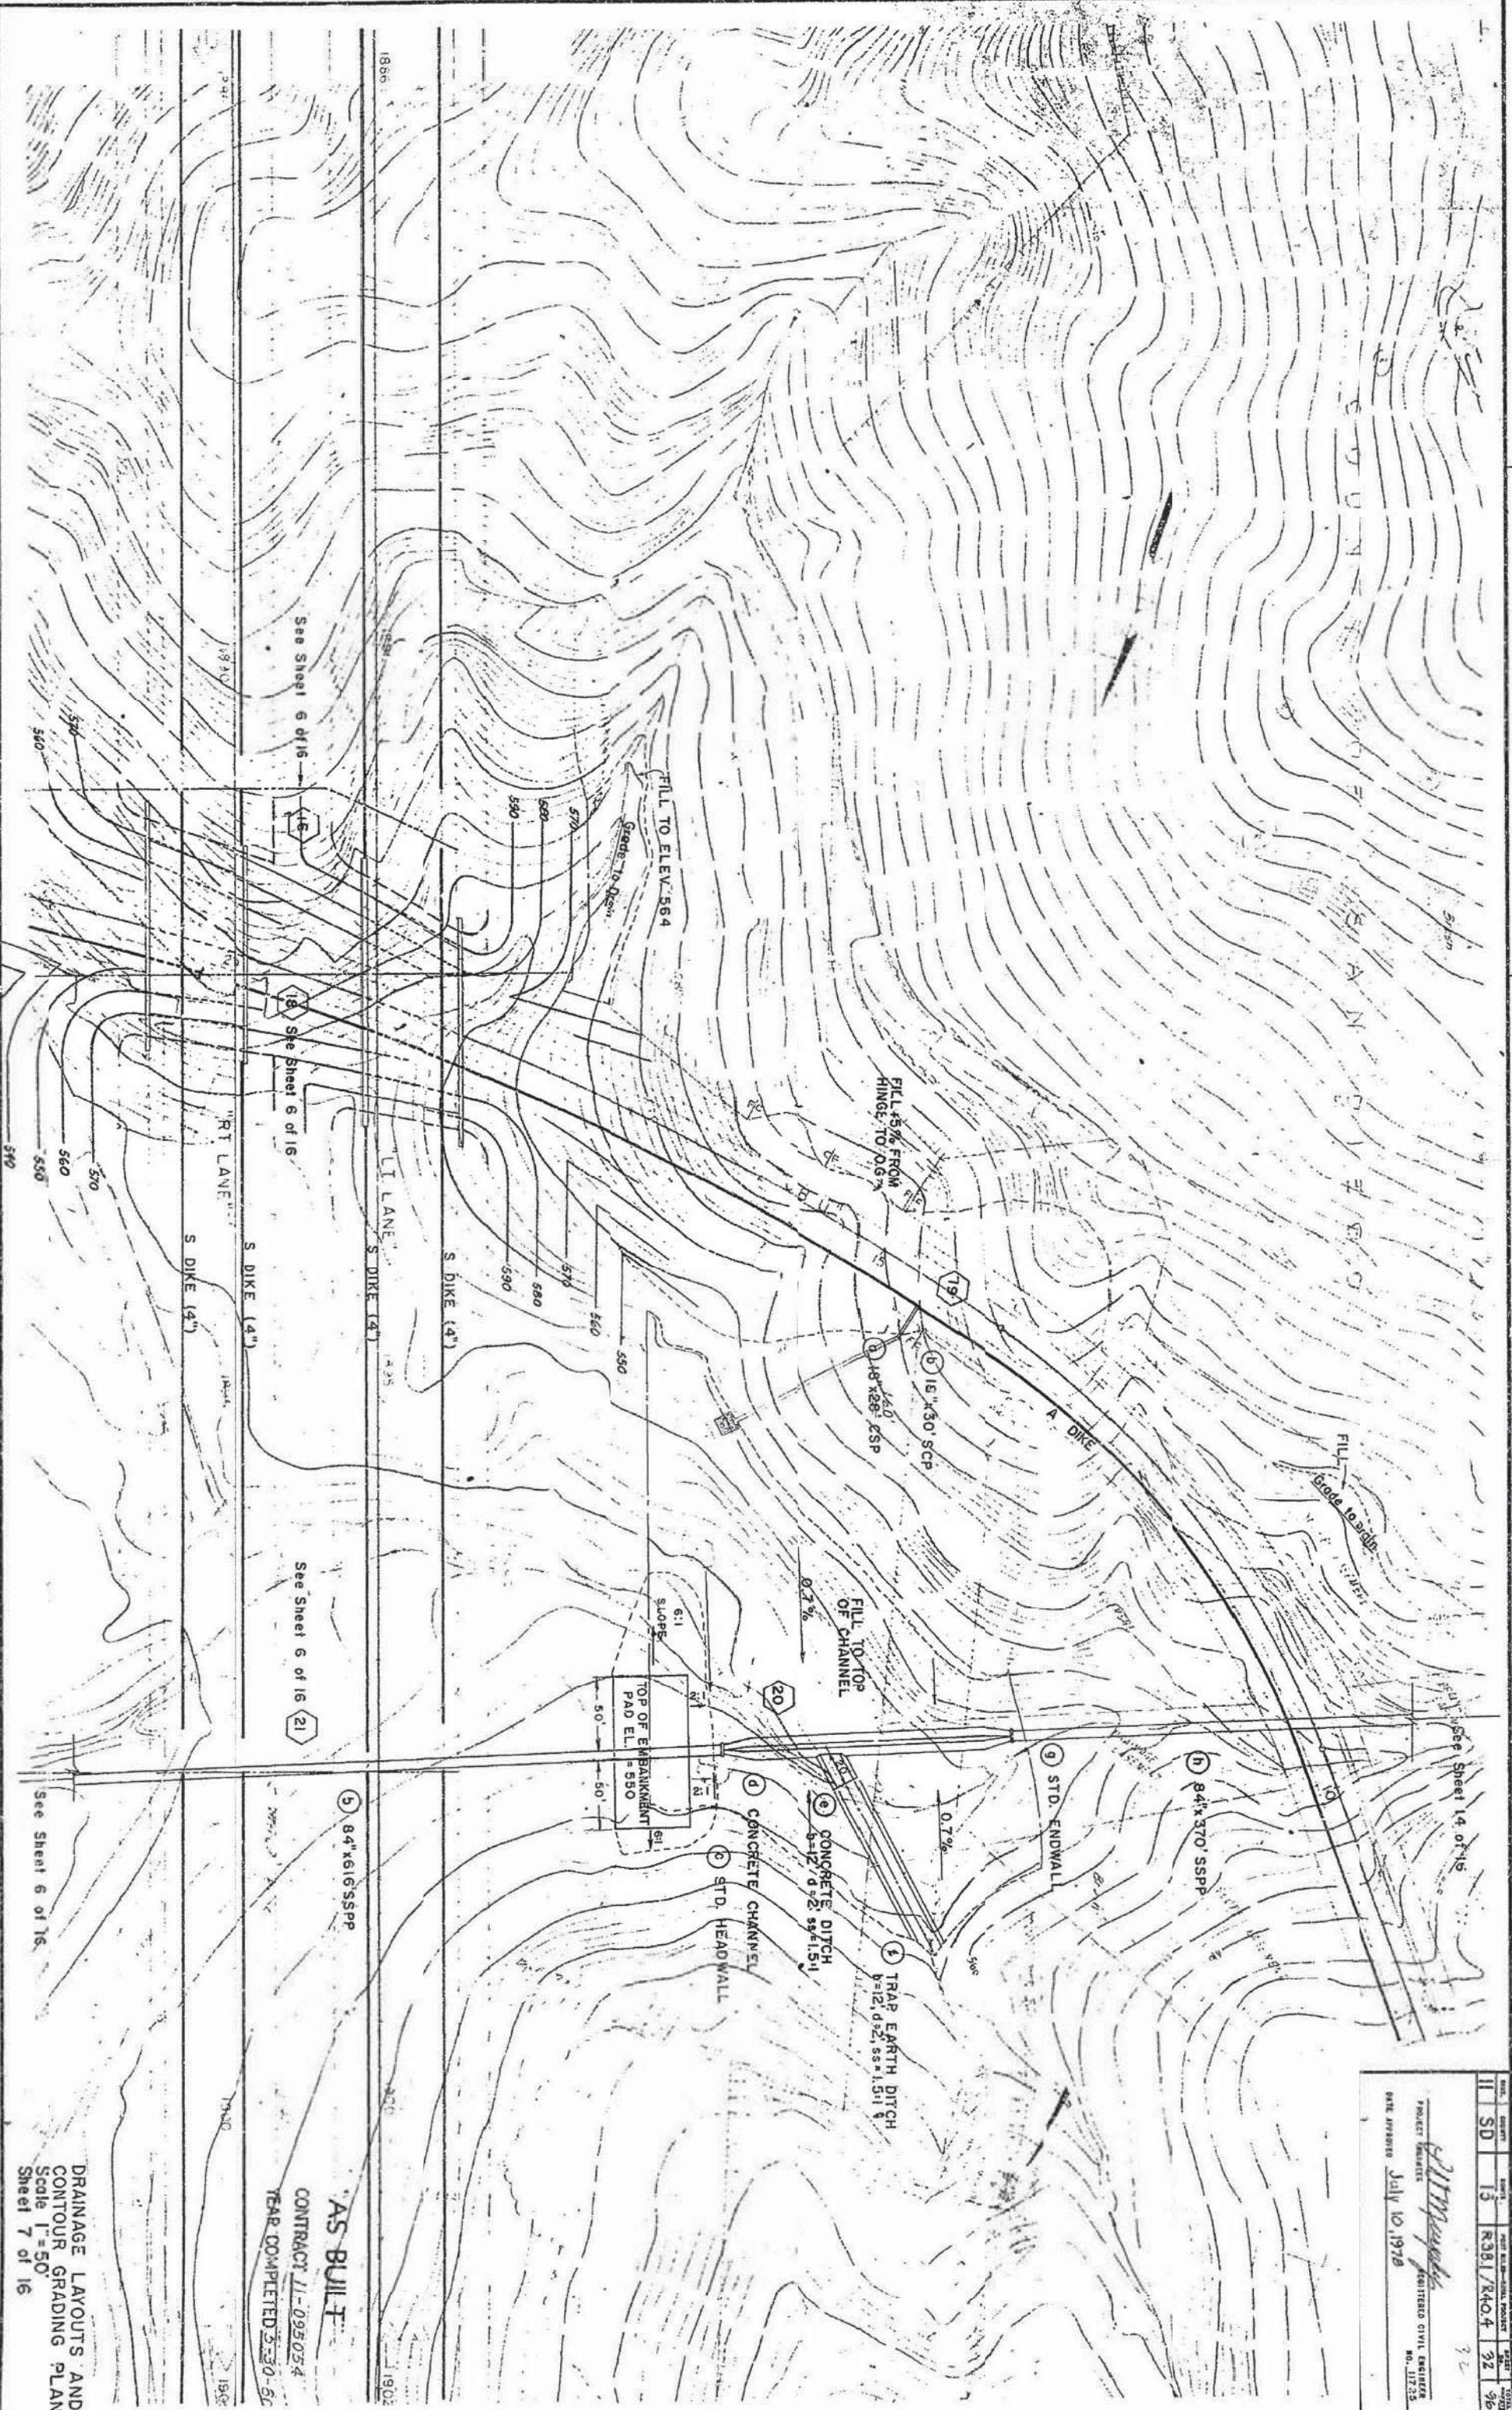

Project Engineer	Date	Design Engineer	Date	Appoint. Recommended By	Date
R.D. Mc. pty		J.O. Gray		J.O. Grassberger	

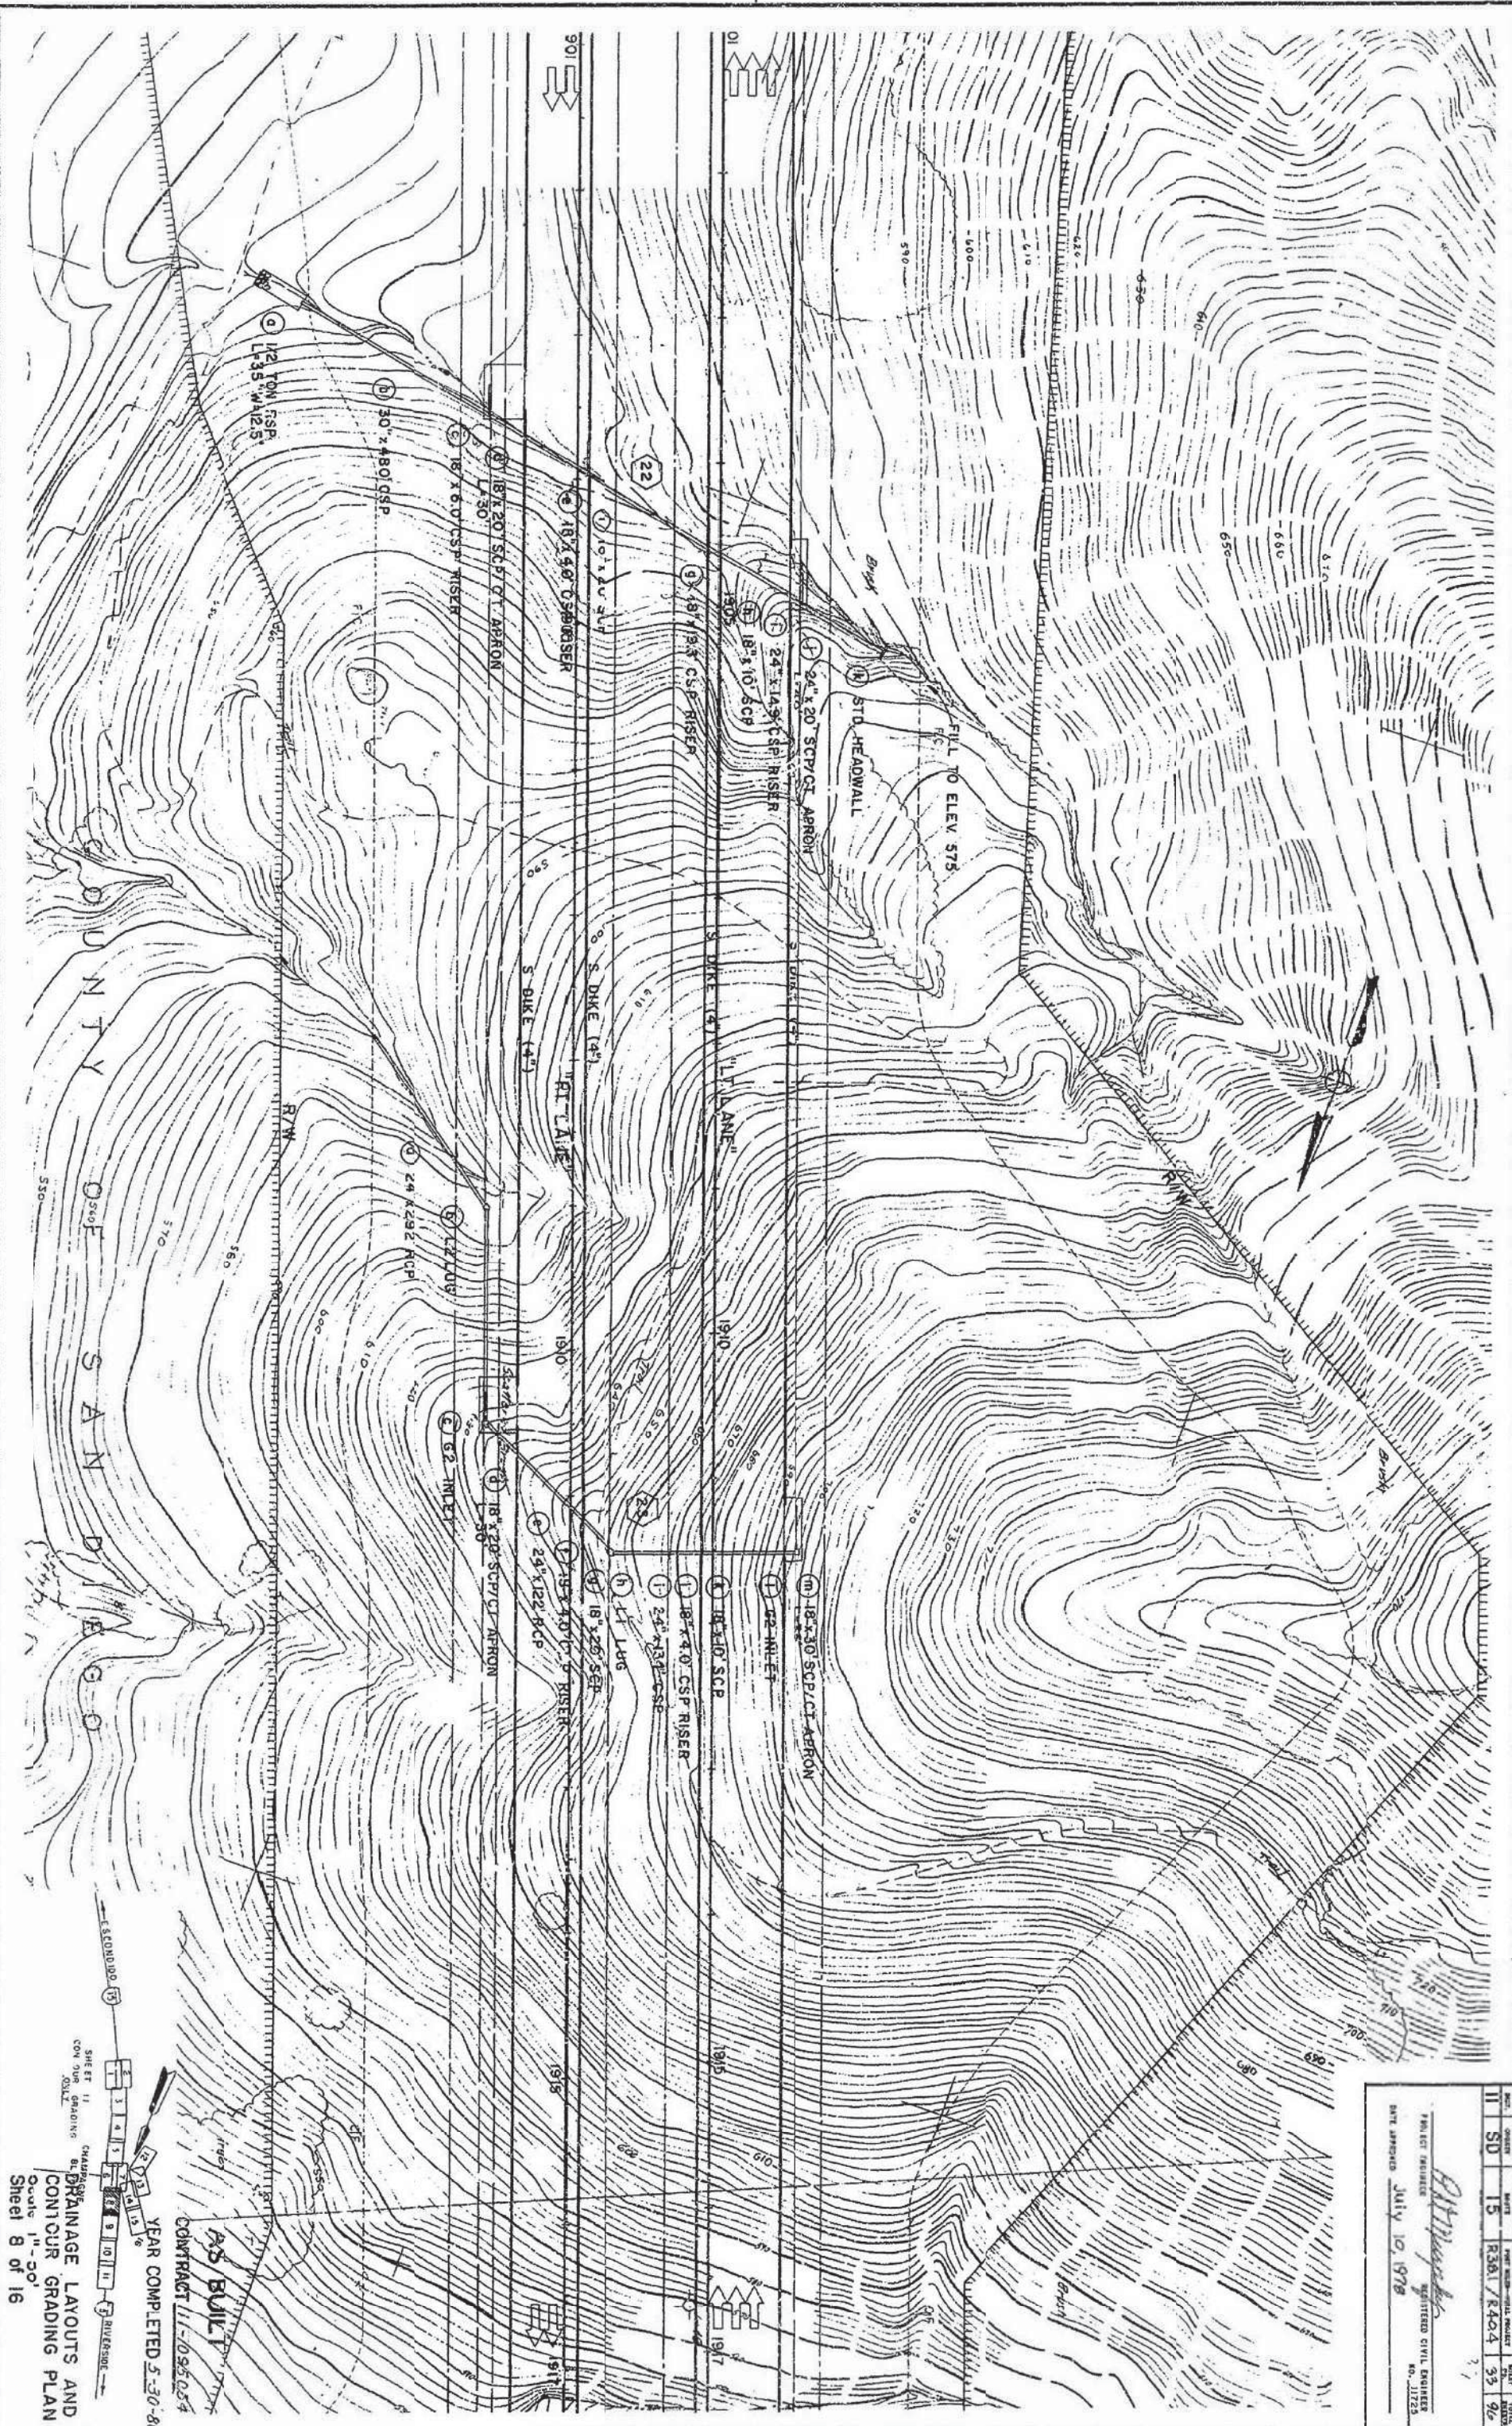


NO.	DATE	REV.	BY	CHK.	APP.
11	SD	15	R3A1 / R4A4	33	90

Handwritten signature
PROJECT ENGINEER
REGISTERED CIVIL ENGINEER
NO. 11723
DATE APPROVED July 10, 1978

AS BUILT
CONTRACT 11-095024
YEAR COMPLETED 5-30-80
SHEET 11
CONTOUR GRADING
DRAINAGE LAYOUTS AND
CONTOUR GRADING PLAN
Scale 1" = 50'
Sheet 8 of 16

DATE	CONTRACT	DATE	PROJECT	DATE	DATE
11	SD	15	R381/R404	24	96


PROJECT ENGINEER
 REGISTERED CIVIL ENGINEER
 NO. 11725
 DATE APPROVED July 10, 1978

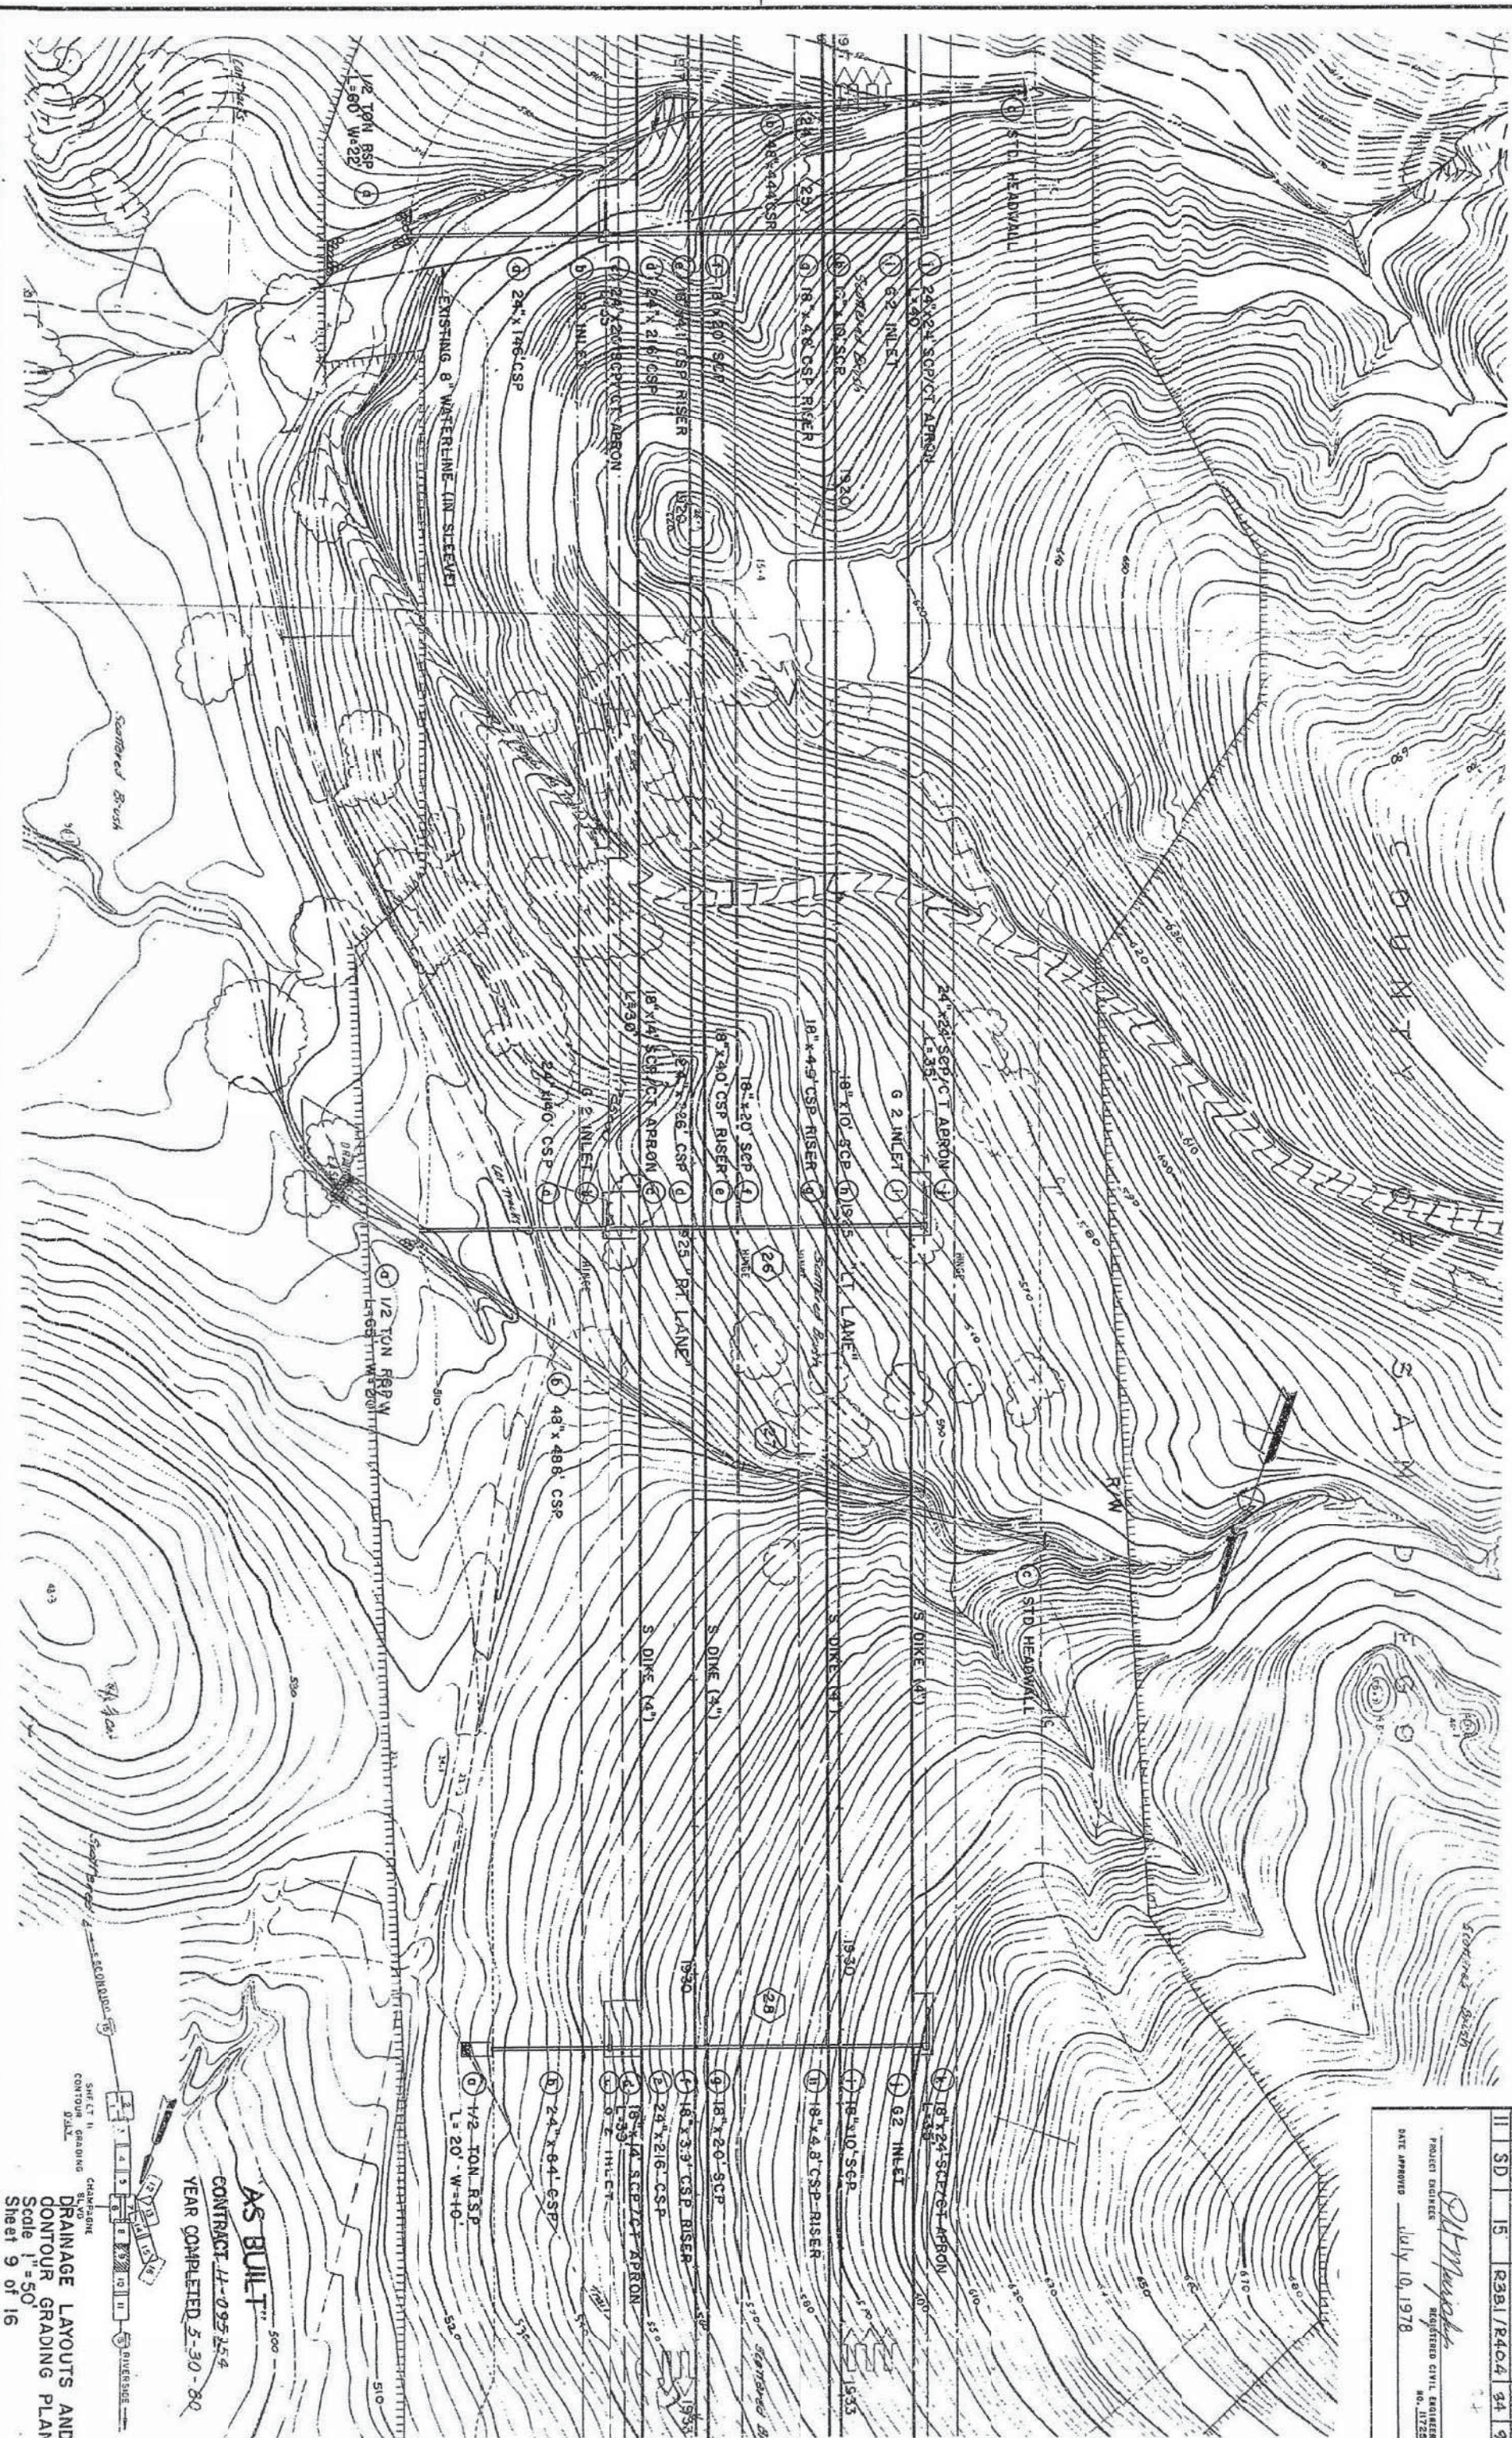

AS BUILT
 CONTRACT 44-095 254
 YEAR COMPLETED 5-30-80

DRAINAGE LAYOUTS AND
 CONTOUR GRADING PLAN
 Scale 1"=50'
 Sheet 9 of 16

Project Engineer	Date	Design Engineer	Date	Approved/Checked by	Date
R.D. Murphy		W.D. Gray		W.D. Grosberger	

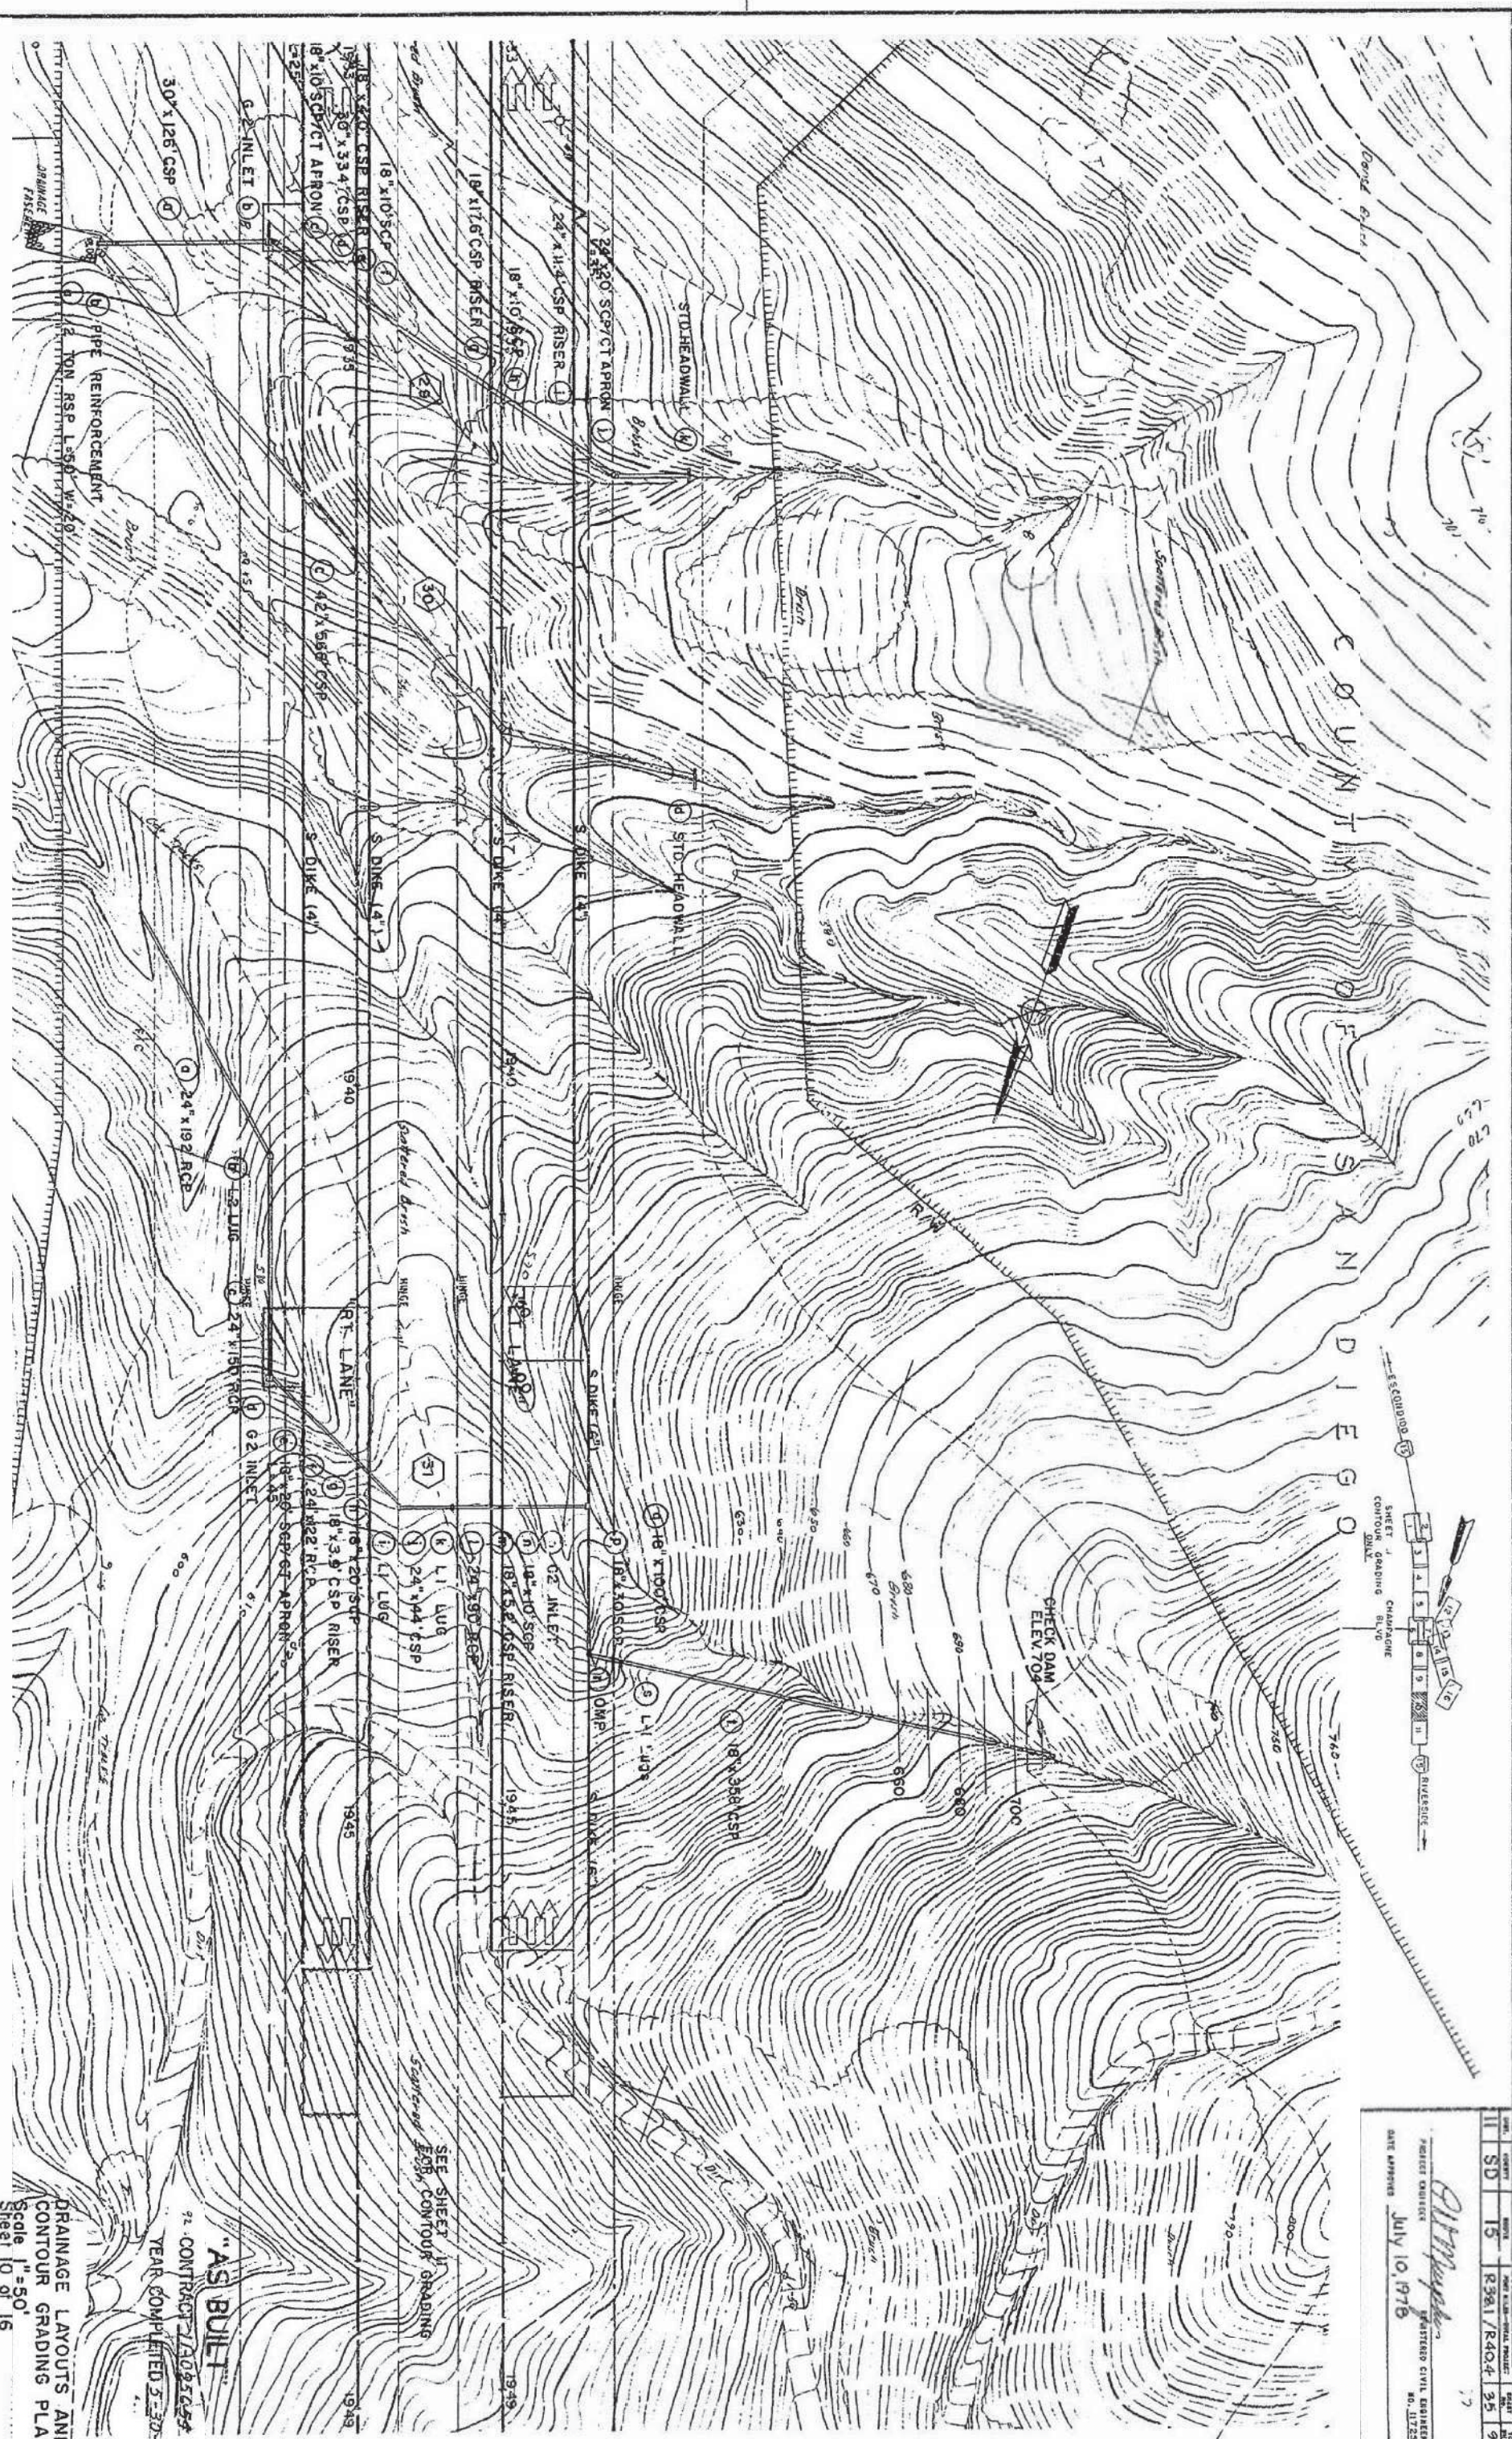

"AS BUILT"
 71 CONTRACT 1A025055
 YEAR COMPLETED 5-30-80

DRAINAGE LAYOUTS AND
 CONTOUR GRADING PLAN
 Scale 1"=50'
 Sheet 10 of 16