



Project Engineer	Date	Design Engineer	Date	Approved/Recommended By	Date
R.D. Murphy		J.O. Grey		J.O. Grabberger	

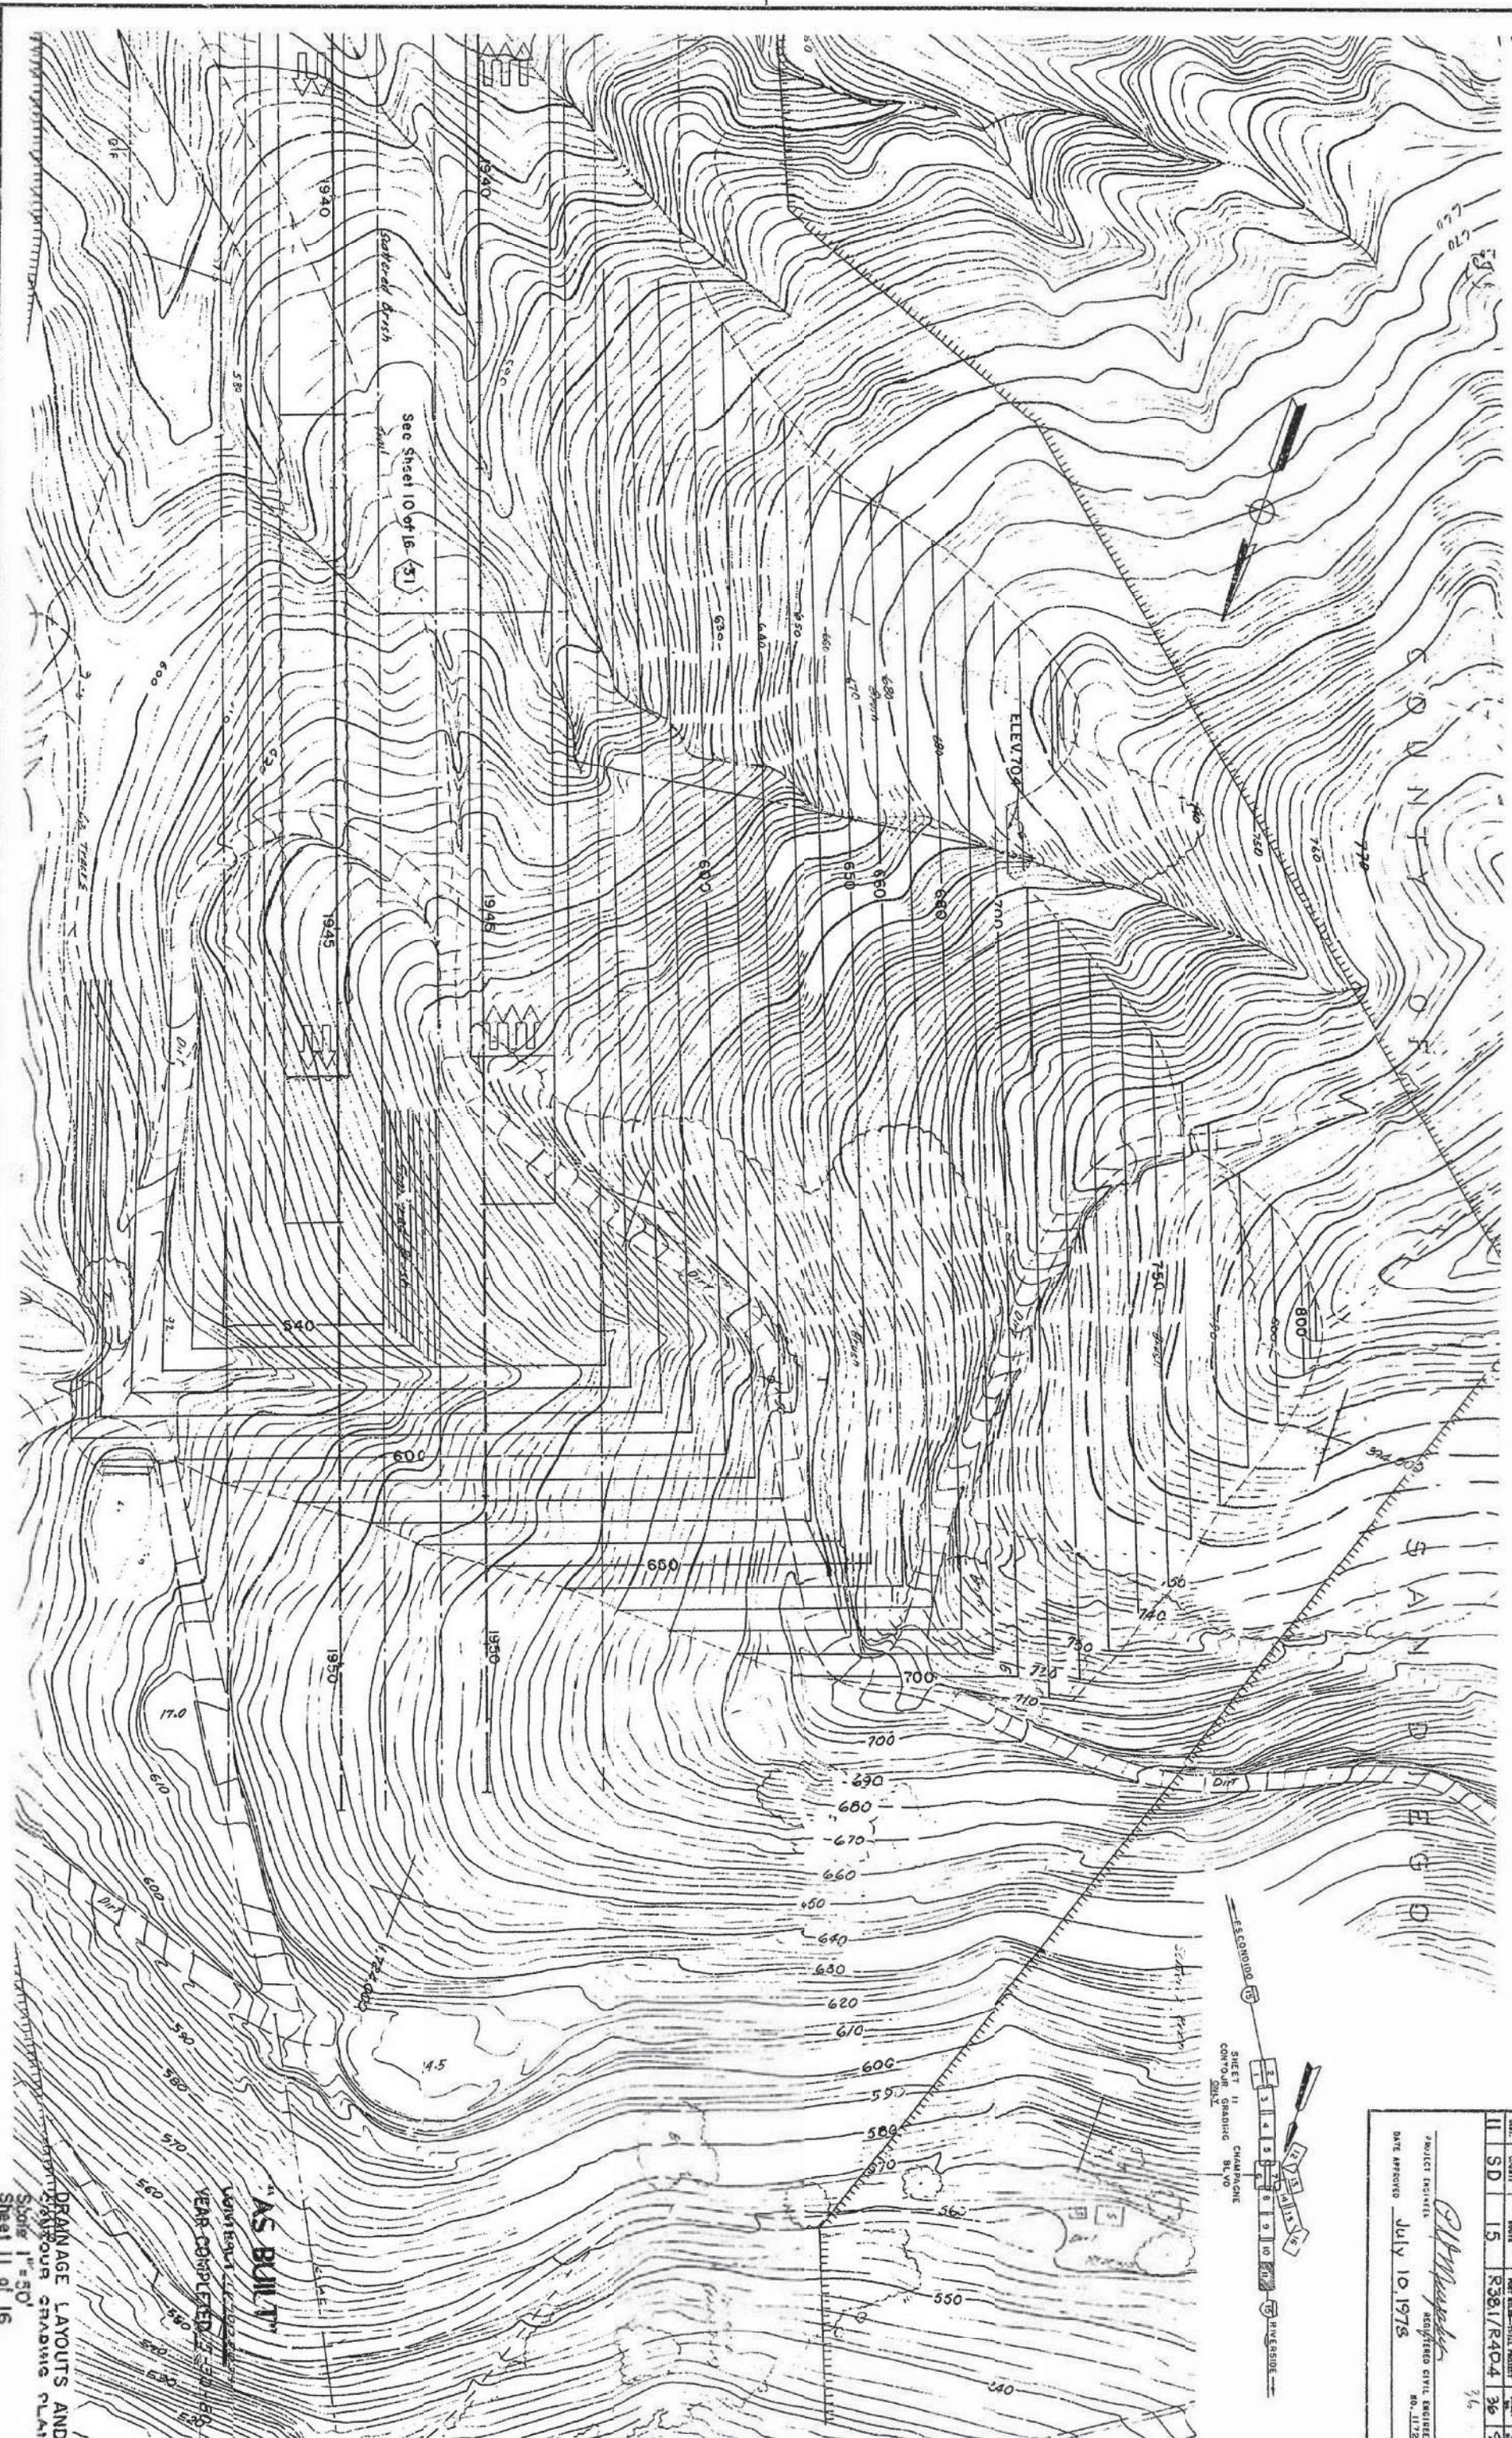

SHEET	11	SD	15	PROJECT	R381/R404	36	96
				PROJECT ENGINEER	R.D. Murphy		
				REGISTERED CIVIL ENGINEER	NO. 11725		
				DATE APPROVED	July 10, 1978		

DRAINAGE LAYOUTS AND
EXISTING GRADING PLAN
Scale 1"=50'
Sheet 11 of 16

Project Engineer	Date	Design Engineer	Date	Approval Recommended By	Date
<i>J. D. Murphy</i>		<i>J. Q. Gray</i>		<i>J. Q. Grasberger</i>	

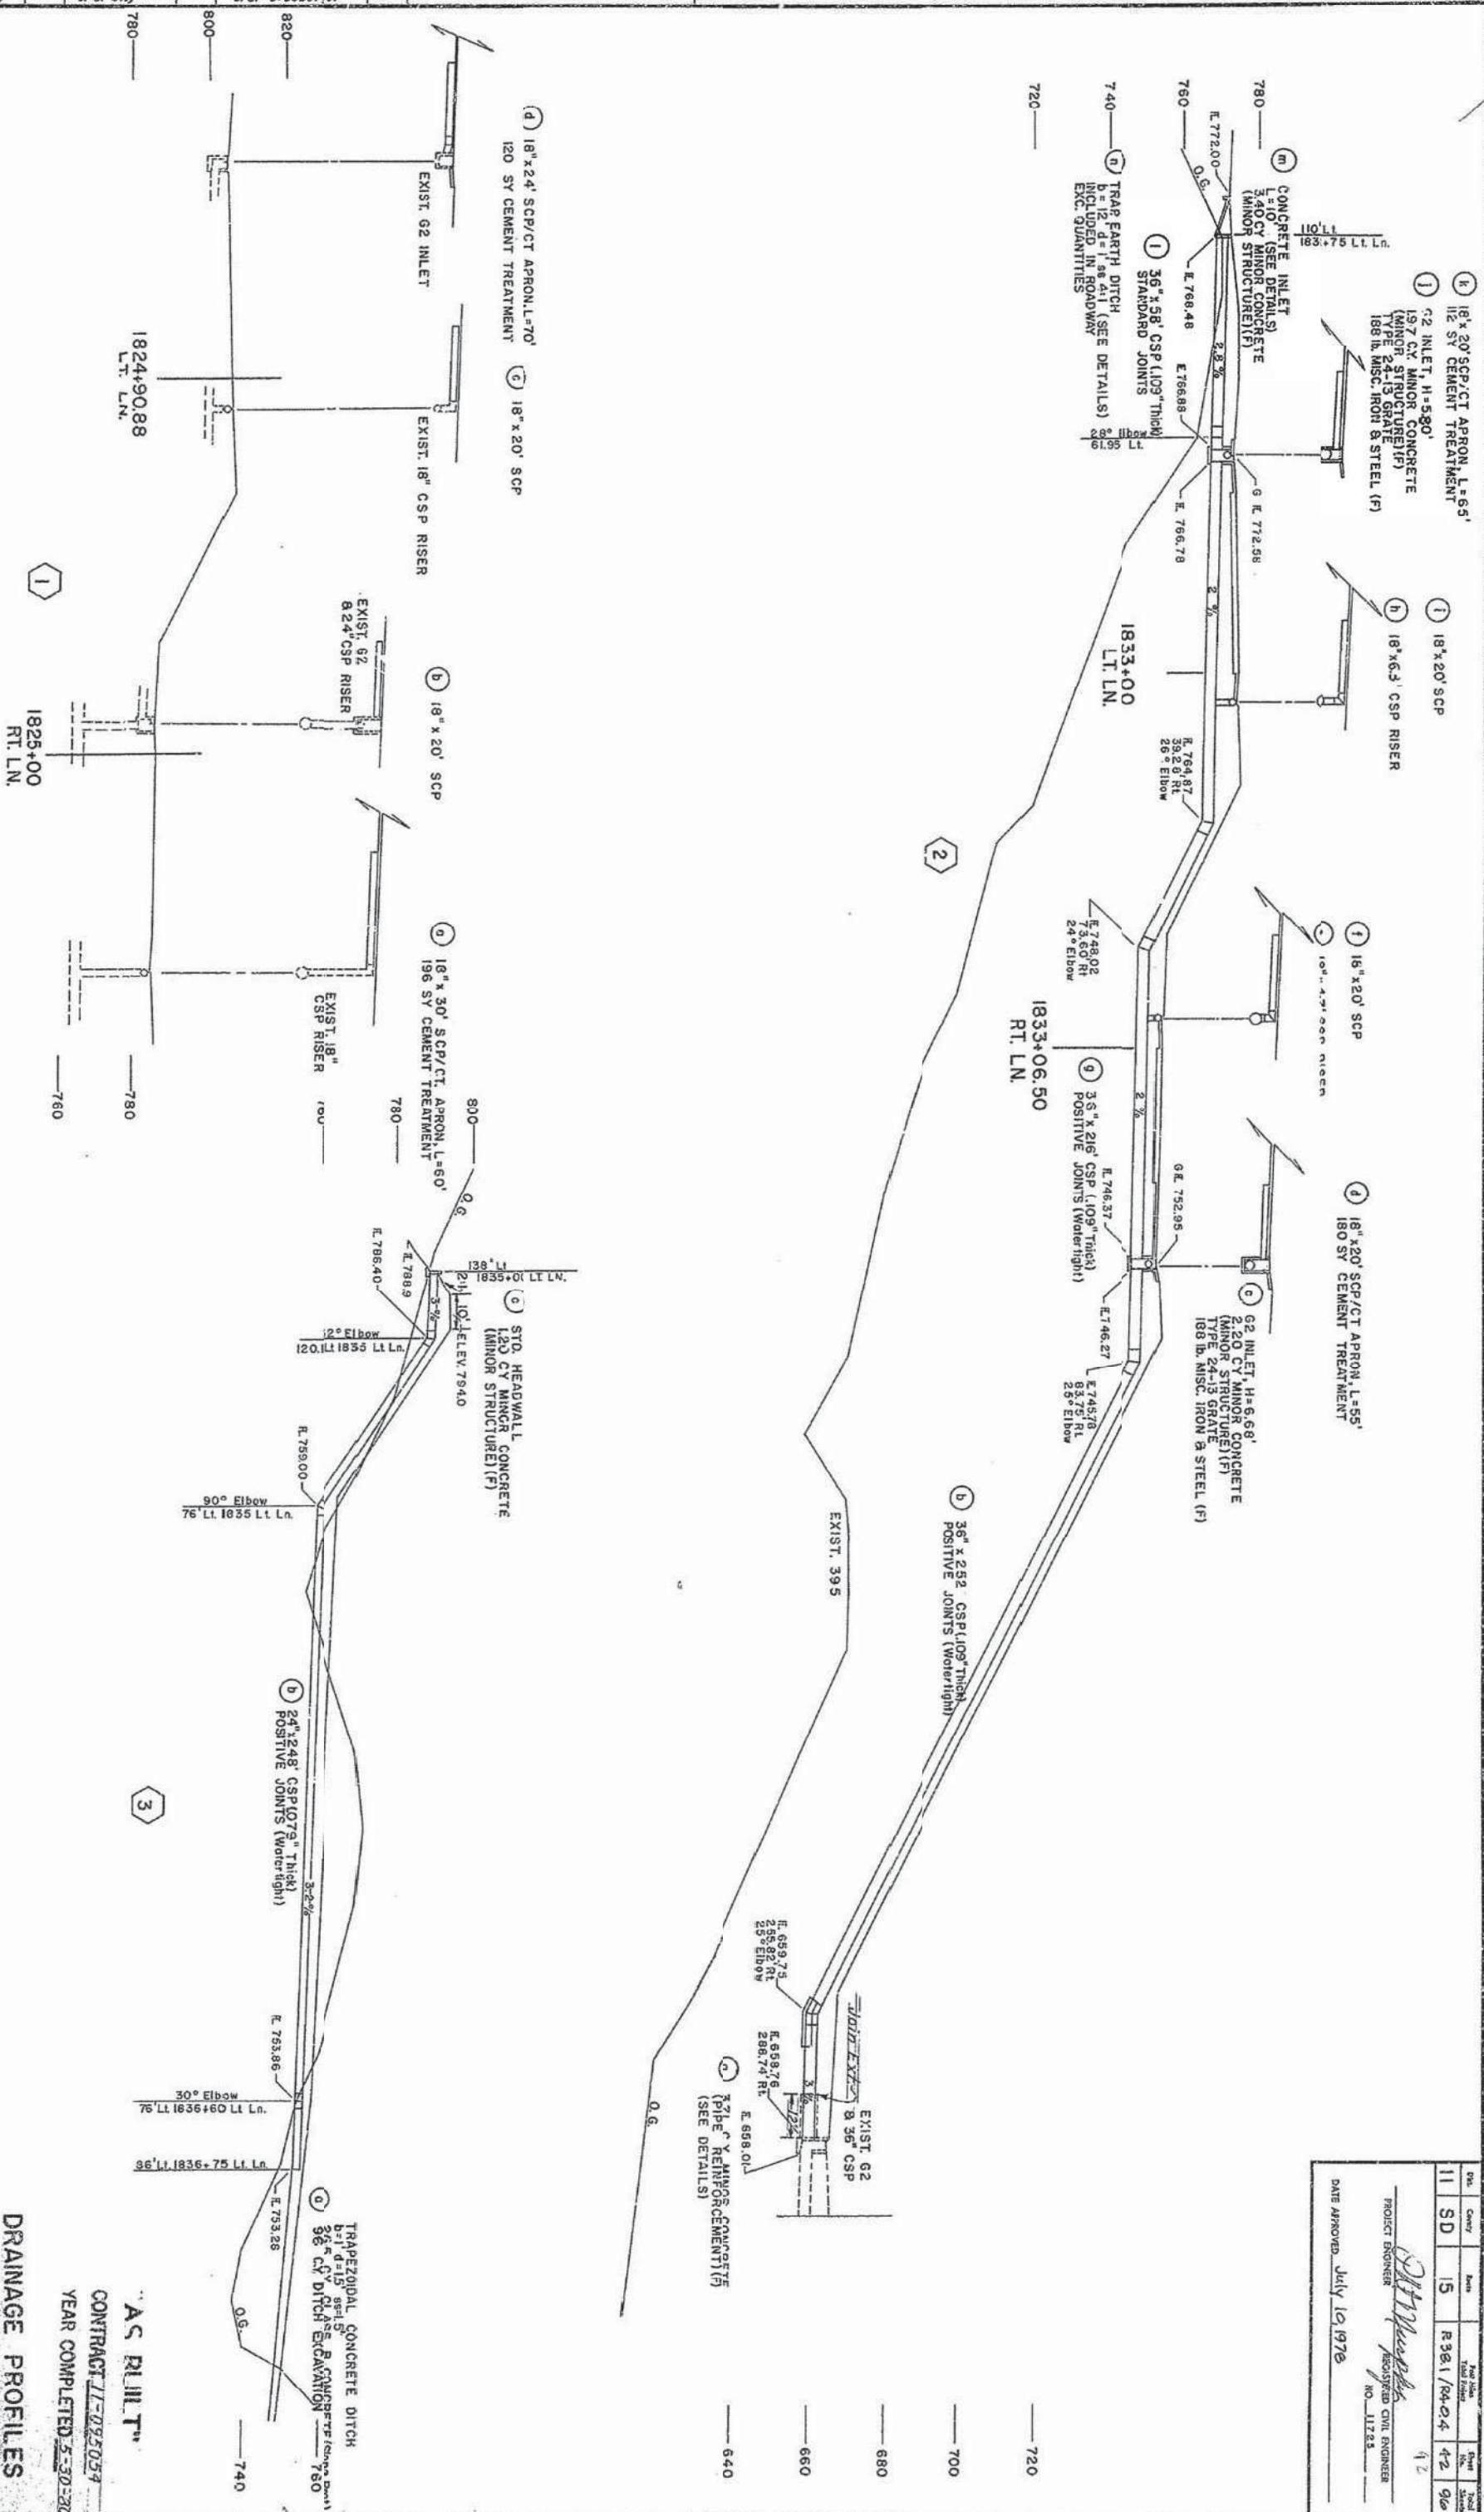

SEE DRAINAGE DETAILS SHEET 4 OF 4 FOR GENERAL NOTES

SCALE: 1"=20' Sheet 1 of 15

DRAINAGE PROFILES AND QUANTITIES

AS BUILT

CONTRACT 11-095054

YEAR COMPLETED 5-30-80

Dist.	County	Area	Post Mile Post Office	Post Office No.	Post Office Status
11	SD	15	R 38.1 / S 4.2	42	96

42

W. H. Muehle

PROJECT ENGINEER

REGISTERED CIVIL ENGINEER


NO. 11723

DATE APPROVED July 12, 1978


Proj.	Sheet	Scale	Proj. No.	Sheet No.	Total
11	SD	15	R36.1 / R40.4	45	96

PROJECT ENGINEER
RL Murphy
 REGISTERED CIVIL ENGINEER
 NO. 11725

DATE APPROVED: JULY 10, 1978

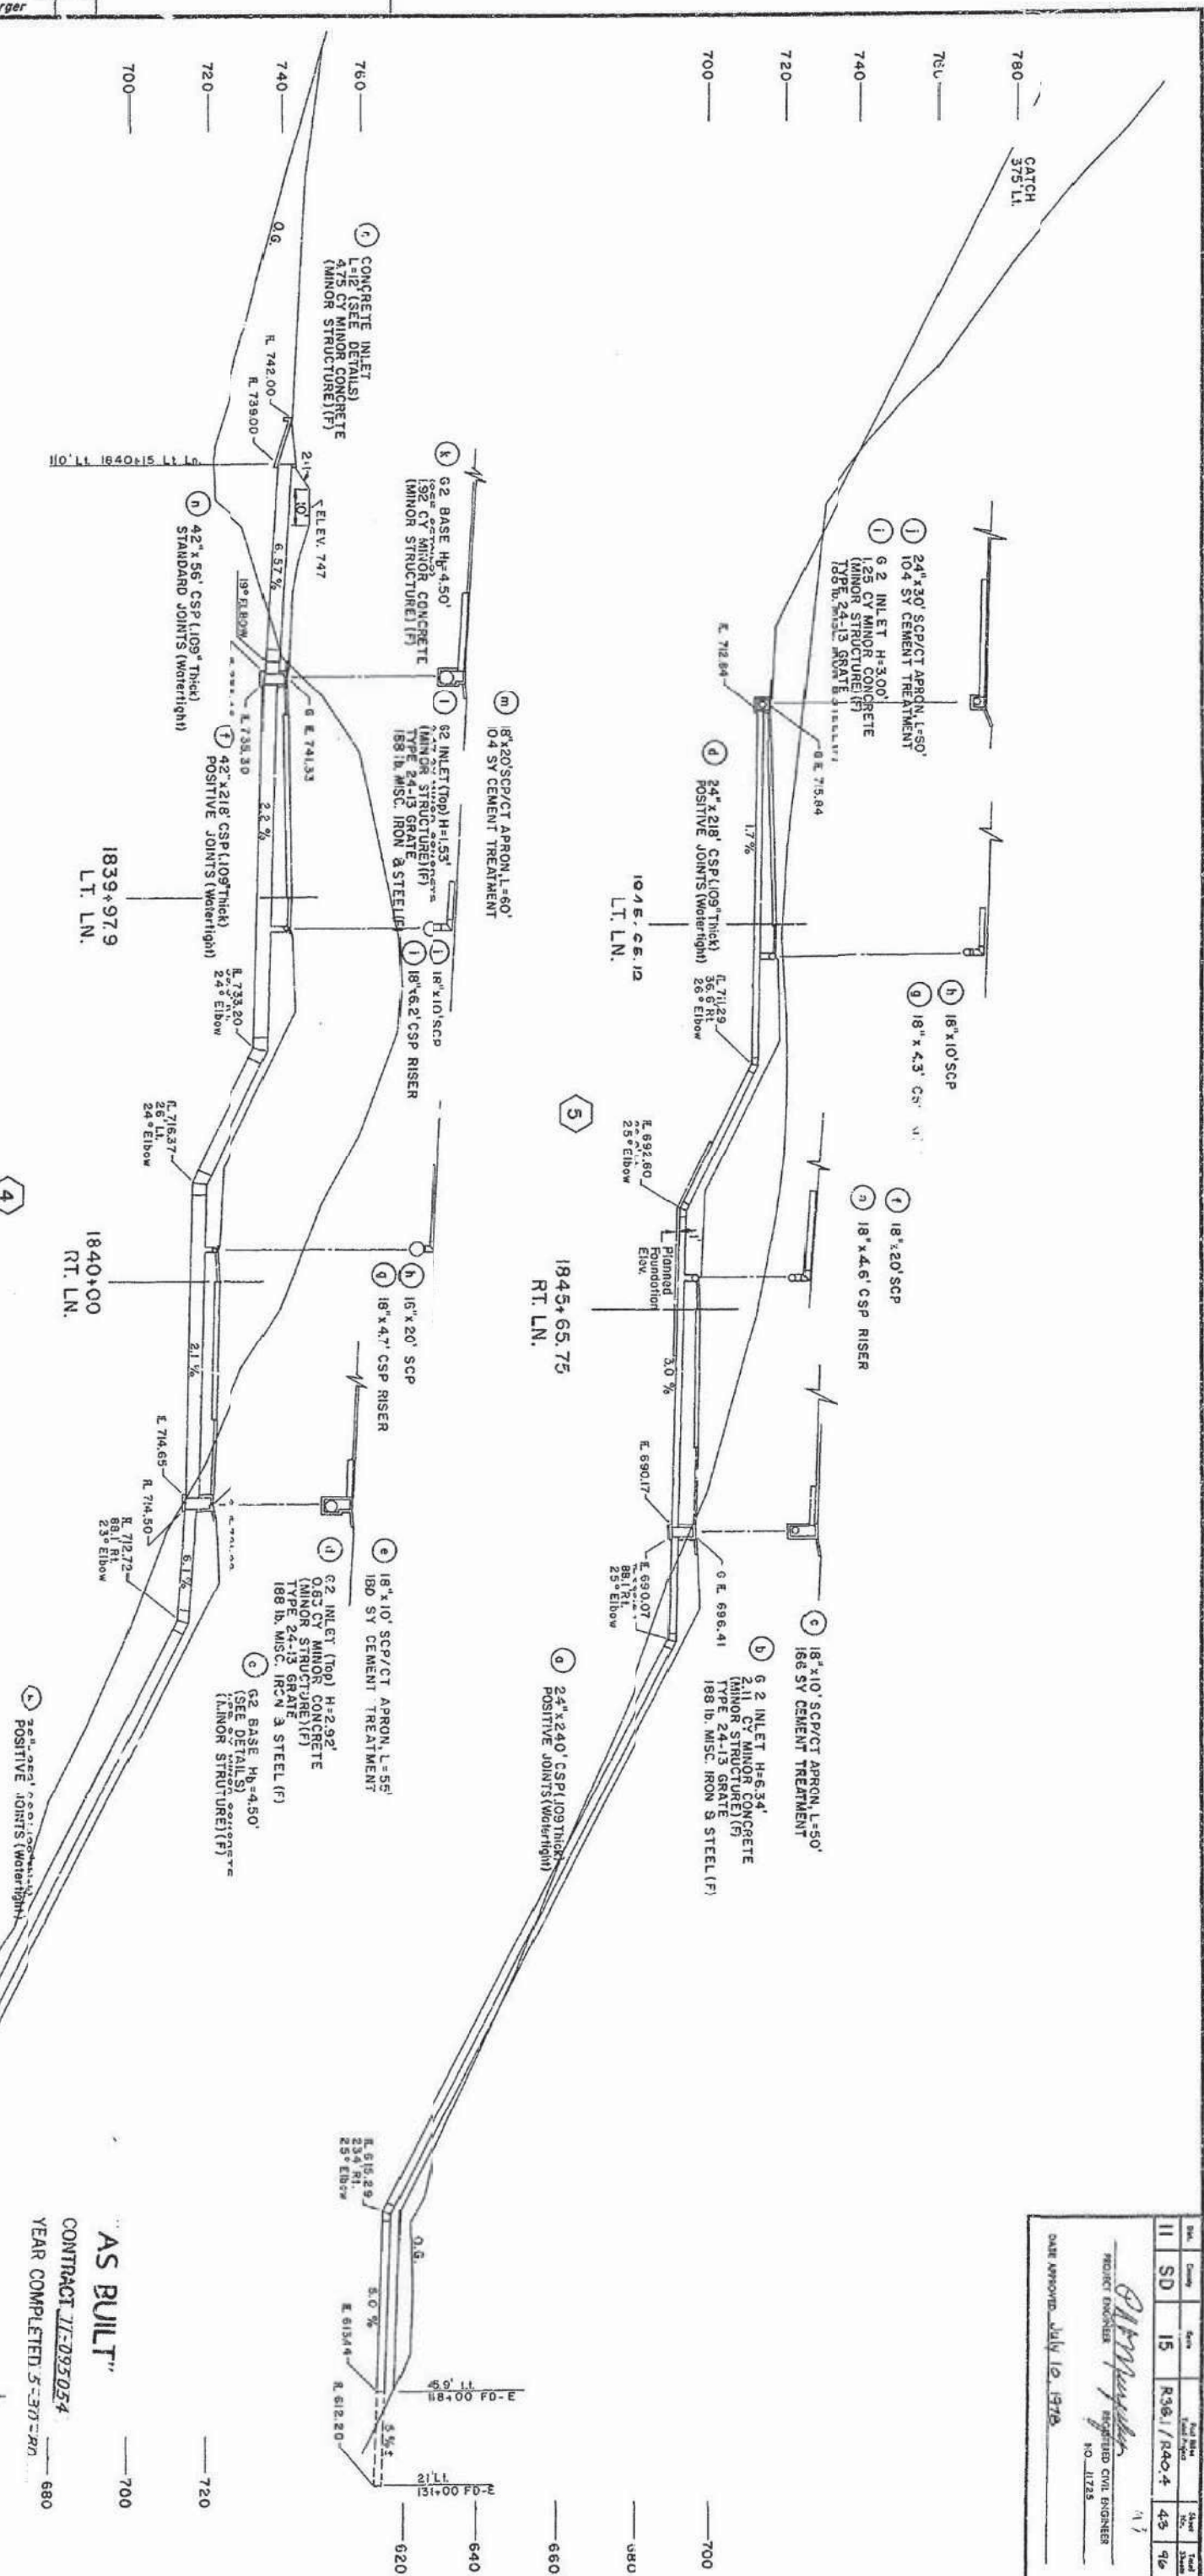

AS BUILT
 CONTRACT J1-095054
 YEAR COMPLETED 5-30-80

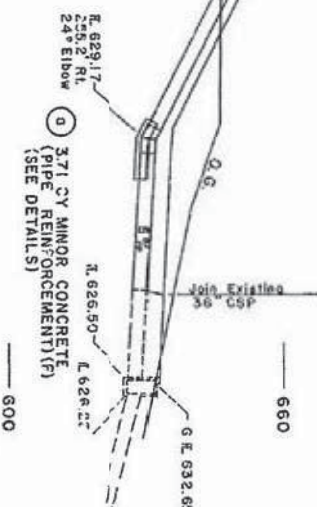

SEE DRAINAGE DETAILS SHEET 4 OF 4 FOR GENERAL NOTES

DRAINAGE PROFILES
 AND QUANTITIES
 SCALE: 1"=20' Sheet 2 of 15

Project Engineer	Date	Design Engineer	Date	Approval Recommended By	Date
RL Murphy		J. O. Gray		J. O. Grosberger	

Doc.	Conty.	Rev.	Final	Sheet	Scale
11	SD	15	R381/R404	44	9%

PROJECT ENGINEER


[Signature]

REGISTERED CIVIL ENGINEER

NO. 11723

DATE APPROVED

July 10, 1978

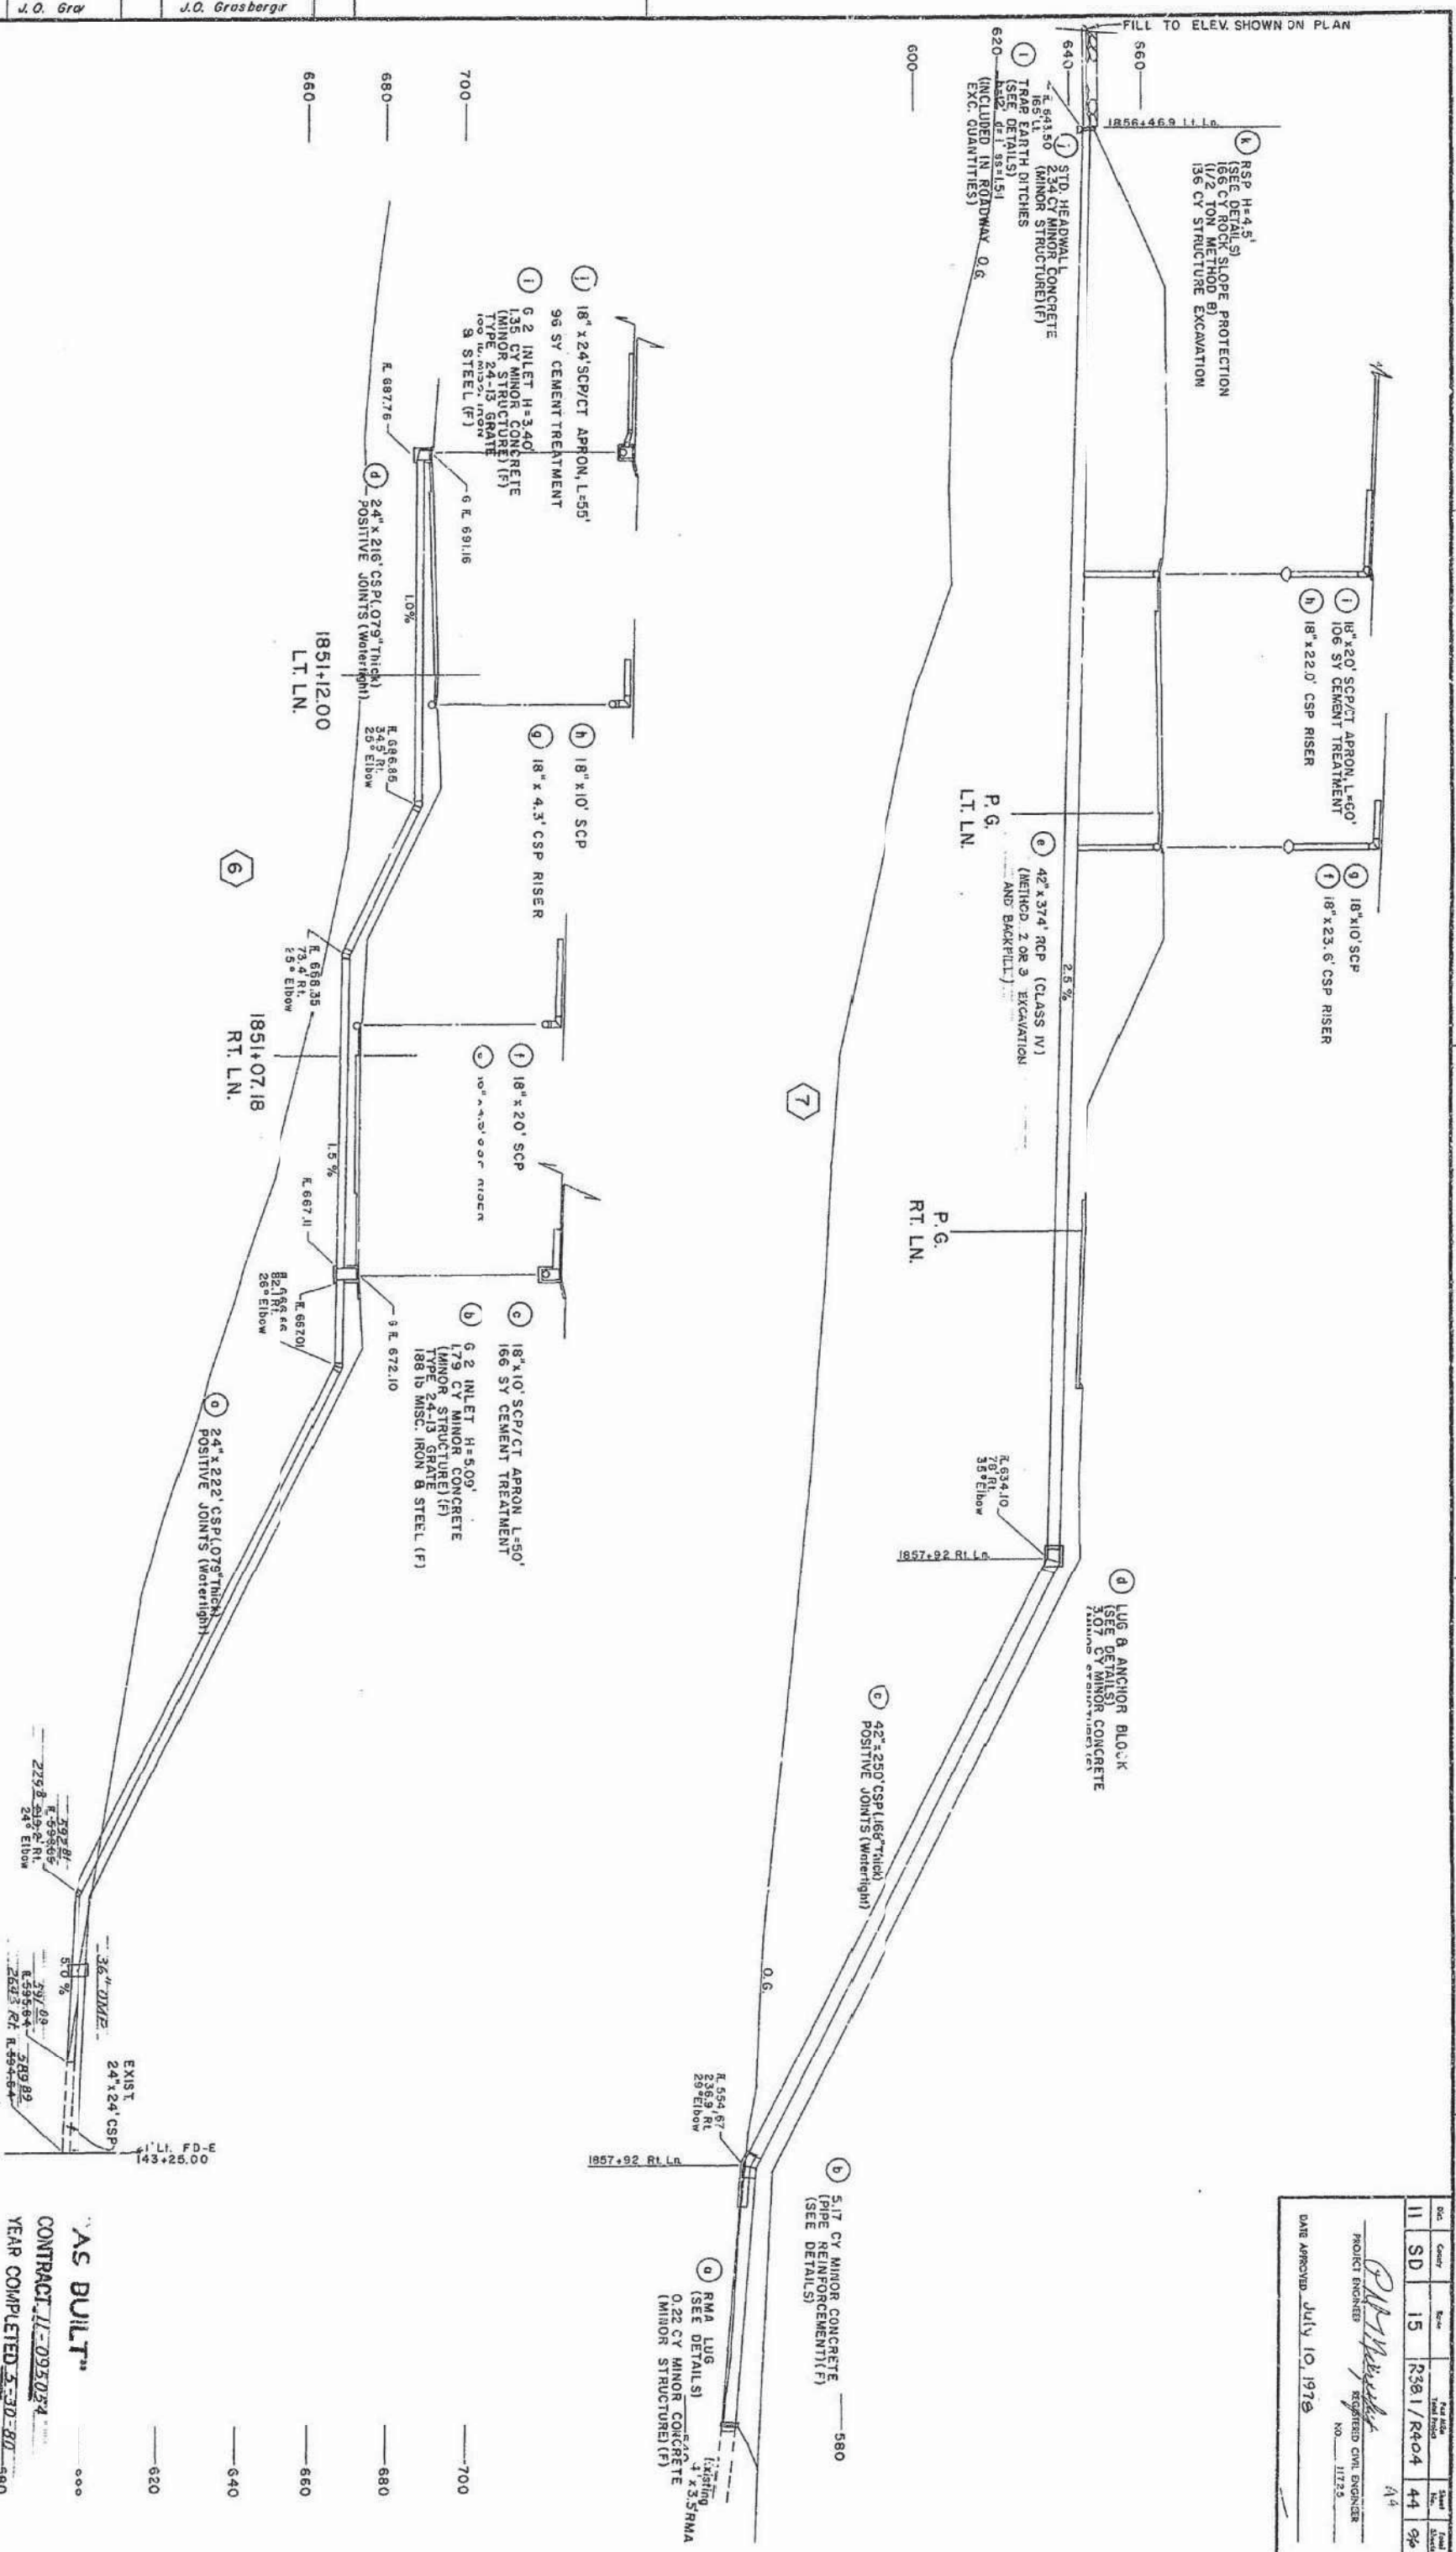

AS BUILT
CONTRACT 11-093034
YEAR COMPLETED 3-30-80

DRAINAGE PROFILES
AND QUANTITIES




SEE DRAINAGE DETAILS SHEET 4 OF 4 FOR GENERAL NOTES



Project Engineer	Date	Design Engineer	Date	Approval Recommended	Date
P. J. Murphy		J. O. Gray		J. O. Grasberger	

Sheet	Quantity	Station	Year	Sheet	Quantity
11	SD	15	R381/R404	46	90

DATE APPROVED July 10, 1978
 PROJECT ENGINEER
 NO. 11728

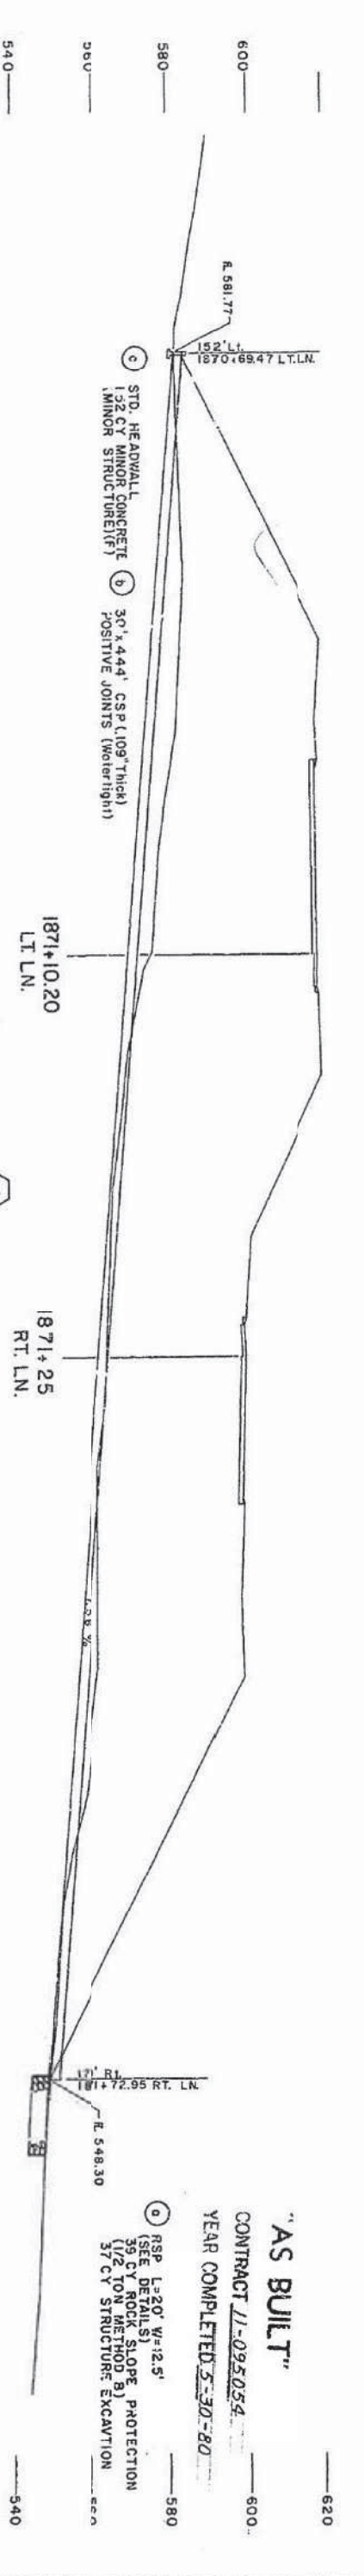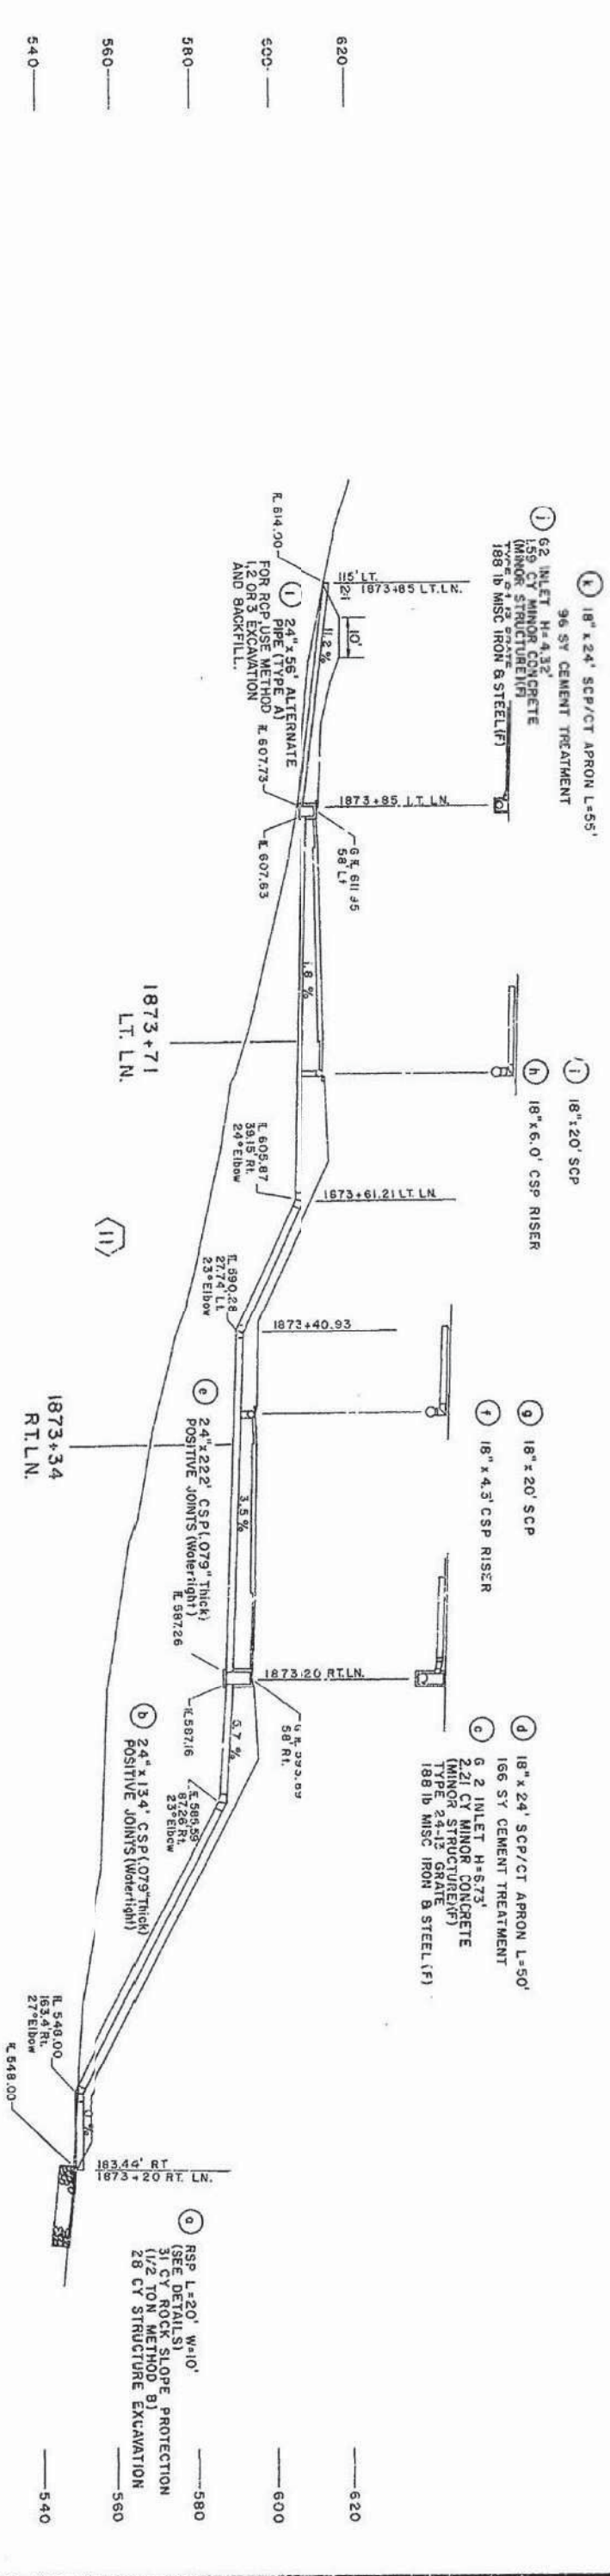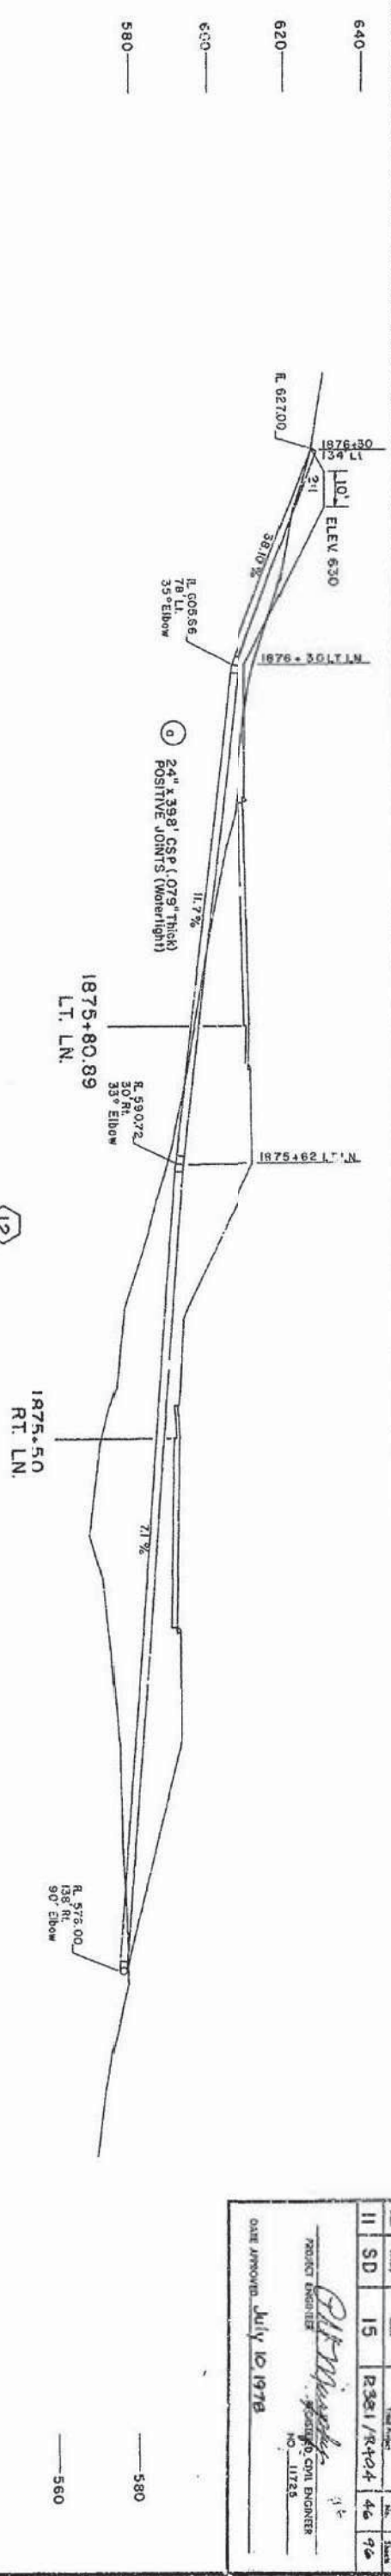


SEE DRAINAGE DETAILS SHEET 4 OF 4 FOR GENERAL NOTES
 FOR REDUCED PLANS
 ORIGINAL SCALE IS IN INCHES
 SCALE: 1"=20' Sheet 5 of 15

46

Project Engineer	Date	Design Engineer	Date	Approval (Sealed)	Date
P. L. Murphy		J. Q. Gray		J. Q. Grashberger	

"AS BUILT"
 CONTRACT 11-095054
 YEAR COMPLETED 5-30-80
 RSP L=20' W=10' (SEE DETAILS) 39 CY ROCK SLOPE PROTECTION (1/2 TON METHOD B) 37 CY STRUCTURE EXCAVATION


Proj. No.	Sheet No.	Scale	Proj. Name	Sheet No.	Scale
11 SD 15	R381/R404	47	96		
PROJECT ENGINEER <i>R.L. Murphy</i> REGISTERED CIVIL ENGINEER No. 11723					
DATE APPROVED July 10, 1978					

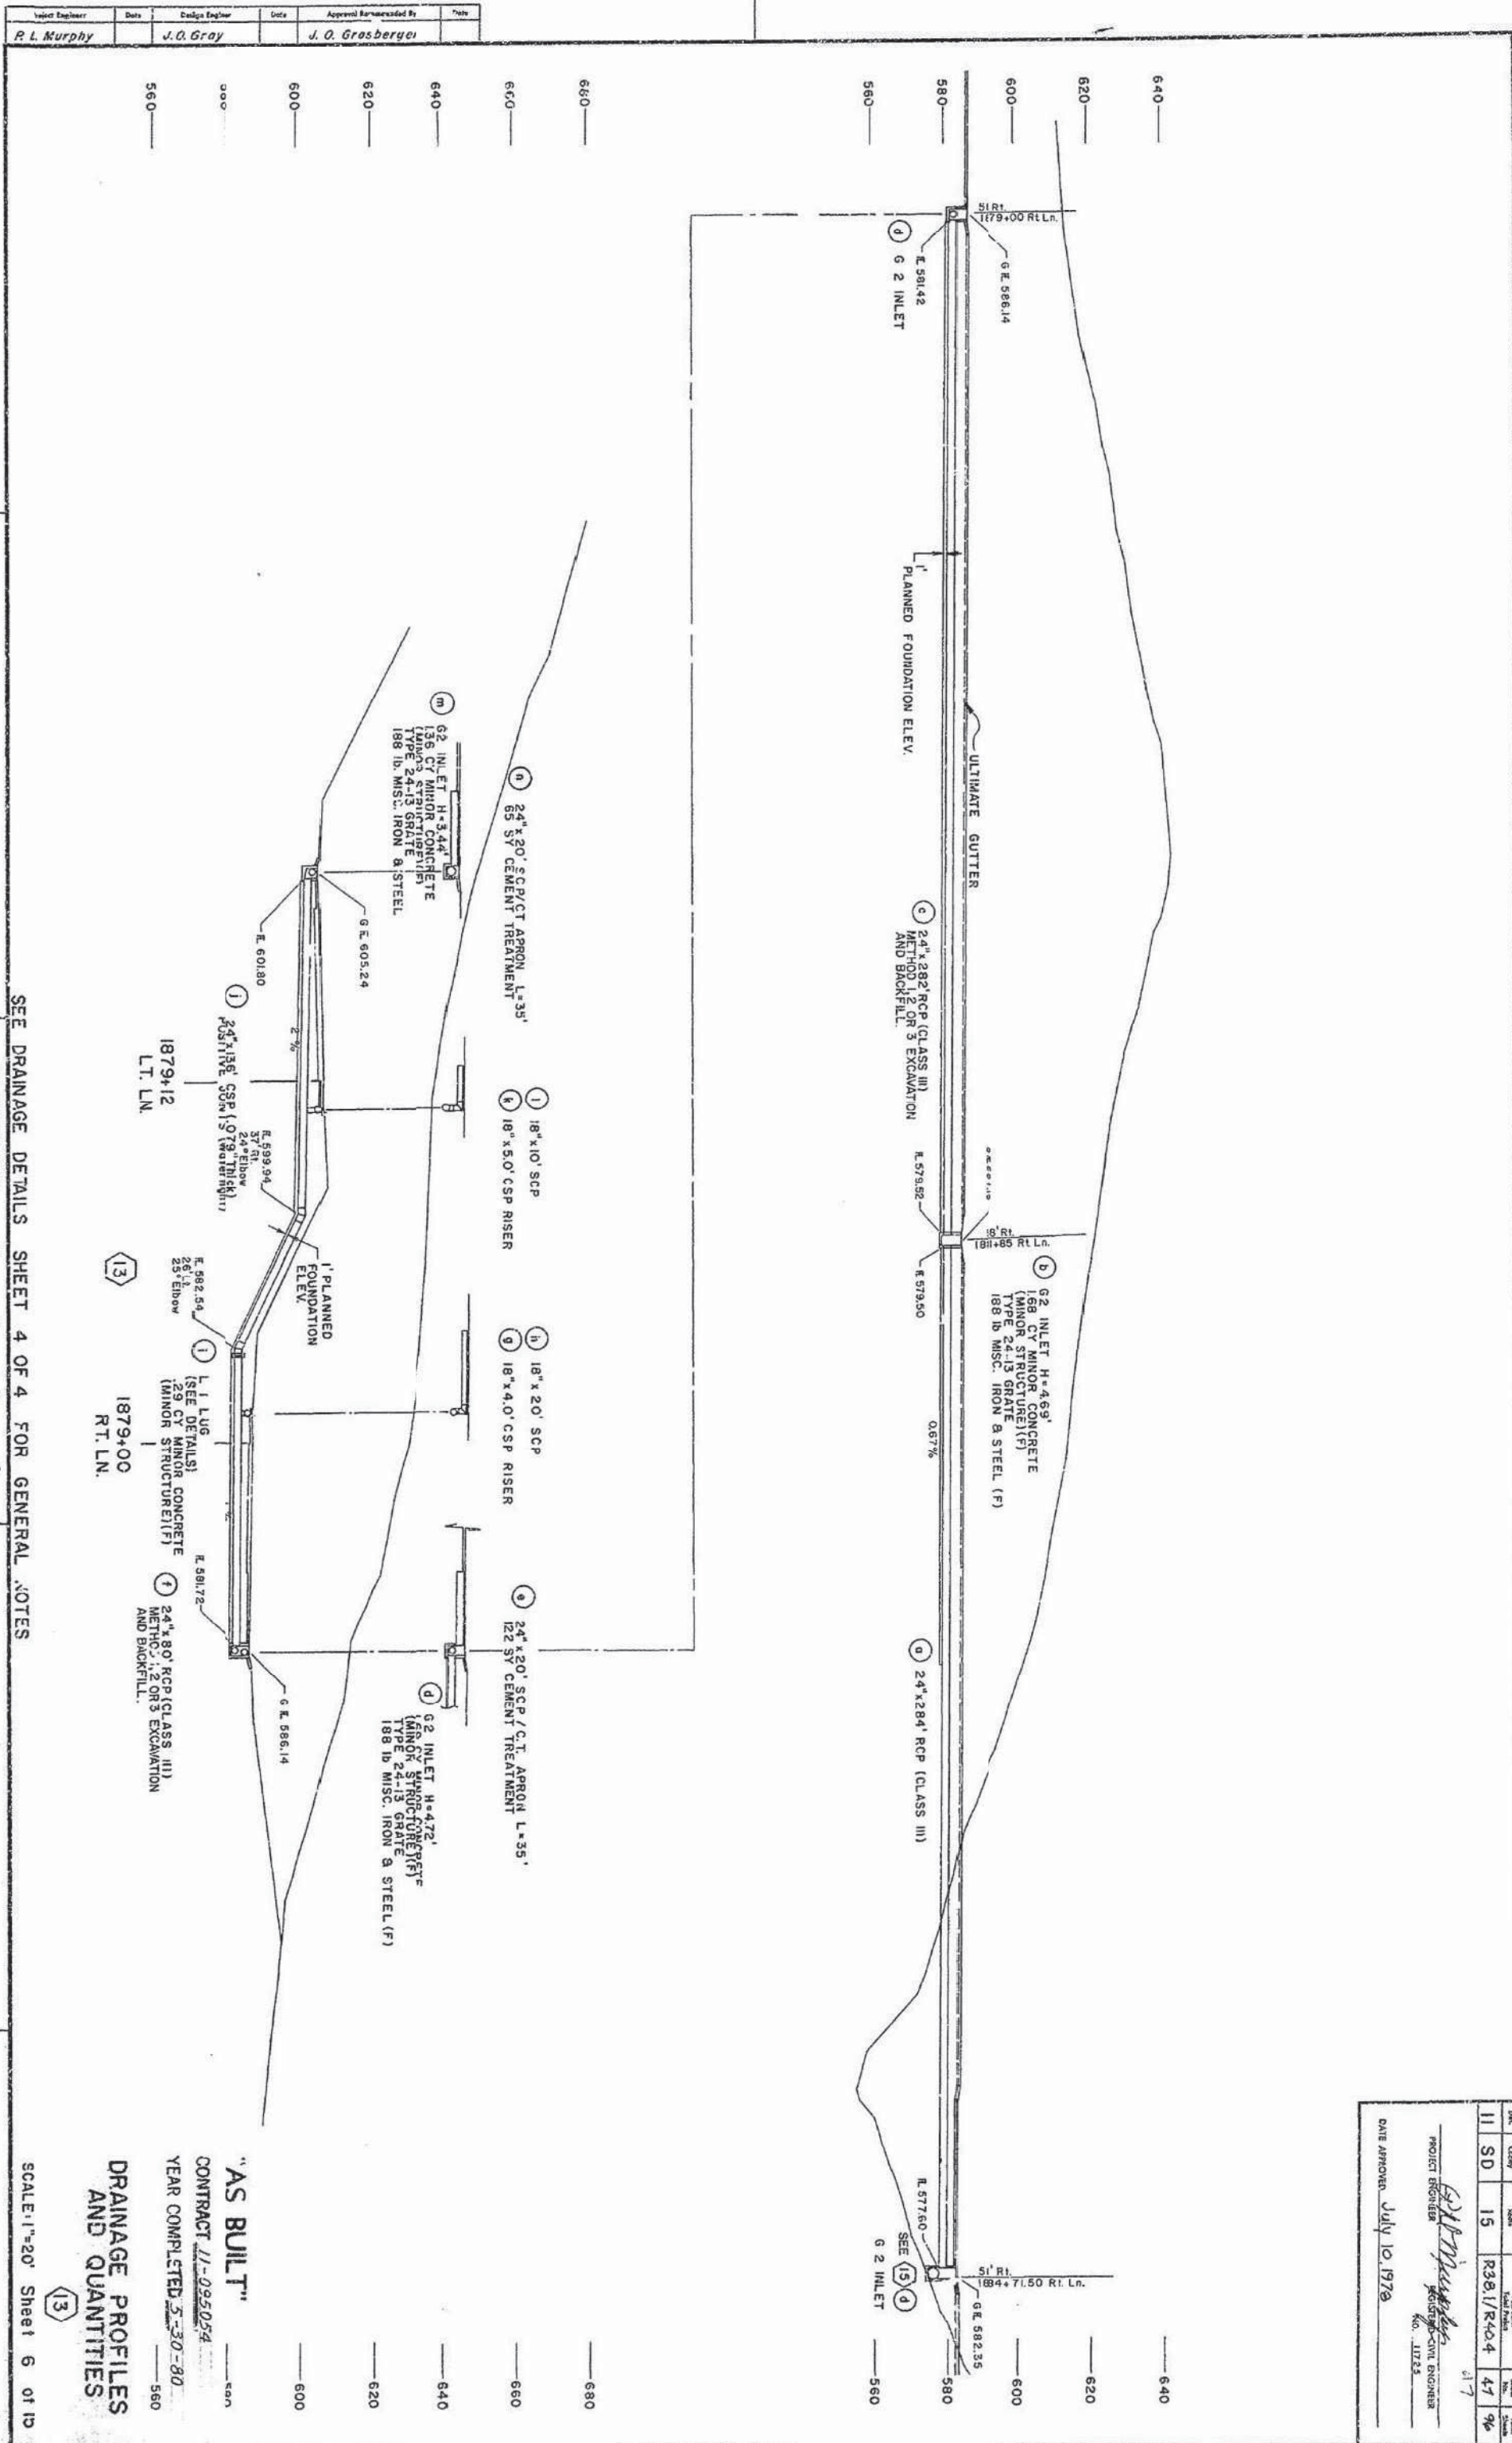

SEE DRAINAGE DETAILS SHEET 4 OF 4 FOR GENERAL NOTES

Rev.	Desc.	Issue	Total Issues	Total Sheets
11	SD	15	R261/R2404	48 96

PROJECT ENGINEER
 DATE APPROVED July 10, 1978
 NO. J1223

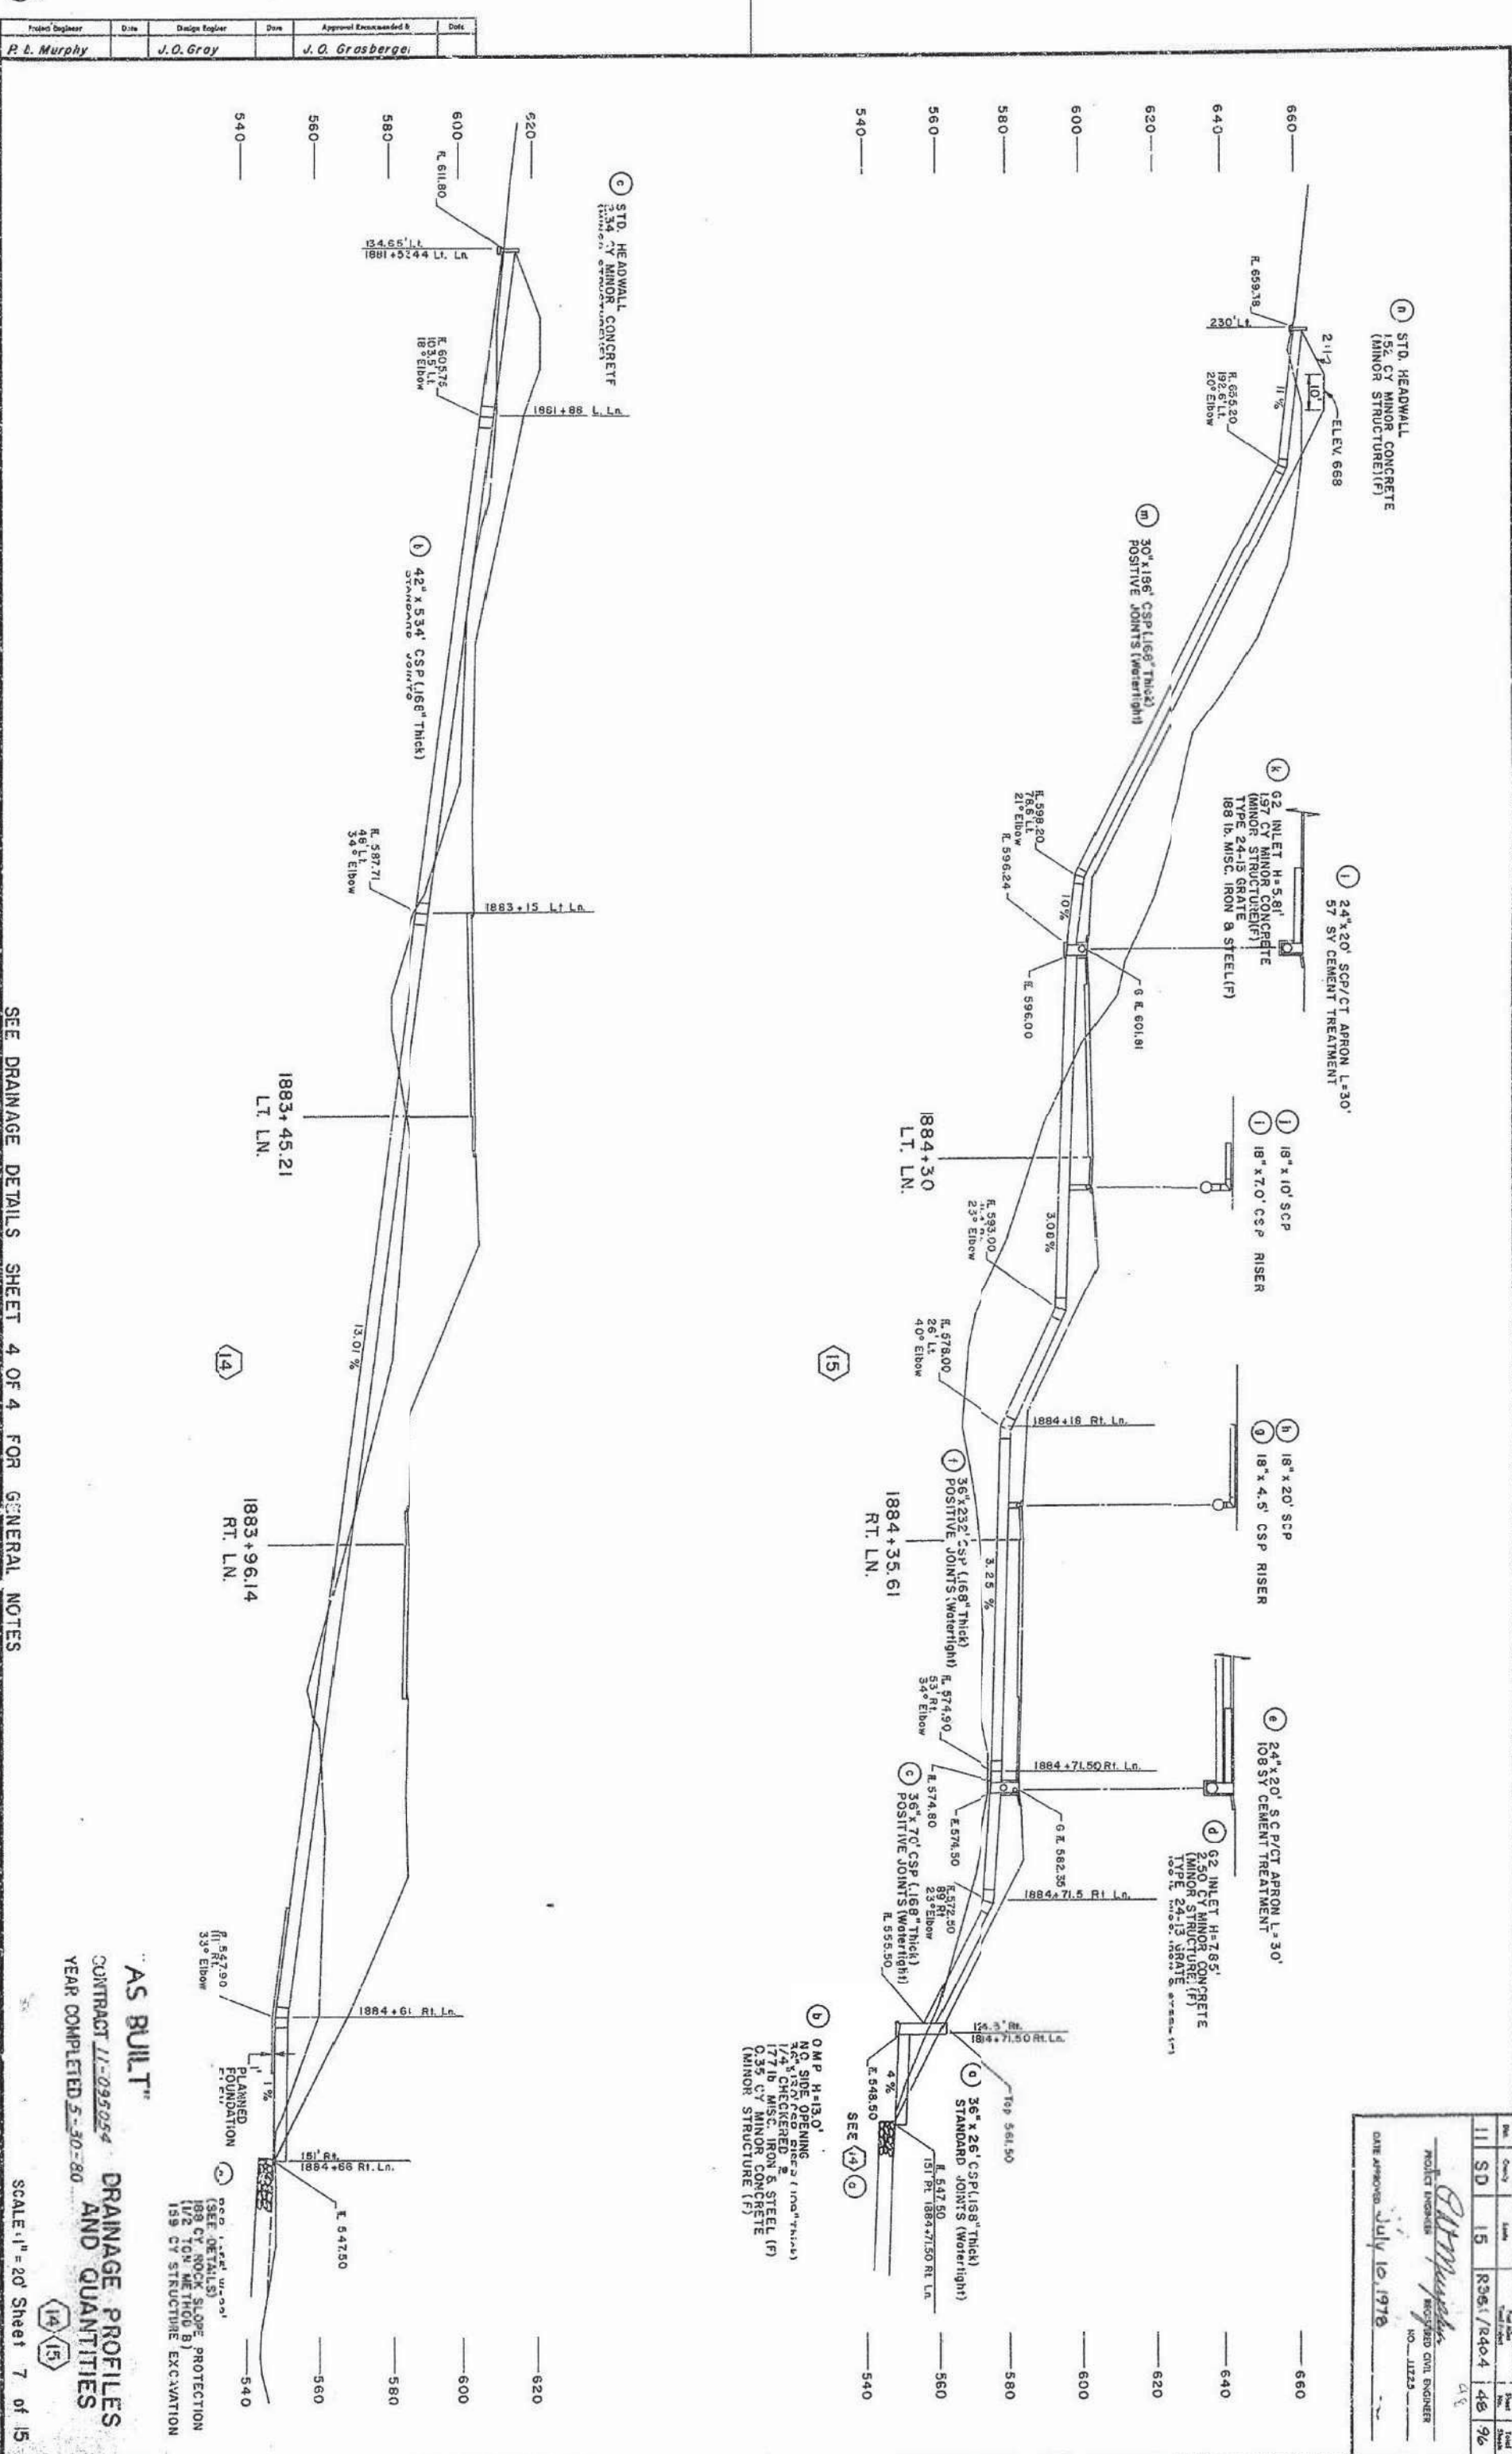

AS BUILT

CONTRACT 11-095024
 YEAR COMPLETED 5-30-80
 DRAINAGE PROFILES AND QUANTITIES

SEE DRAINAGE DETAILS SHEET 4 OF 4 FOR GENERAL NOTES



SCALE: 1" = 20' Sheet 7 of 15

Project Engineer	Date	Design Engineer	Date	Approval Encountered &	Date
P. L. Murphy		J. O. Gray		J. O. Grasberger	

Dist.	County	Sheet	Year Made	Sheet No.	Total Sheets
11	SB	15	R381/R404	49	96

PROJECT ENGINEER
[Signature]
REGISTERED CIVIL ENGINEER
NO. 11723

DATE APPROVED July 10, 1970

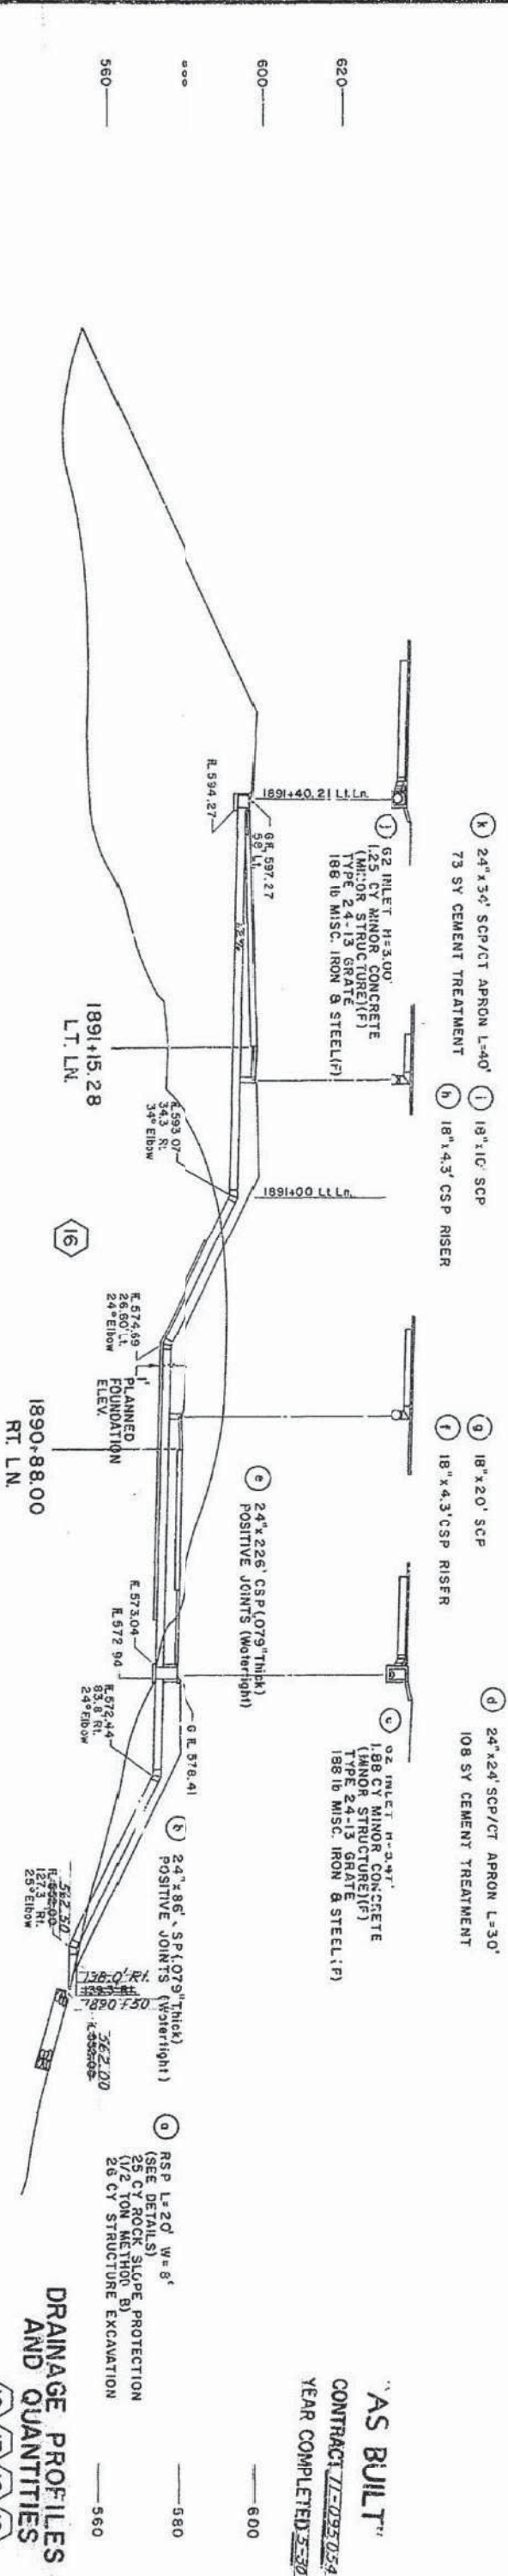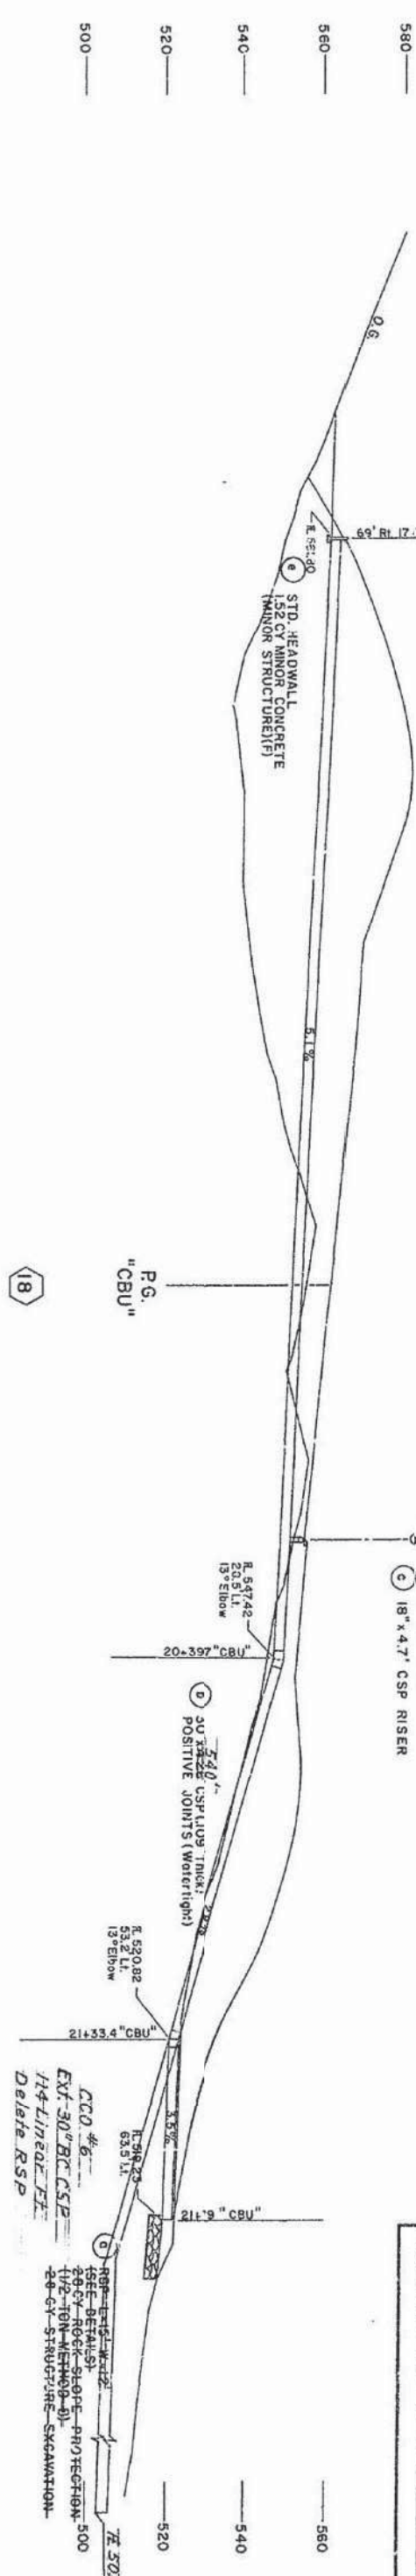


"AS BUILT"
CONTRACT U-093054
YEAR COMPLETED 1970-80

DRAINAGE PROFILES
AND QUANTITIES


SEE DRAINAGE DETAILS SHEET 4 OF 4 FOR GENERAL NOTES

FOR REDUCED PLANS
ORIGINAL SCALE IS IN INCHES

DATE	11 SD 15	2381/2404	50	96
PROJECT ENGINEER	<i>John J. Murphy</i>			
DATE APPROVED	July 10, 1976			
PROJECT ENGINEER	16007-20 CIVIL ENGINEER			
NO.	11223			

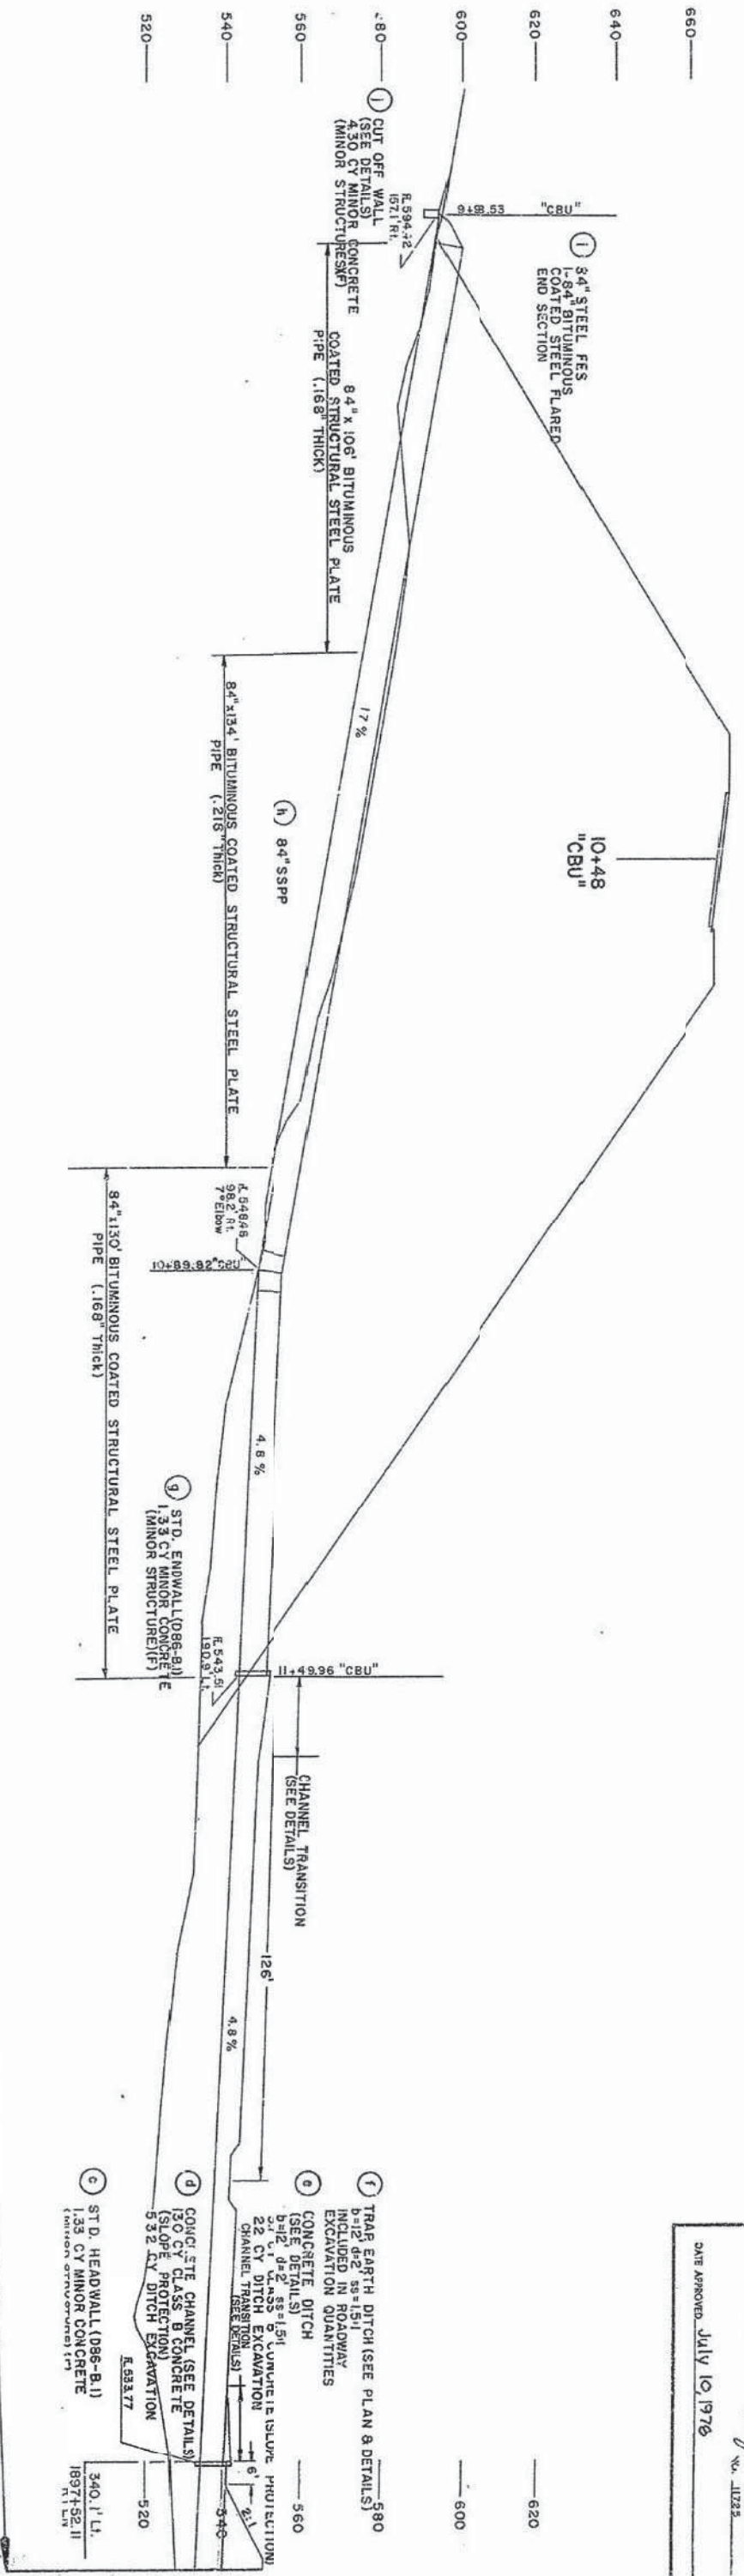

IDENTICAL

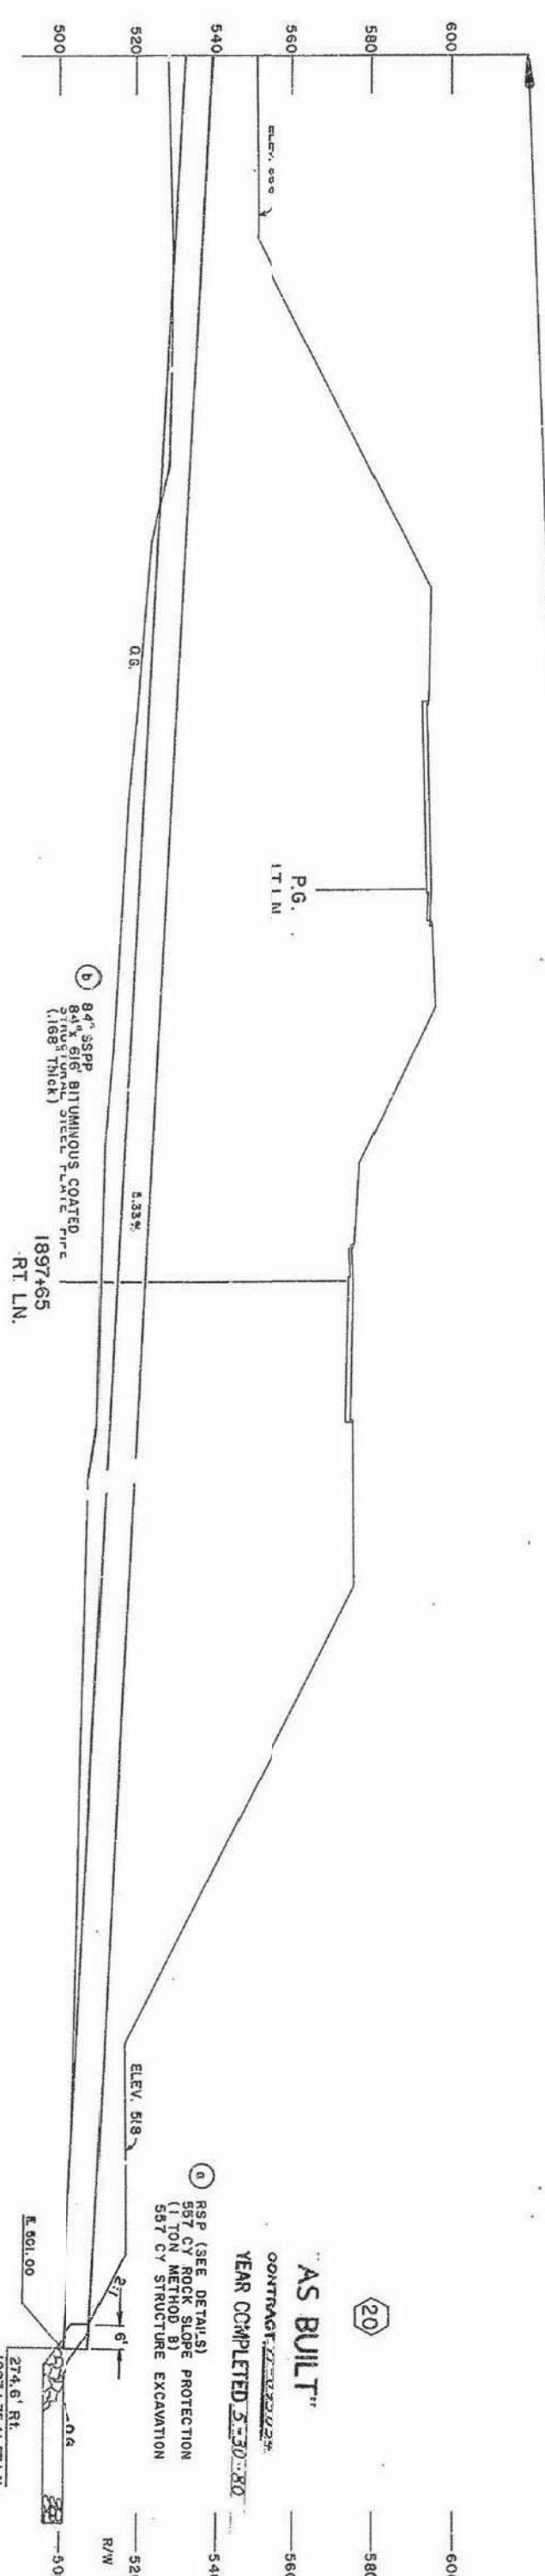

AS BUILT
CONTRACT: 22-22022
YEAR COMPLETED 5-30-80
RSP (SEE DETAILS)
557 CY ROCK SLOPE PROTECTION
(1 TON METHOD B)
557 CY STRUCTURE EXCAVATION

DRAINAGE PROFILES
AND QUANTITIES



SEE DRAINAGE DETAILS SHEET 4 OF 4 FOR GENERAL NOTES

FOR REDUCED PLANS
ORIGINAL SCALE IS IN INCHES

SCALE: 1"=20' Sheet 9 of 15

Project Engineer	Date	Design Engineer	Date	Approved/Recommended By	Date
P. L. Murphy		J. Q. Gray		J. Q. Grasberger	

Doc.	County	Sheet	Project	Scale	Sheet	Total
11	SB	15	R381/R40.4	51	96	
PROJECT ENGINEER <i>[Signature]</i> REGISTERED CIVIL ENGINEER NO. 11223						
DATE APPROVED July 10, 1978						

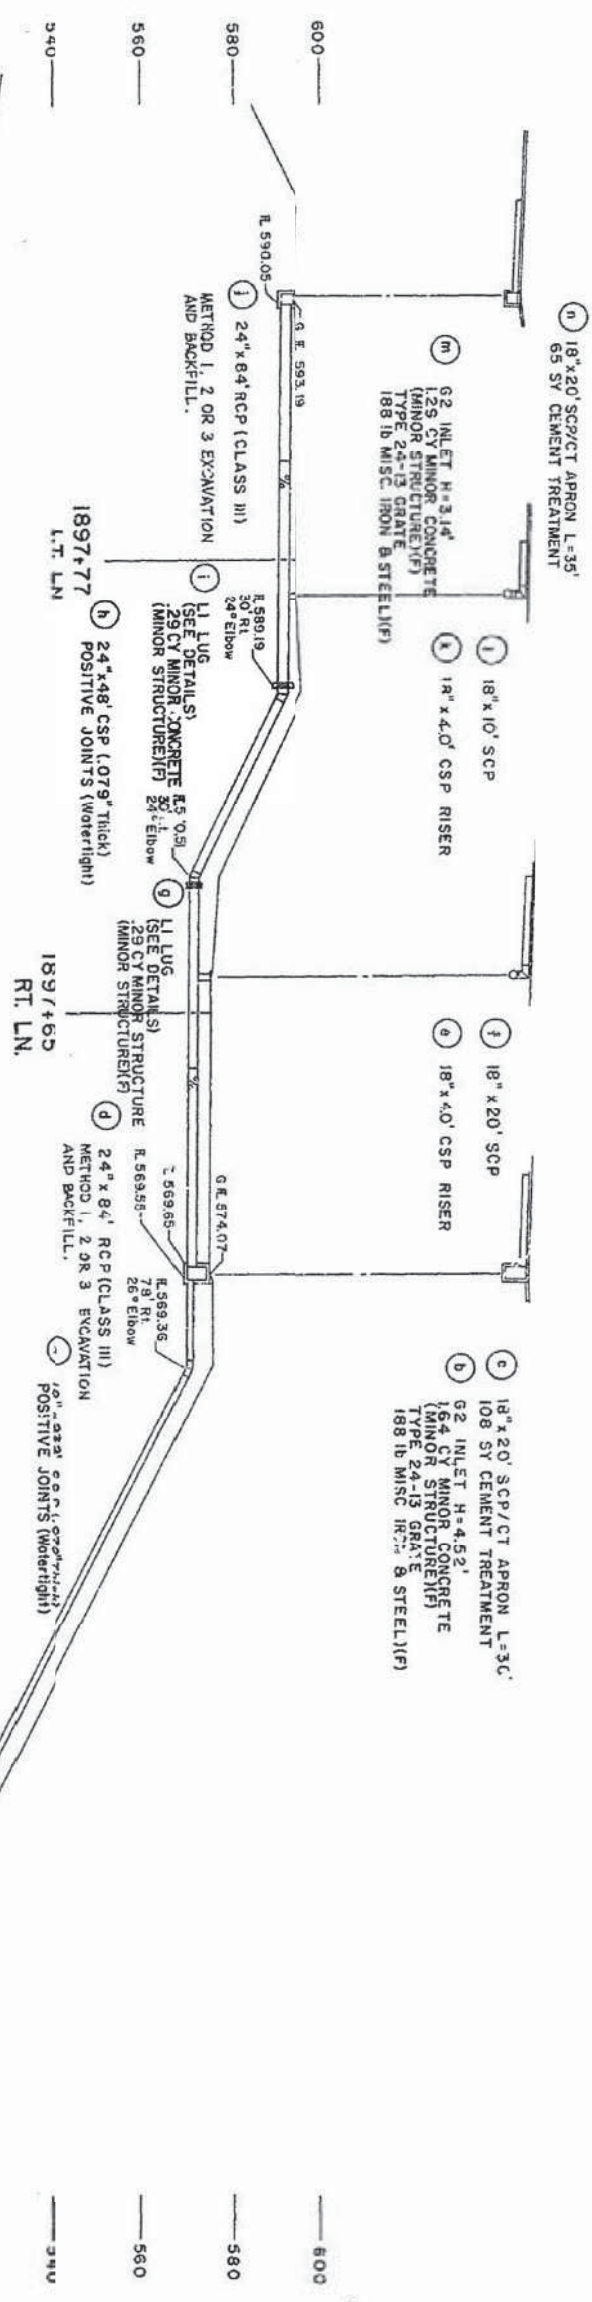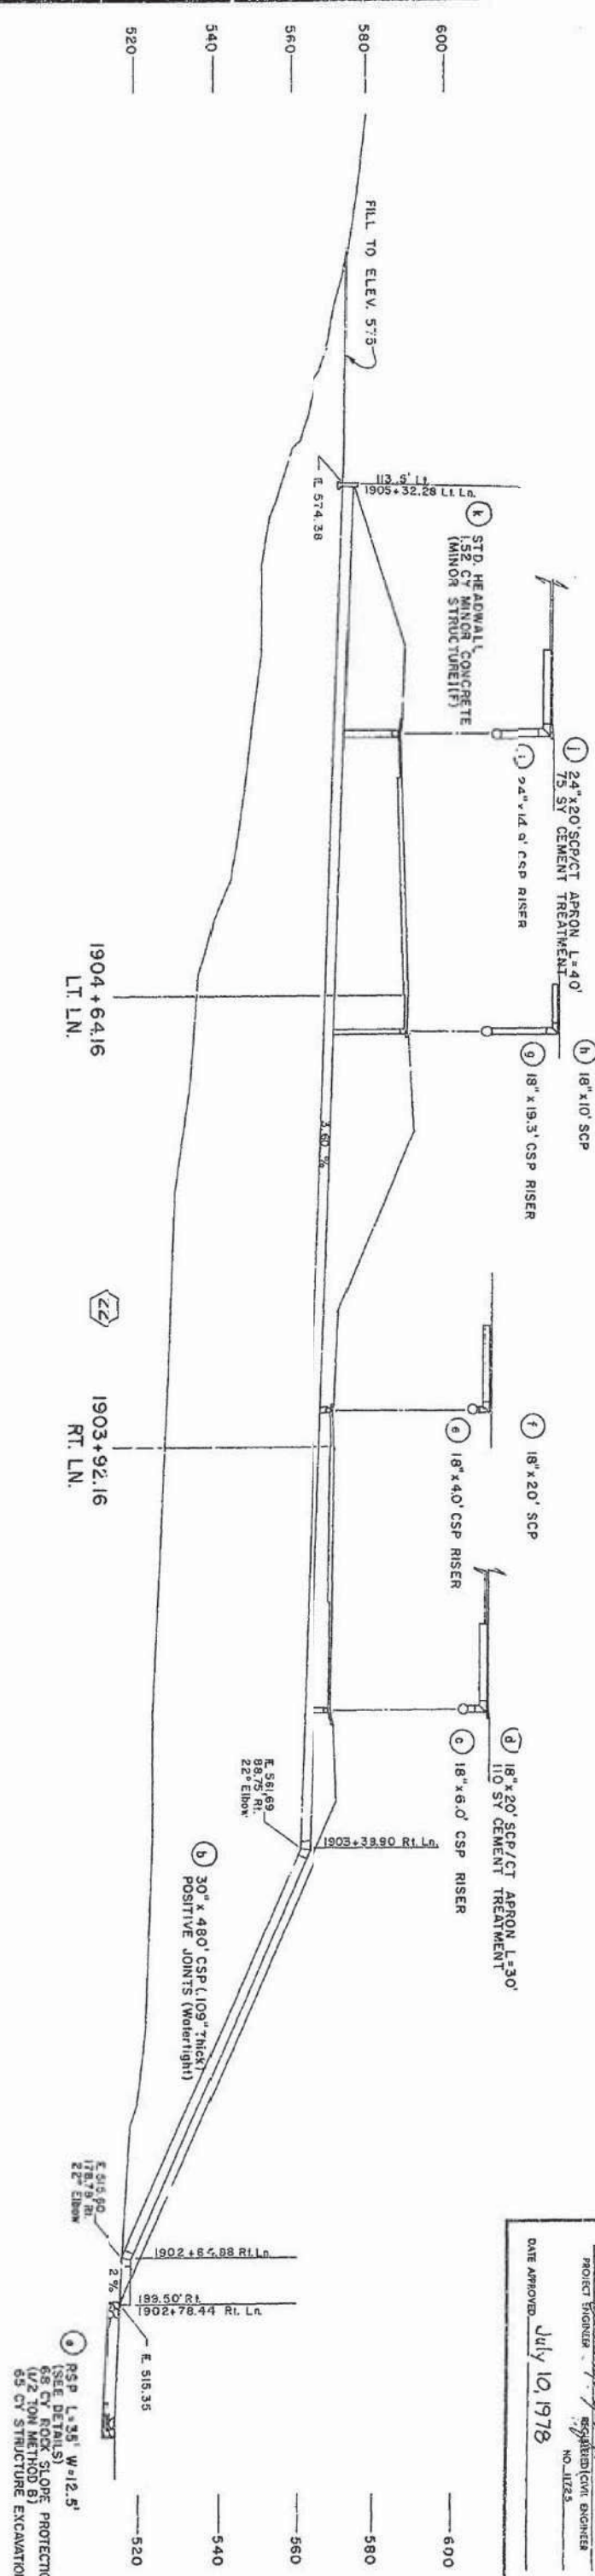

"AS BUILT"
CONTRACT 11-21982-2
YEAR COMPLETED 3-30-80

**DRAINAGE PROFILES
AND QUANTITIES**



SEE DRAINAGE DETAILS SHEET 4 OF 4 FOR GENERAL NOTES



SCALE: 1"=20' Sheet 10 of 15

Issued Engineer	Date	Design Engineer	Date	Approval Recommended By	Date
P. D. Murphy		J. Q. Gray		J. Q. Grosberger	

Dist.	County	Route	Sheet No.	Scale	Total
11	SD	15	R381/R404	52	96
PROJECT ENGINEER <i>P. D. Murphy</i> REGISTERED CIVIL ENGINEER NO. 11223					
DATE APPROVED July 10, 1978					

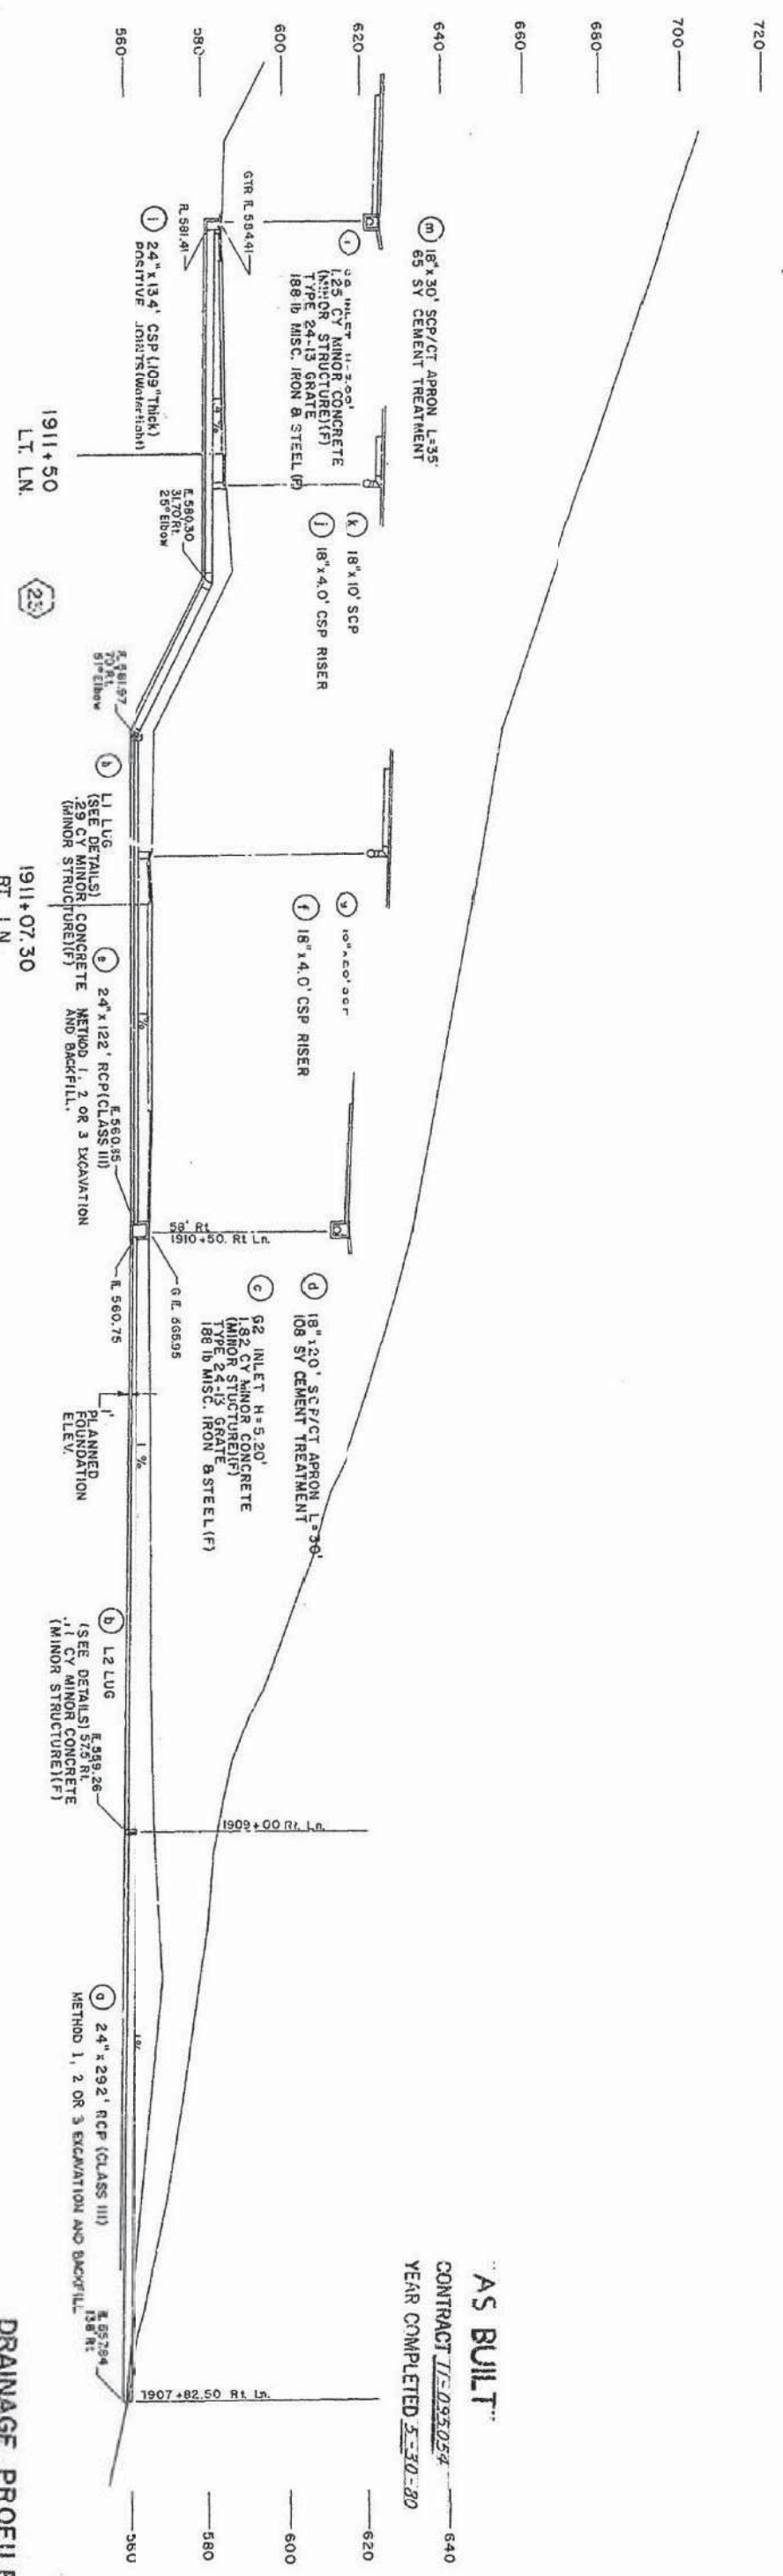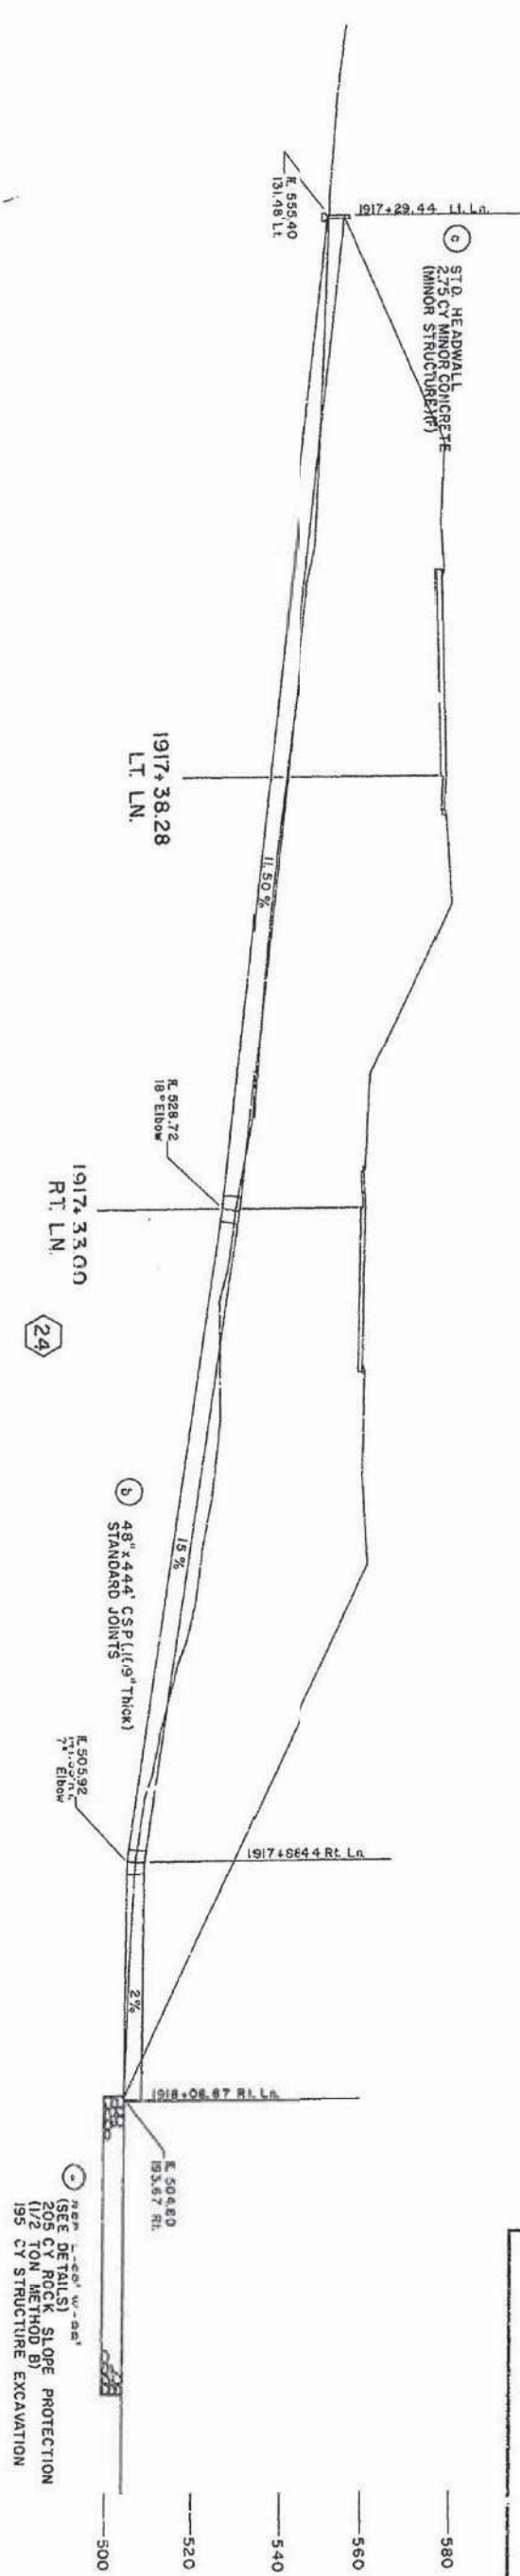

AS BUILT
CONTRACT 11-095054
YEAR COMPLETED 5-30-80

SEE DRAINAGE DETAILS SHEET 4 OF 4 FOR GENERAL NOTES
FOR REDUCED PLANS
ORIGINAL SCALE IS IN INCHES
SCALE: 1" = 20'
Sheet 11 of 15