

Day	Country	State	Year Bldg.	Year Rehab.	Class	Room	Time
11	SD	15	R381/R304	53	96		

57

PROJECT ENGINEER *D. H. M. [Signature]*

REGISTERED CIVIL ENGINEER

NO. 11725

DATE APPROVED July 10, 1978

**DRAINAGE PROFILES
AND QUANTITIES**


"AS BUILT" _____ 540
CONTRACT 11-095054 _____
YEAR COMPLETED 5-30-80 _____ 520

Date	Category	Hour	Total Fees Paid	Hour No.	Total Amount
11	SD	15	R381/R404	54	96

54

PROJECT ENGINEER
REGISTERED CIVIL ENGINEER
NO. 11228

DATE APPROVED: July 10, 1978.

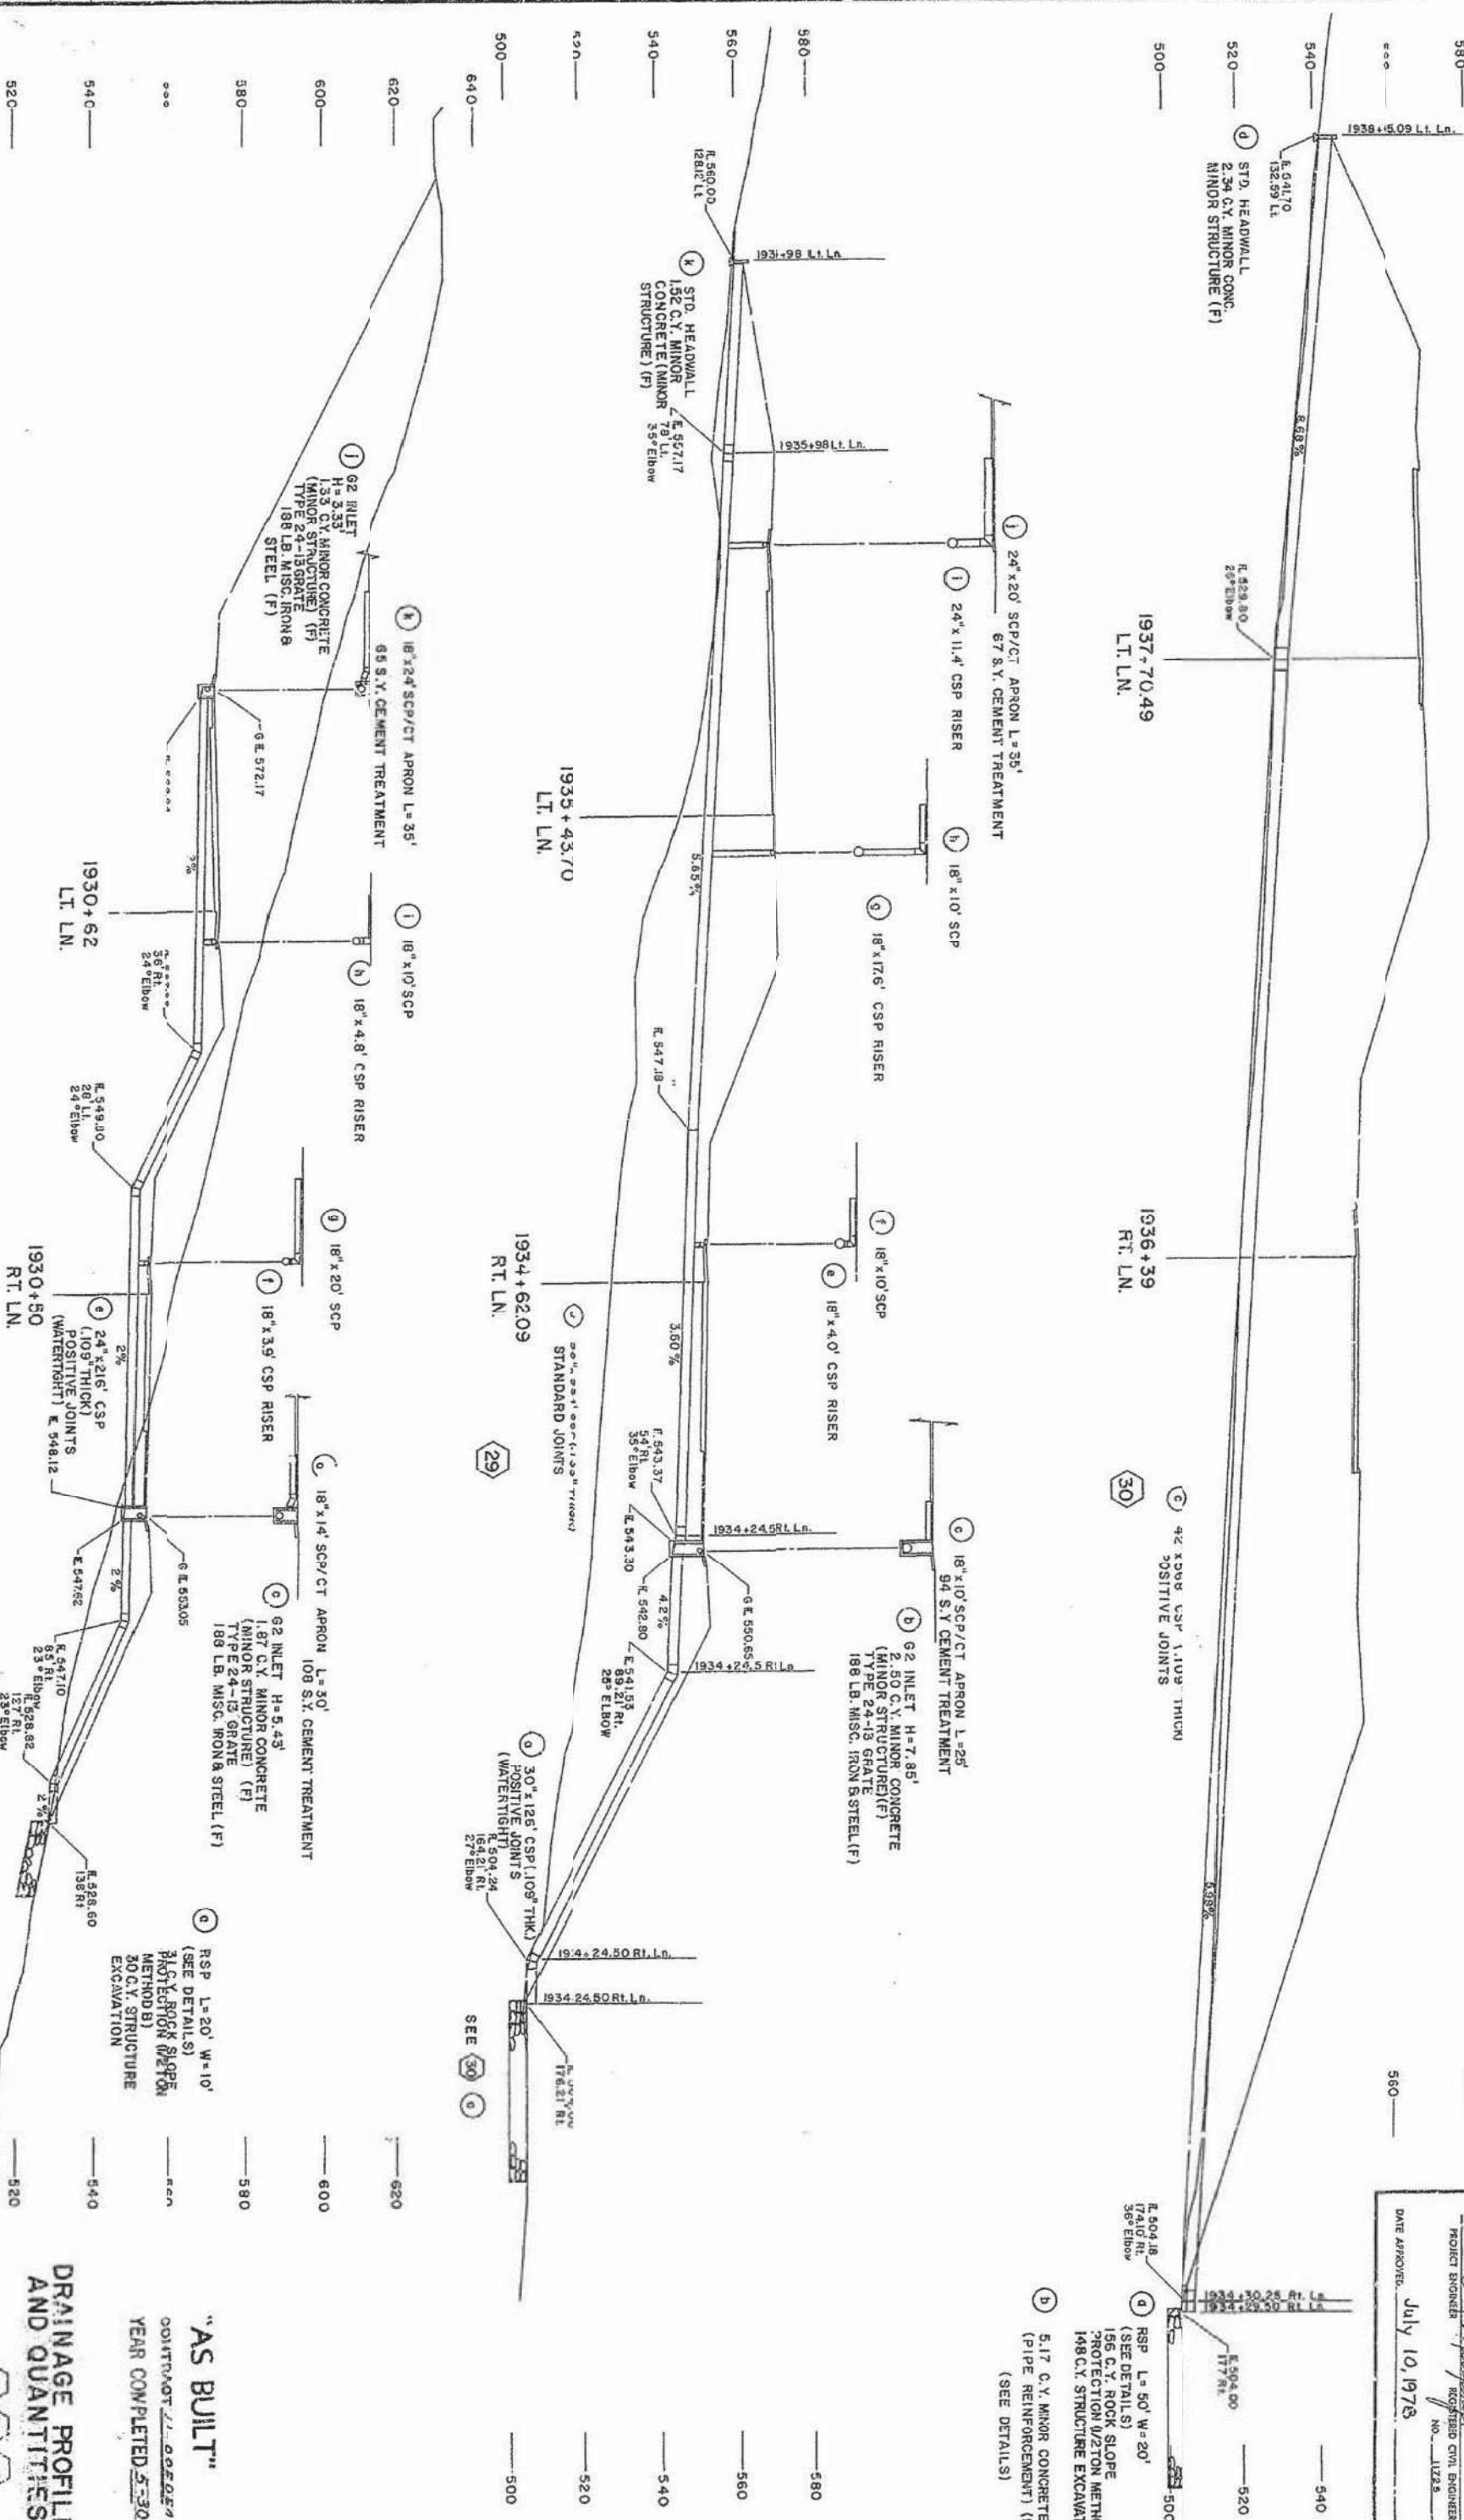

SEE DRAINAGE DETAILS SHEET 4 OF 4 FOR GENERAL NOTES

FOR REDUCED PLANS
ORIGINAL SCALE IS 1/8"

SCALE: 1"=20' Sheet 15 of 15


28 29 30

DRAINAGE PROFILES AND QUANTITIES

CONTRACT 71-005054
YEAR COMPLETED 5-30-61

"AS BUILT"

Dist.	County	State	Project No.	Sheet No.	Total Sheets
11	SD	15	R38118-444	55	96
PROJECT ENGINEER			REGISTERED CIVIL ENGINEER		
DATE APPROVED			JULY 10, 1978		

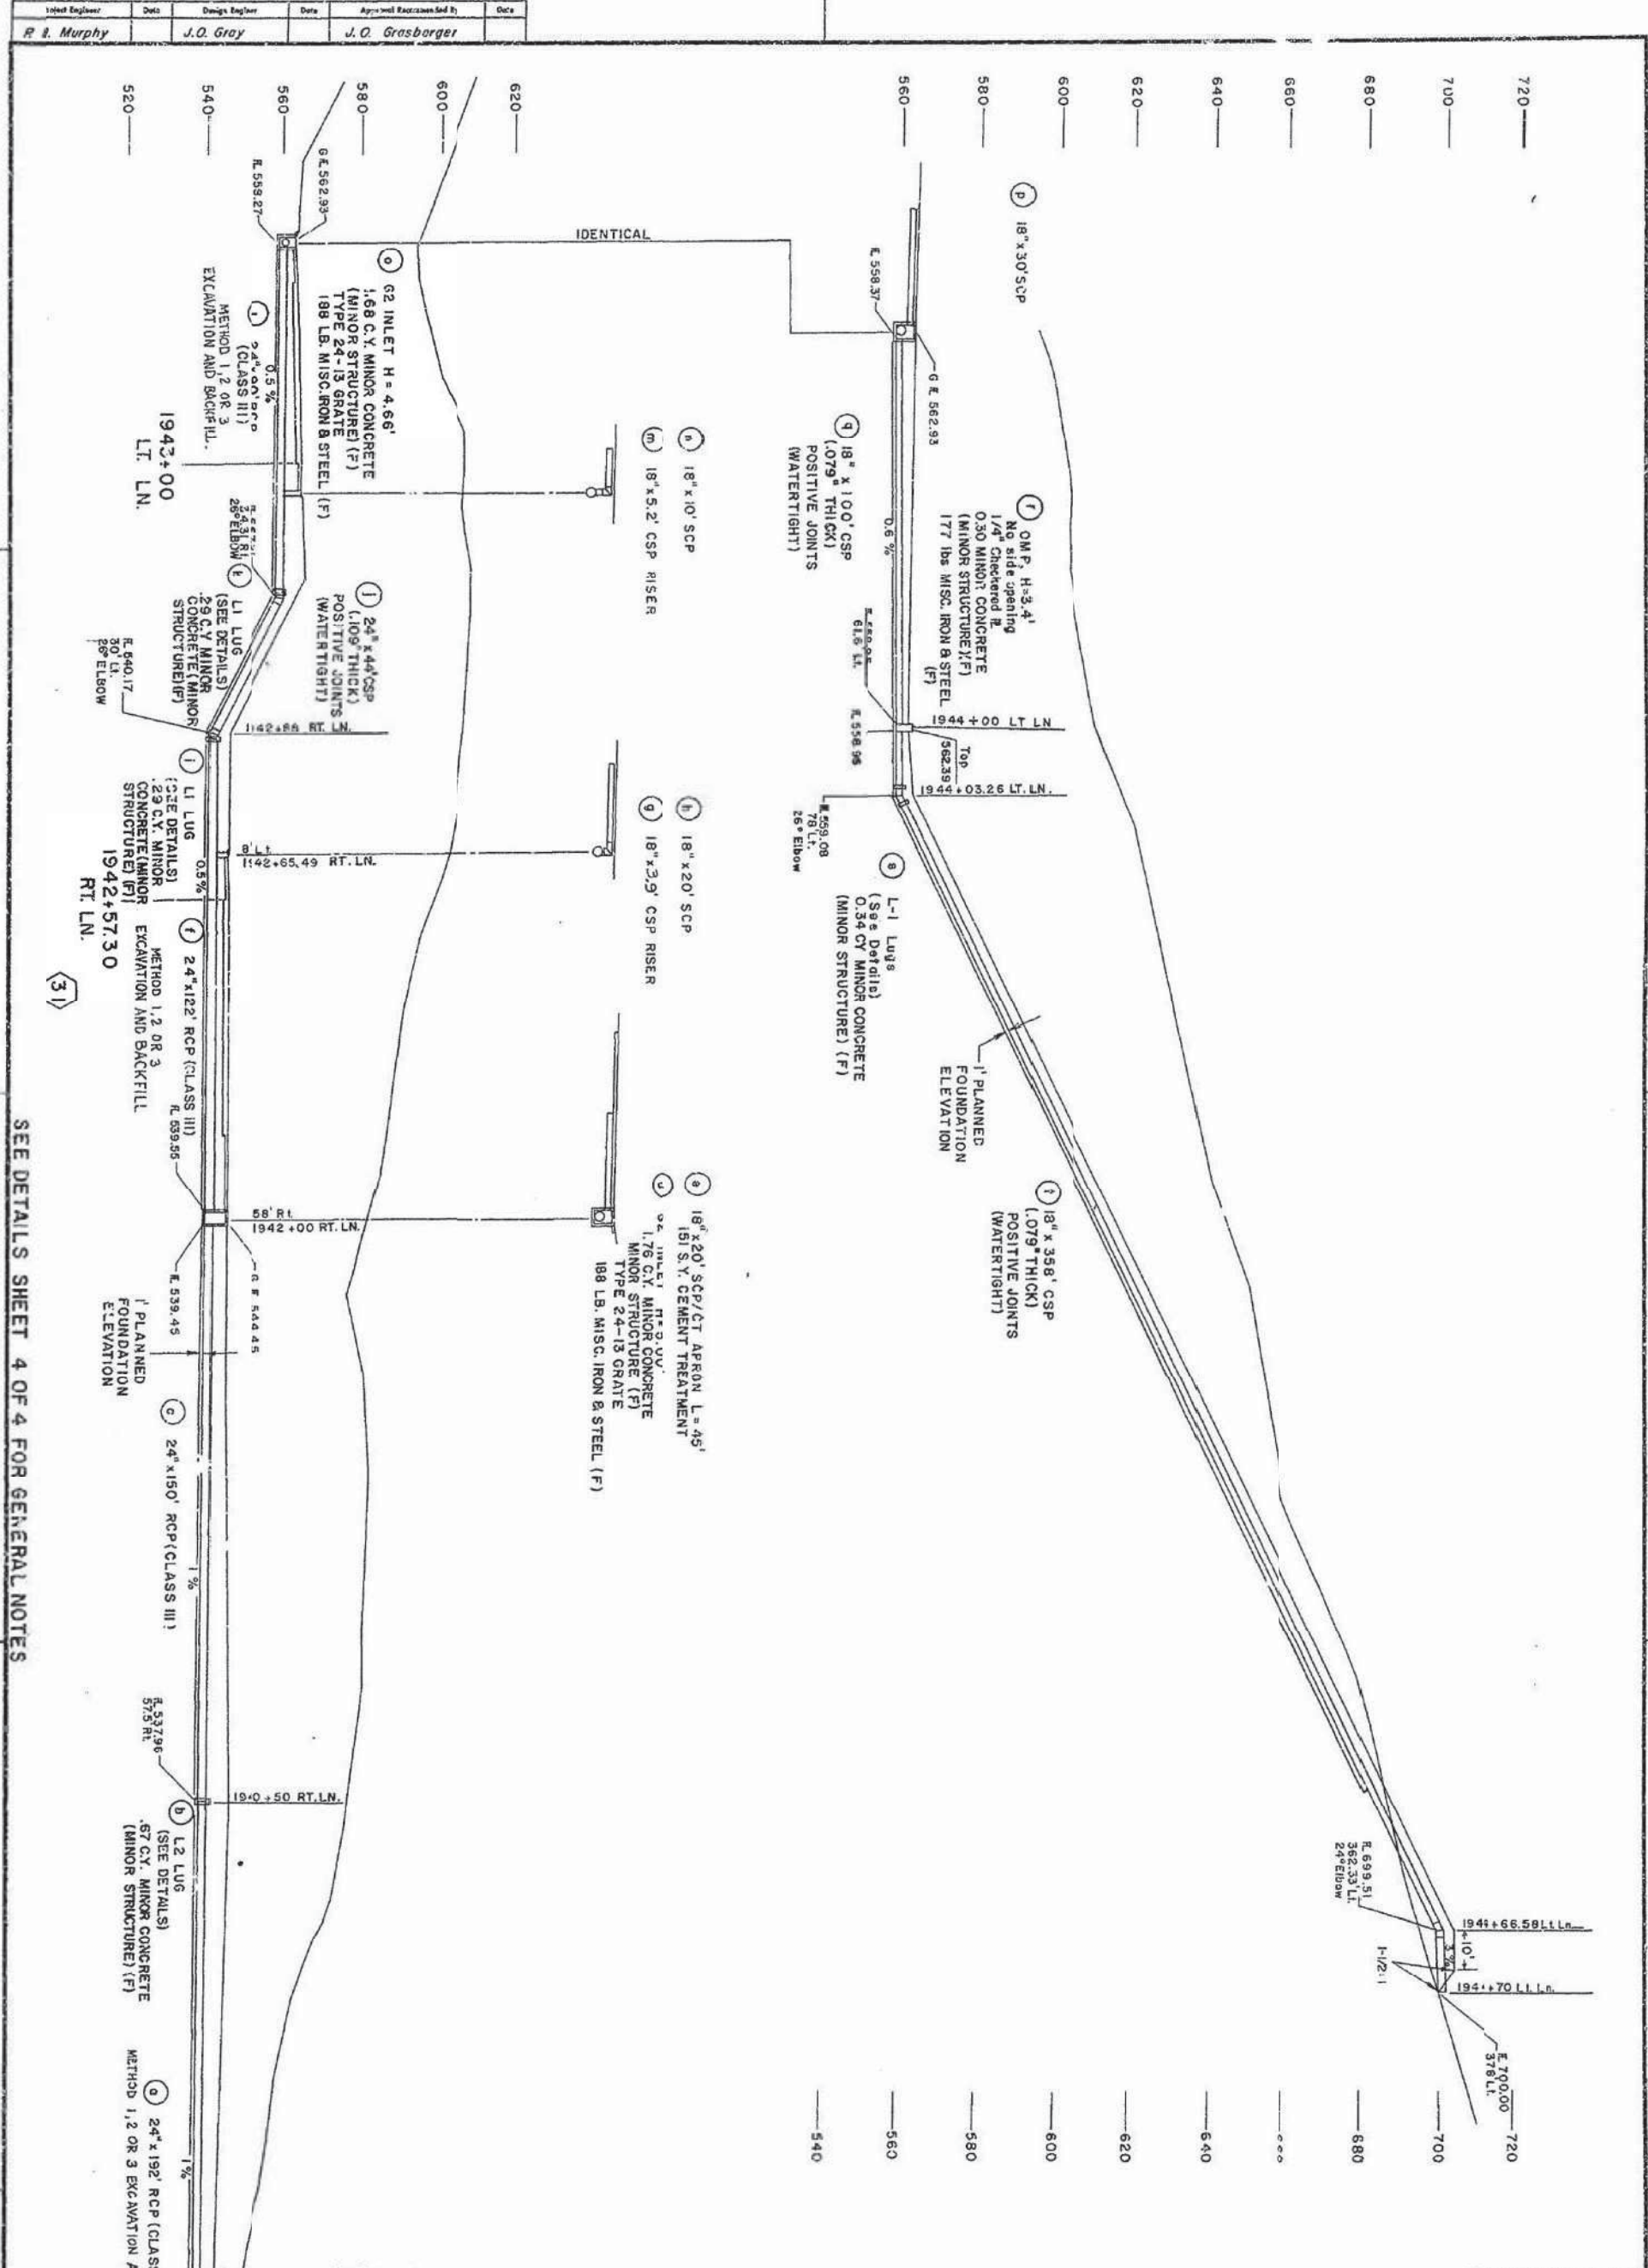

"AS BUILT"
CONTRACT 11-073034
YEAR COMPLETED 1970-72

SEE DETAILS SHEET 4 OF 4 FOR GENERAL NOTES

FOR REDUCED PLANS
ORIGINAL SCALE IS IN INCHES



SCALE 1"=20' Sheet 14 of 15


DRAINAGE PROFILES
AND QUANTITIES

INDEX OF SHEETS	
Sheet No.	Title Sheet
1	Typical Cross Section
2 - 5	Standard Plans List
6	Plan
7	Profile
8 - 20	Drainage Profiles
21 - 38	Drainage Layouts and Contour Grading
39 - 54	Drainage Details
55 - 72	Drainage List
73 - 81	Drainage Details
82 - 92	Drainage Details
93 - 106	Special Details
107	Miscellaneous Quantities & Details
108 - 120	Utility Plans
121 - 124	Temporary Connections
125 - 126	Traffic Handling
127 - 130	Debris
131 - 144	Traffic Plan
145 - 146	Traffic Plan - Signs, Signals, Guard Rail, Markers, & Permanent Markers
149 - 157	Overhead Signs
158	Embankment Service Equipment & Special Details
159 - 161	Lighting & Sign Illumination
162 - 171	BRIDGE STRUCTURE
1	Over Springs Road Intersecting (S. No. 57-81)
1 - 111	Cross Section


STATE OF CALIFORNIA
BUSINESS AND TRANSPORTATION AGENCY
DEPARTMENT OF TRANSPORTATION

I-015-4(48)36

PROJECT PLANS FOR CONSTRUCTION ON
STATE HIGHWAY
IN SAN DIEGO COUNTY NEAR ESCONDIDO
FROM 0.6 MILE SOUTH TO 1.5 MILES NORTH OF
DEER SPRINGS ROAD OVERCROSSING
To be supplemented by Standard Plans dated January 1975

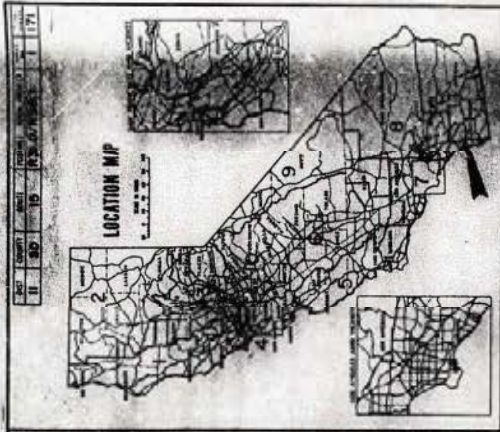

COUNTY OF SAN DIEGO

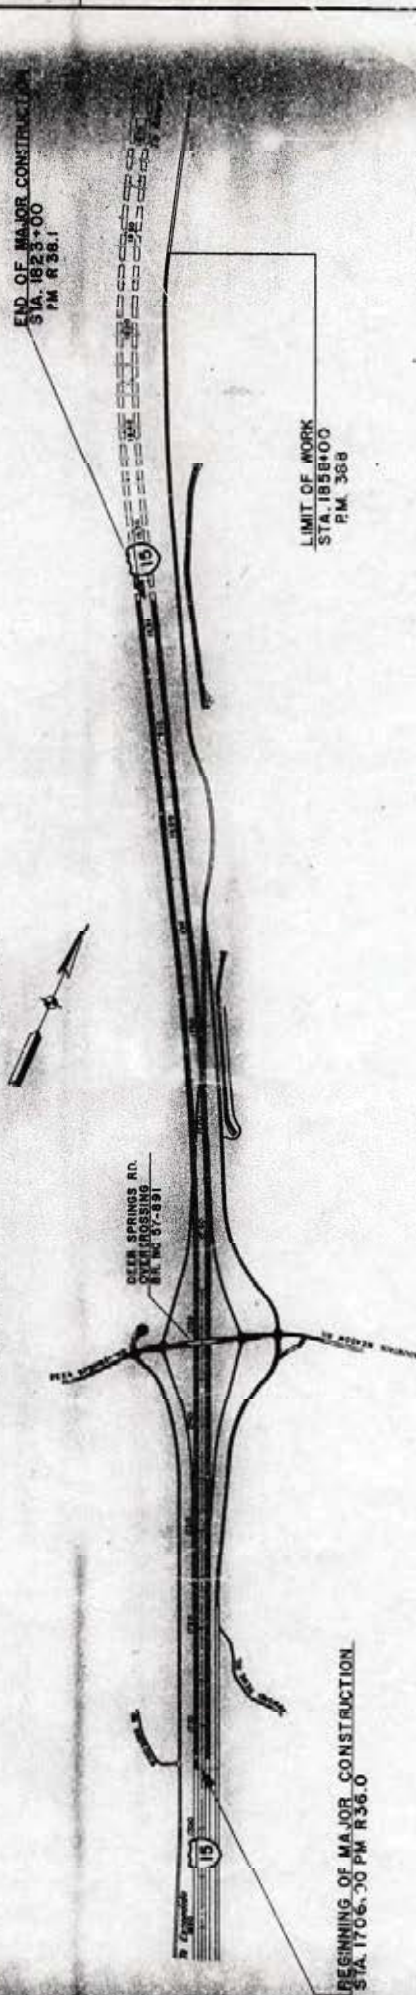

Legend
GRADING & EMBANKMENT
FUTURE CONSTRUCTION
TEMPORARY CONNECTION
EXISTING


"AS BUILT"
CONTRACT 11-09004-4
YEAR COMPLETED 11-3-79

SCALE IN FEET
0 100 200 300 400 500

Length of Major Construction = 2.1 miles

AS BUILT PLANS
Contract No. 11-09004-4
Date Completed 11-3-79
Document No. 11-09004-4



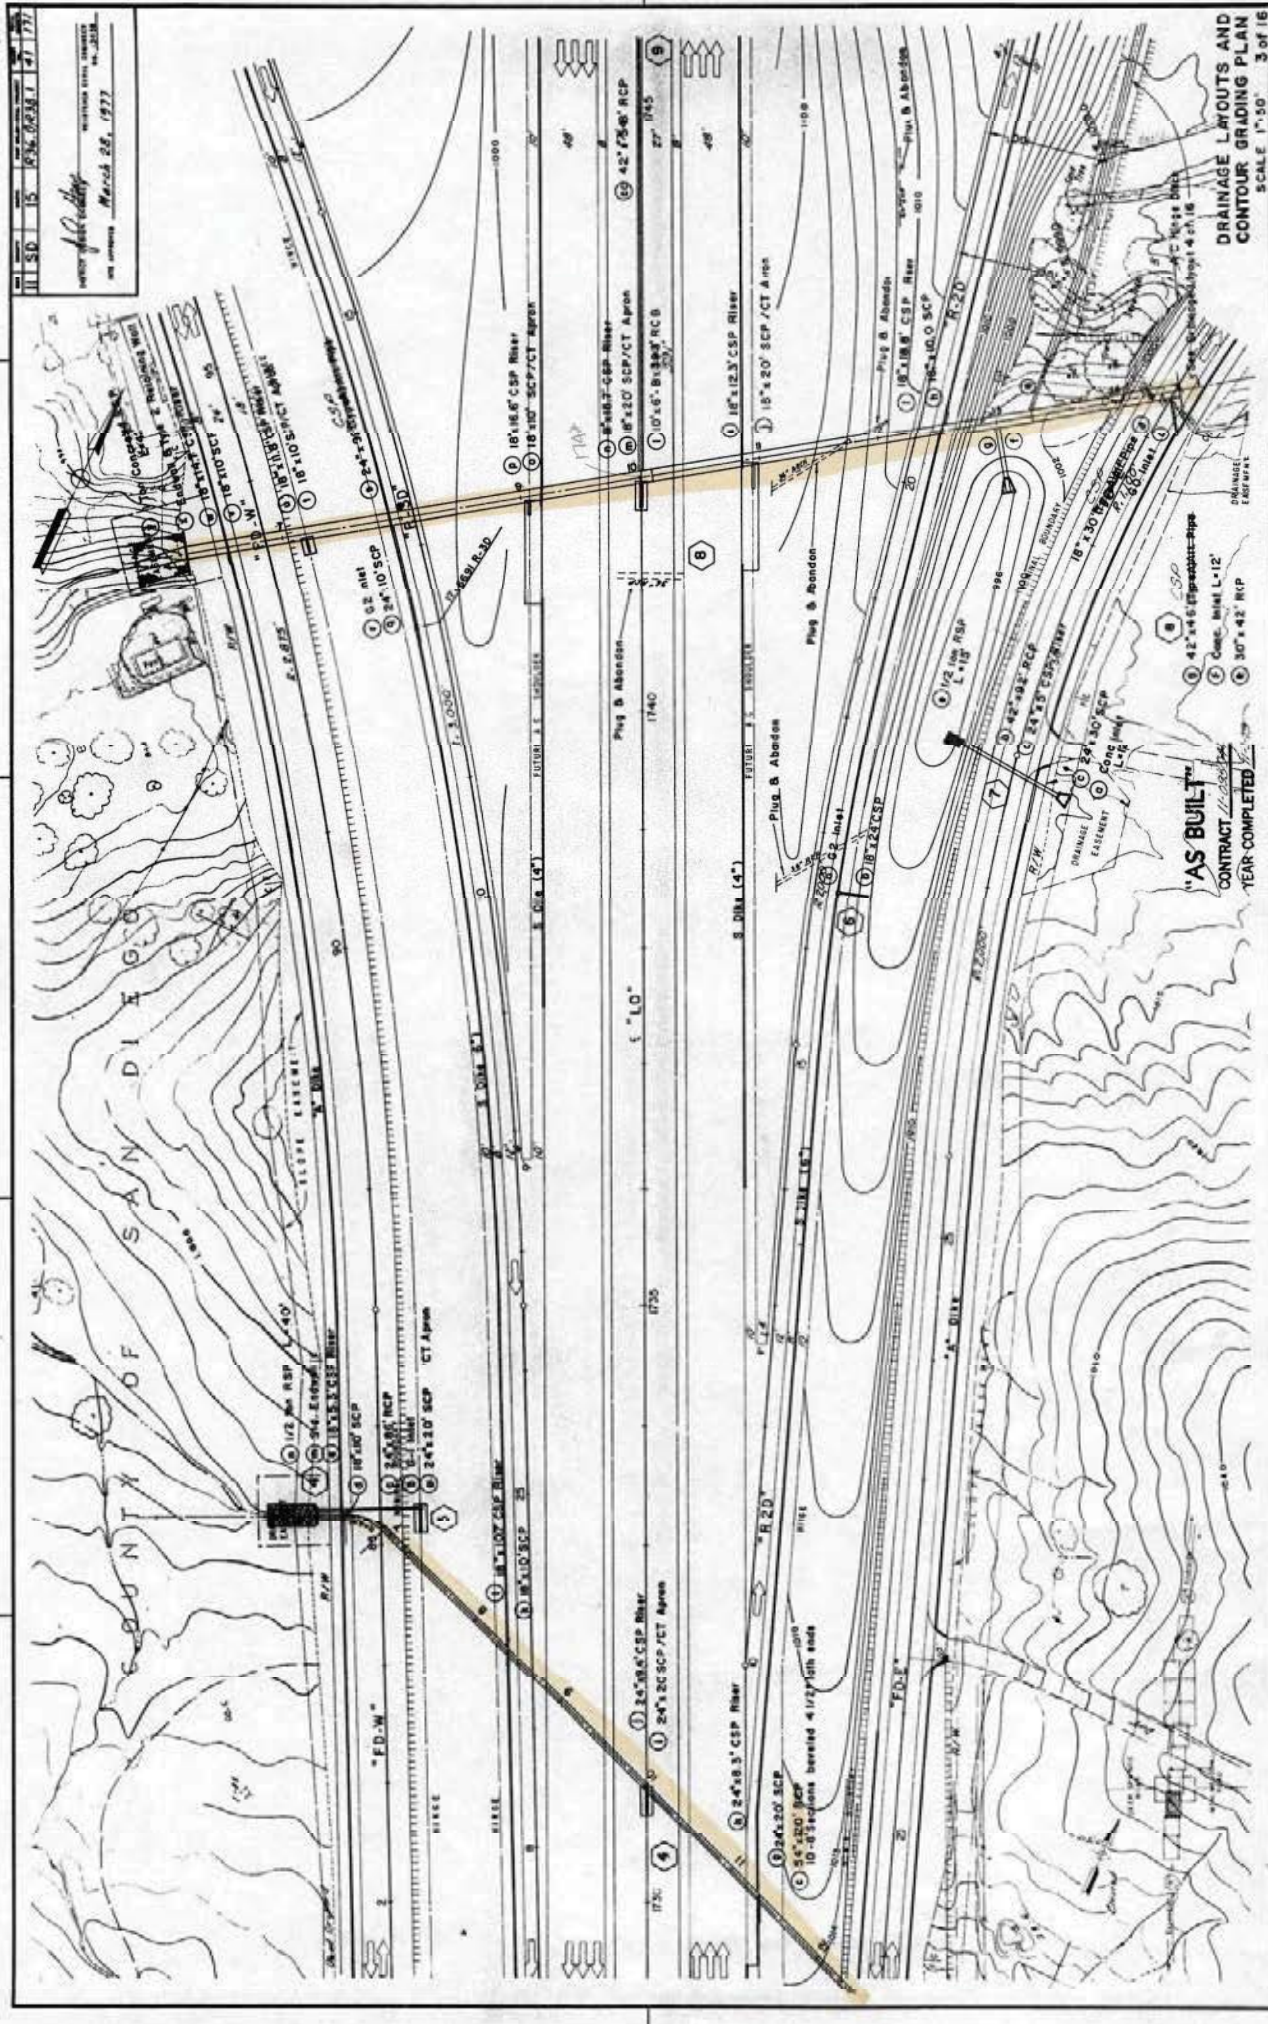


1"=100'

AS BUILT PLANS
Contract No. 11-08-0044
Date Completed 11-25-76
Document No. 4000-6713

From Deer Springs Rd.
to 0.5




11 53 6 1250 07/13/57 42 197
 10 May
 1977
 March 28, 1977

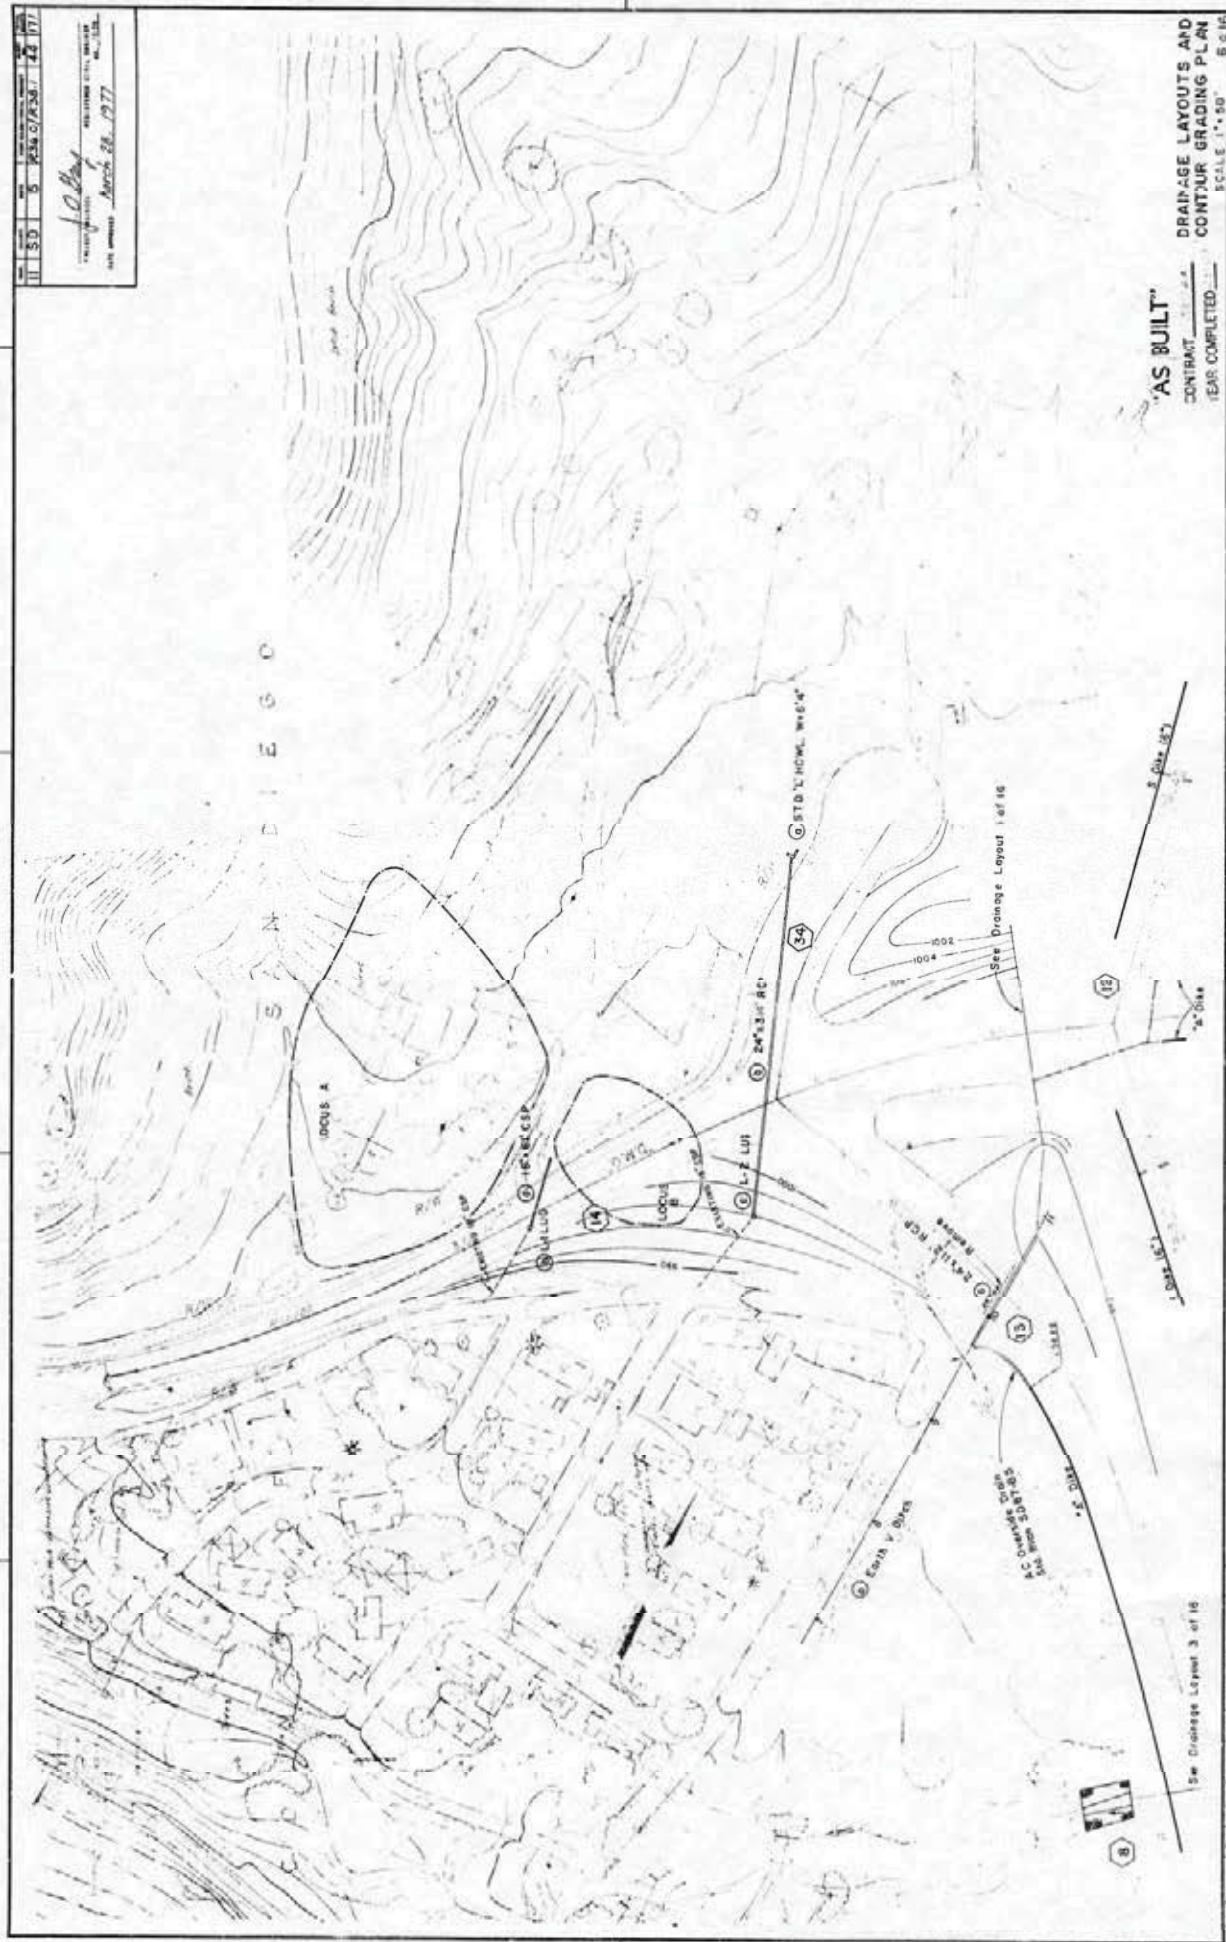


"AS BUILT"
 DRAINAGE LAYOUTS AND
 CONTOUR GRADING PLAN
 YEAR COMPLETED 1977
 SCALE 1"=50' B.S. 105

AS BUILT PLANS
 Contract No. 11-090044
 Date Completed 11-2-79
 Document No. 6115

 08-17-79
 J. B. Dinkley
 J. B. Dinkley
 J. B. Dinkley



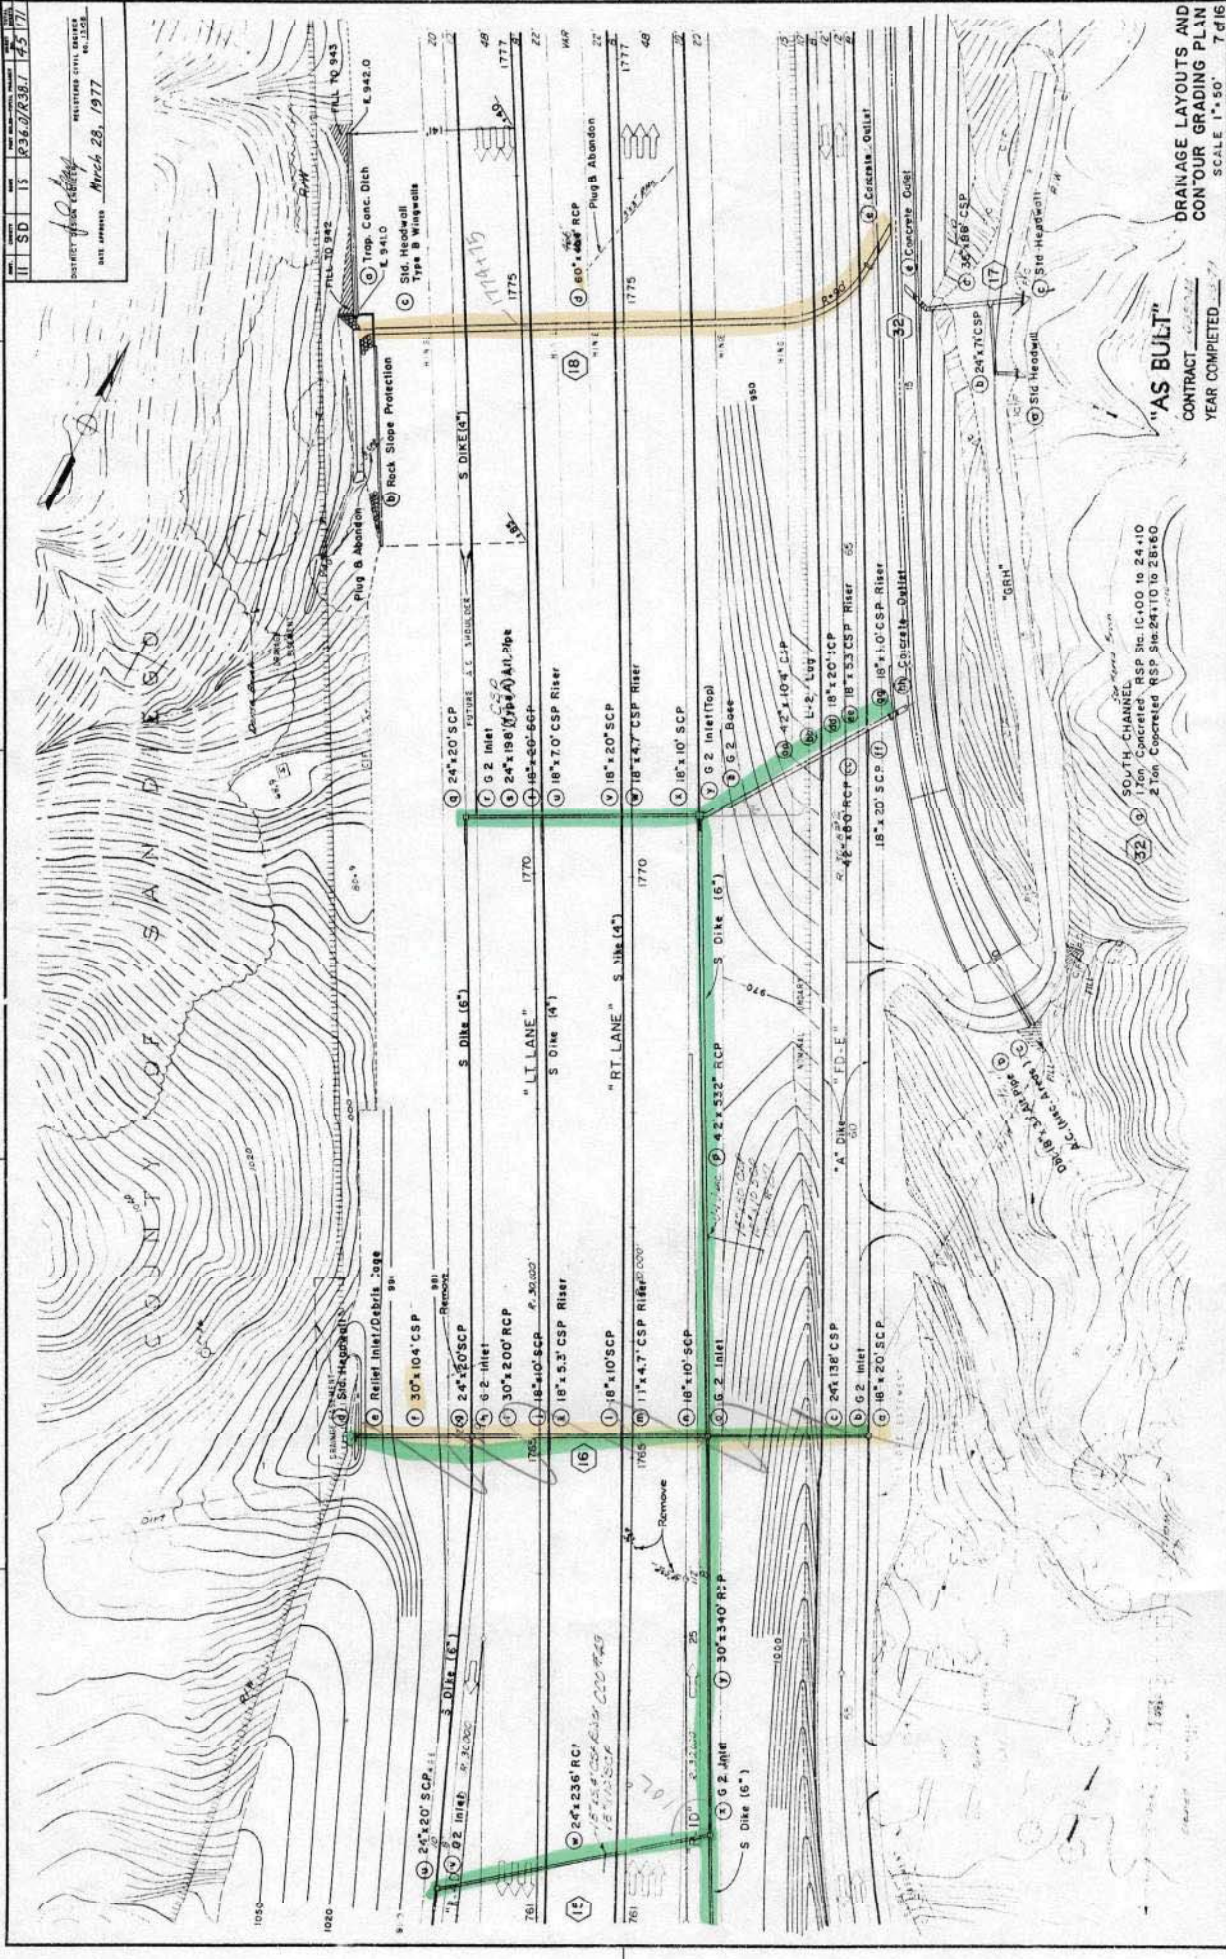


DRAINAGE LAYOUTS AND
CONTOUR GRADING PLAN
SCALE 1"=50' 7d16

"AS BUILT"
CONTRACT 6775
YEAR COMPLETED 79


AS BUILT PLANS
Contract No. 11-095044
Date Completed 11-2-79
Document No. 6775

1. I HEREBY CERTIFY THAT THIS IS A TRUE AND ACCURATE COPY OF THE ABOVE EXHIBIT TAKEN FROM THE ORIGINAL RECORDS OF THE PROJECT AND THAT THE SAME IS IN ACCORDANCE WITH THE REQUIREMENTS OF THE CALIFORNIA DEPARTMENT OF TRANSPORTATION.

 8/13/80 Joseph M. Galt Engineer in Charge



DATE APPROVED March 28, 1977
BY John P. [Signature]
SANTA CRUZ COUNTY ENGINEER
NO. 12333

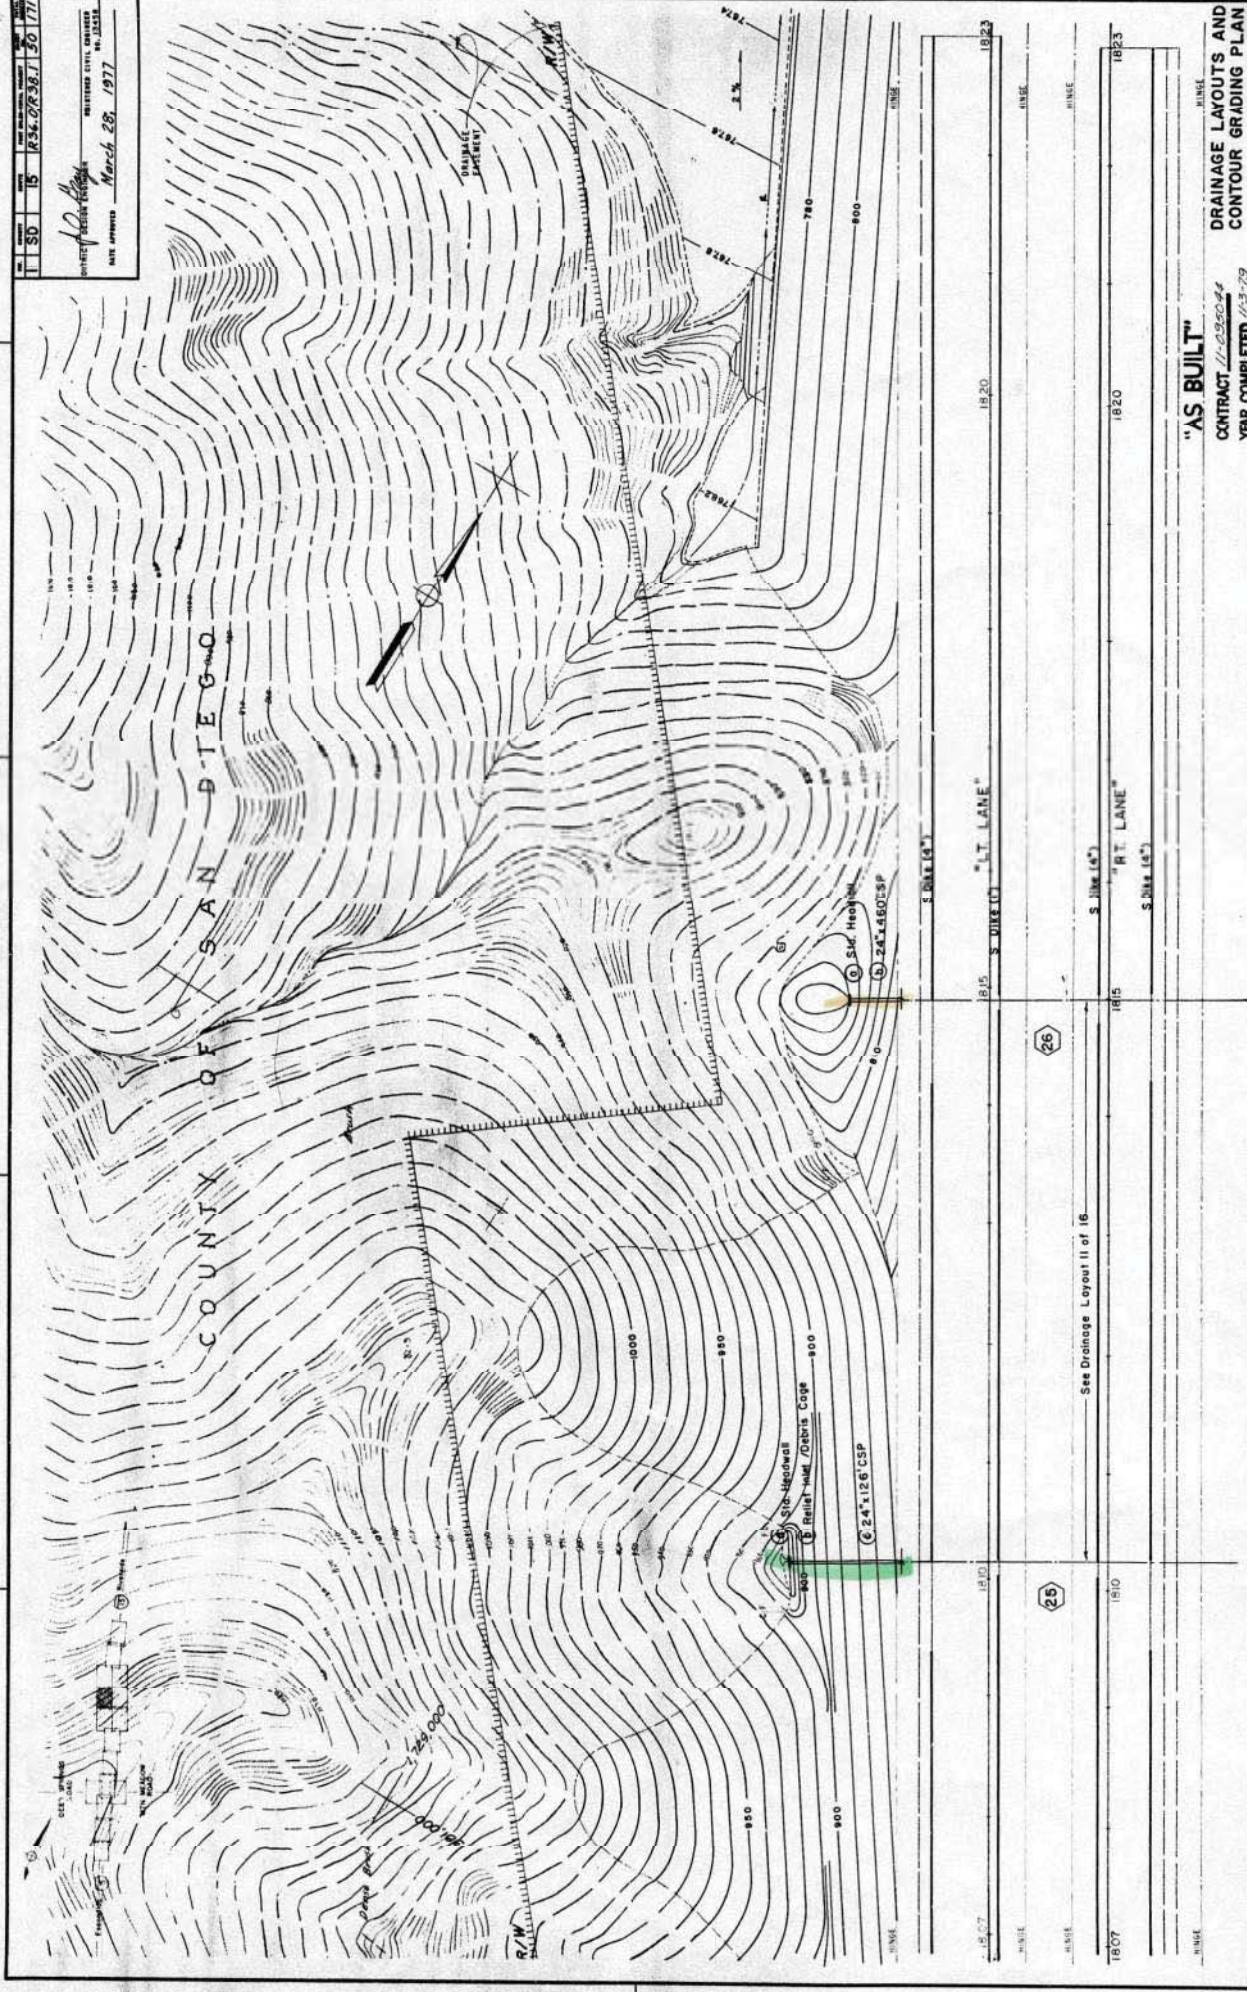


AS BUILT PLANS
Contract No. 11-090044
Date Completed 11-3-79
Document No. 6375

AS BUILT PLANS
Contract No. 11-090044
Date Completed 11-3-79
Document No. 6375



13

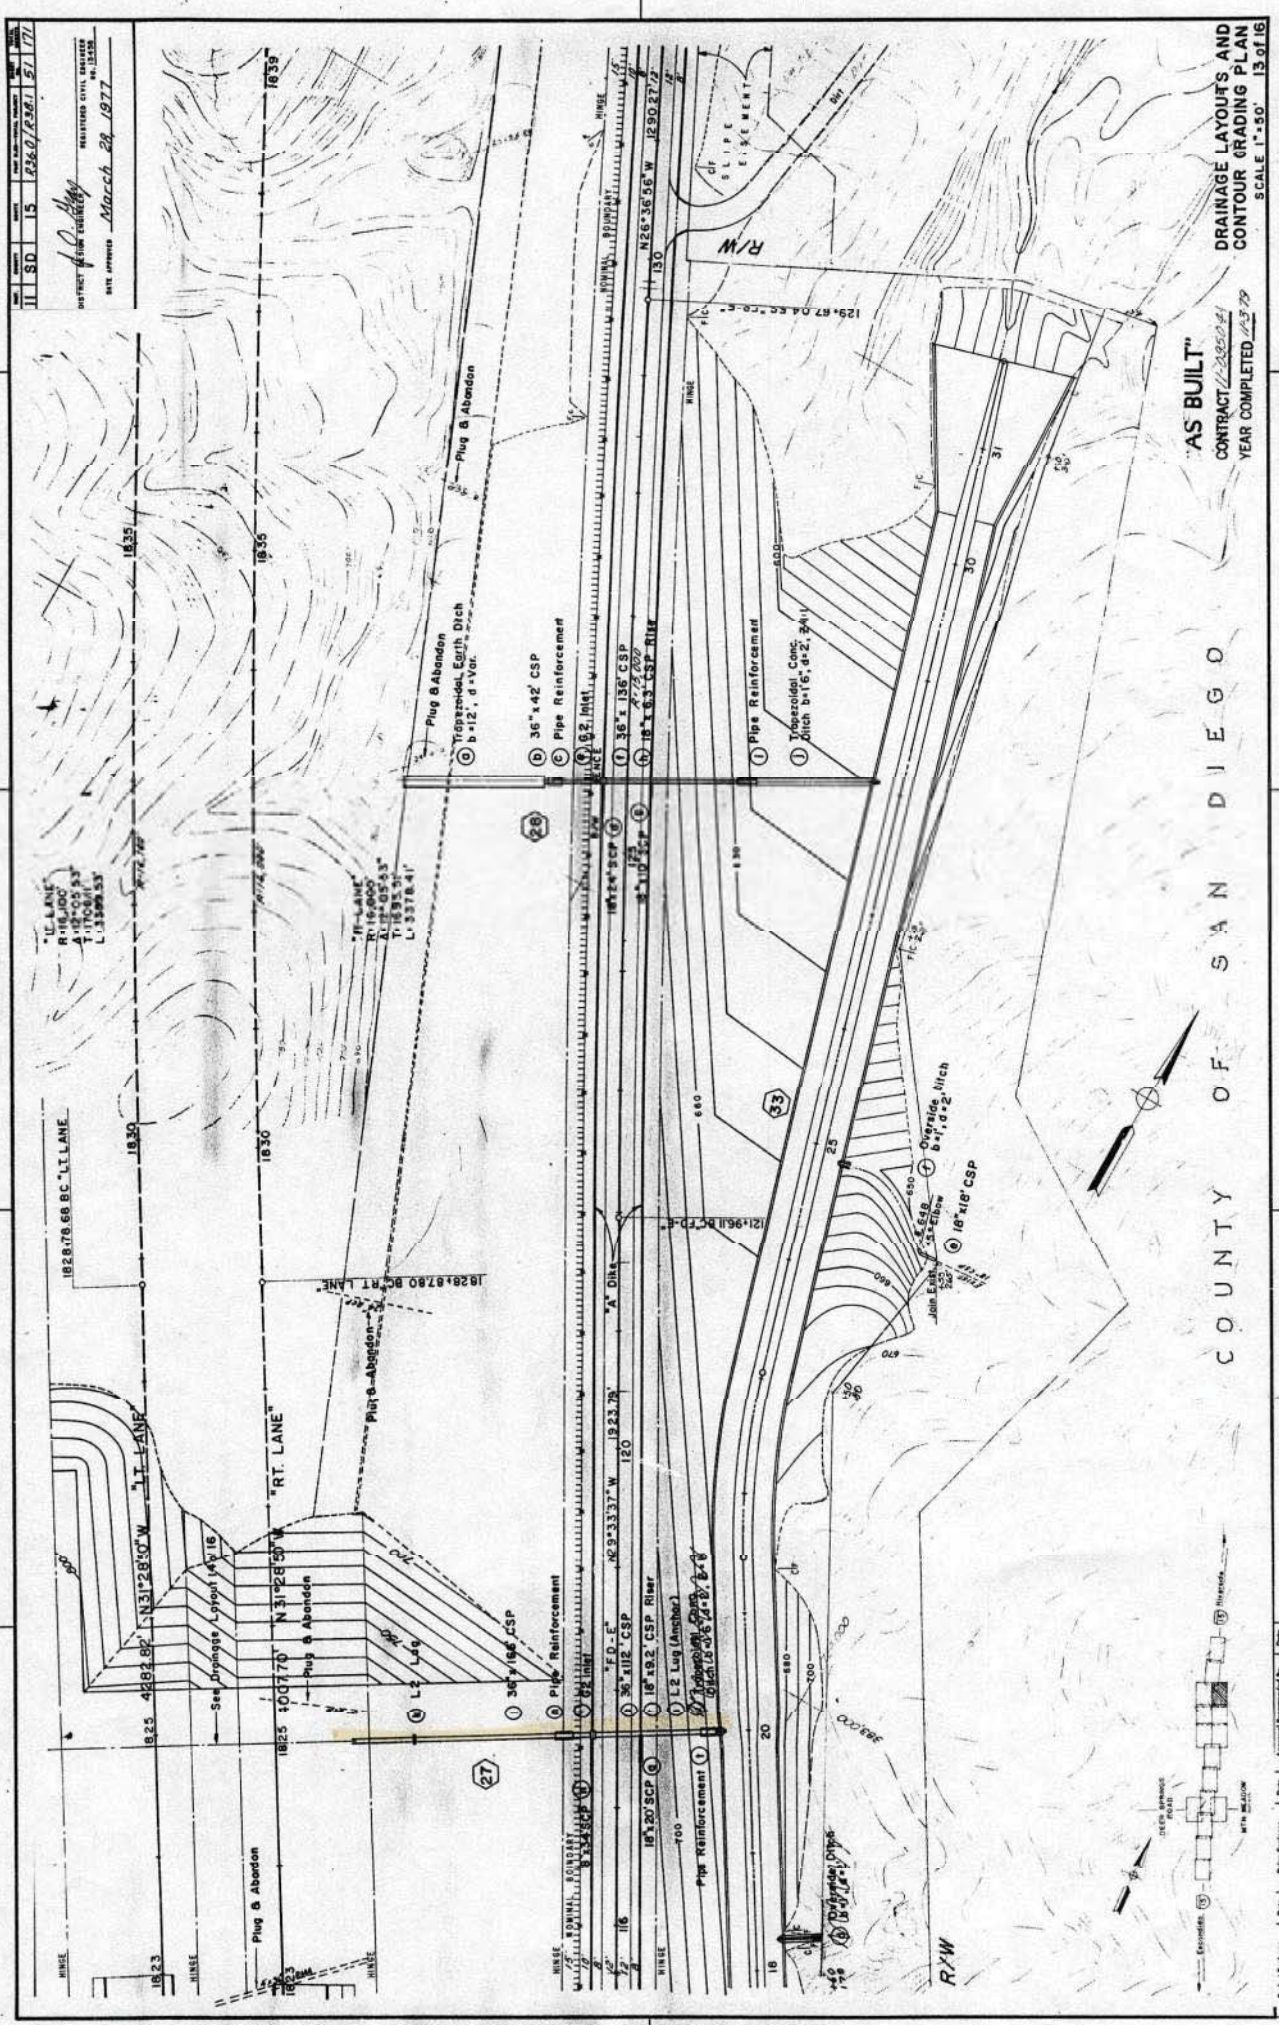

AS BUILT PLANS
Contract No. 11-090044
Date Completed 11-3-79
Document No. 11-090044-1

1. THESE PLANS AND SPECIFICATIONS ARE THE PROPERTY OF THE COUNTY OF SAN DIEGO. THEY ARE TO BE USED ONLY FOR THE PROJECT AND SITE SPECIFICALLY IDENTIFIED HEREON. ANY OTHER USE WITHOUT THE WRITTEN PERMISSION OF THE COUNTY ENGINEER IS PROHIBITED.



