



COUNTY OF SAN DIEGO TRACT 5572-RPL1
PHOTOMETRIC DESIGN CONCEPT
LILAC HILLS RANCH

VICINITY MAP

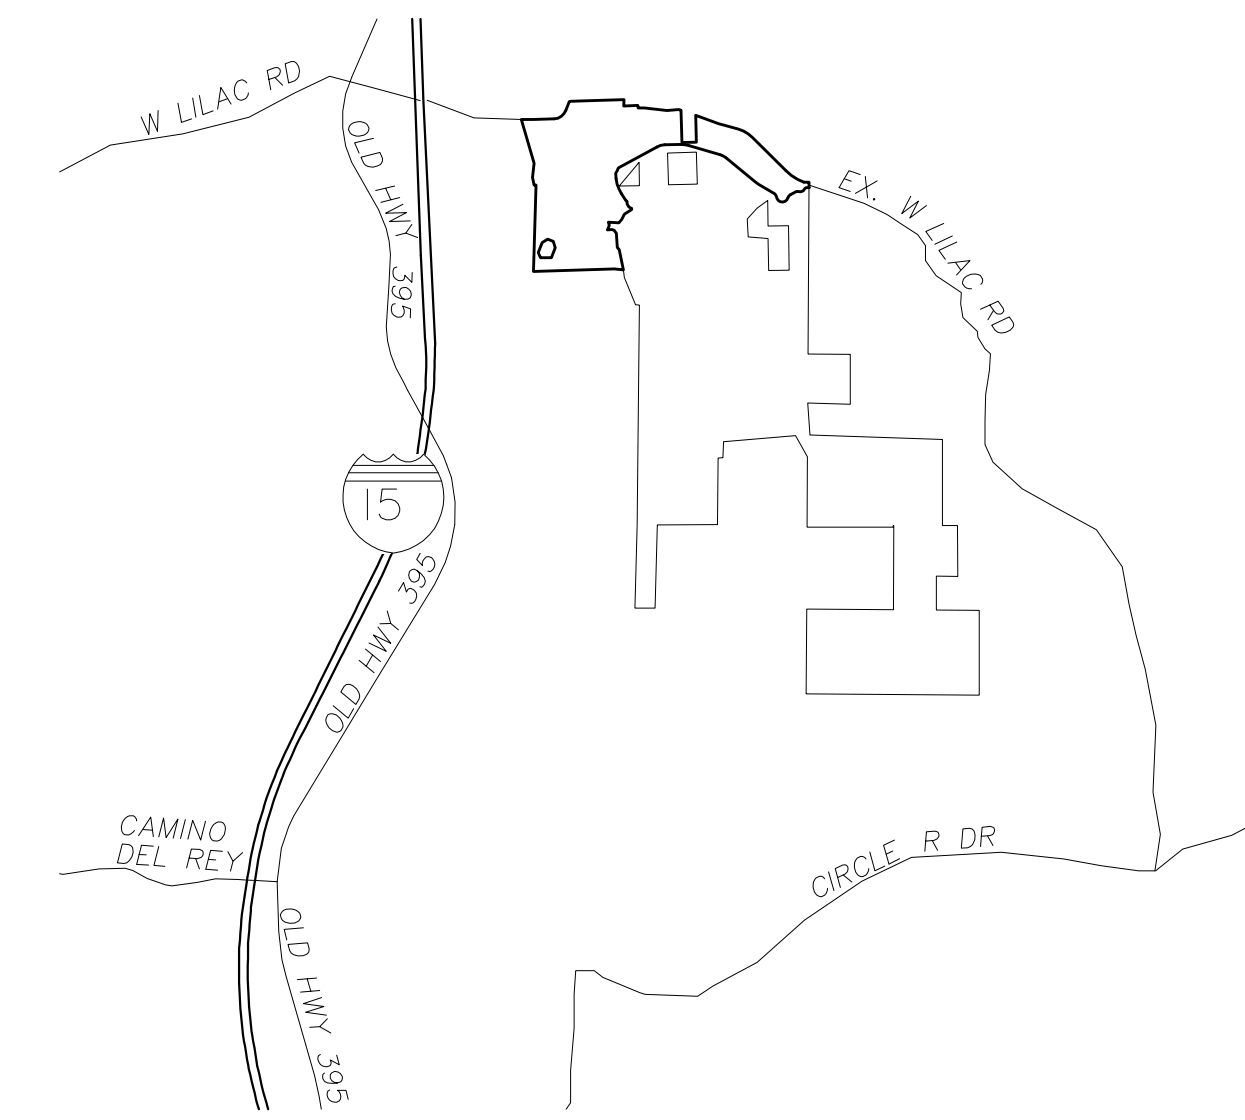

PHOTOMETRIC CONCEPT SHEET INDEX

SHEETS	PLANS
T-1	PHOTOMETRIC CONCEPTUAL TITLE SHEET
1-2	PARTIAL STREET LIGHTING
3	LIGHT FIXTURE SCHEDULE
4-5	PARK LIGHTING PLANS
6-14	PARTIAL PHOTOMETRICS

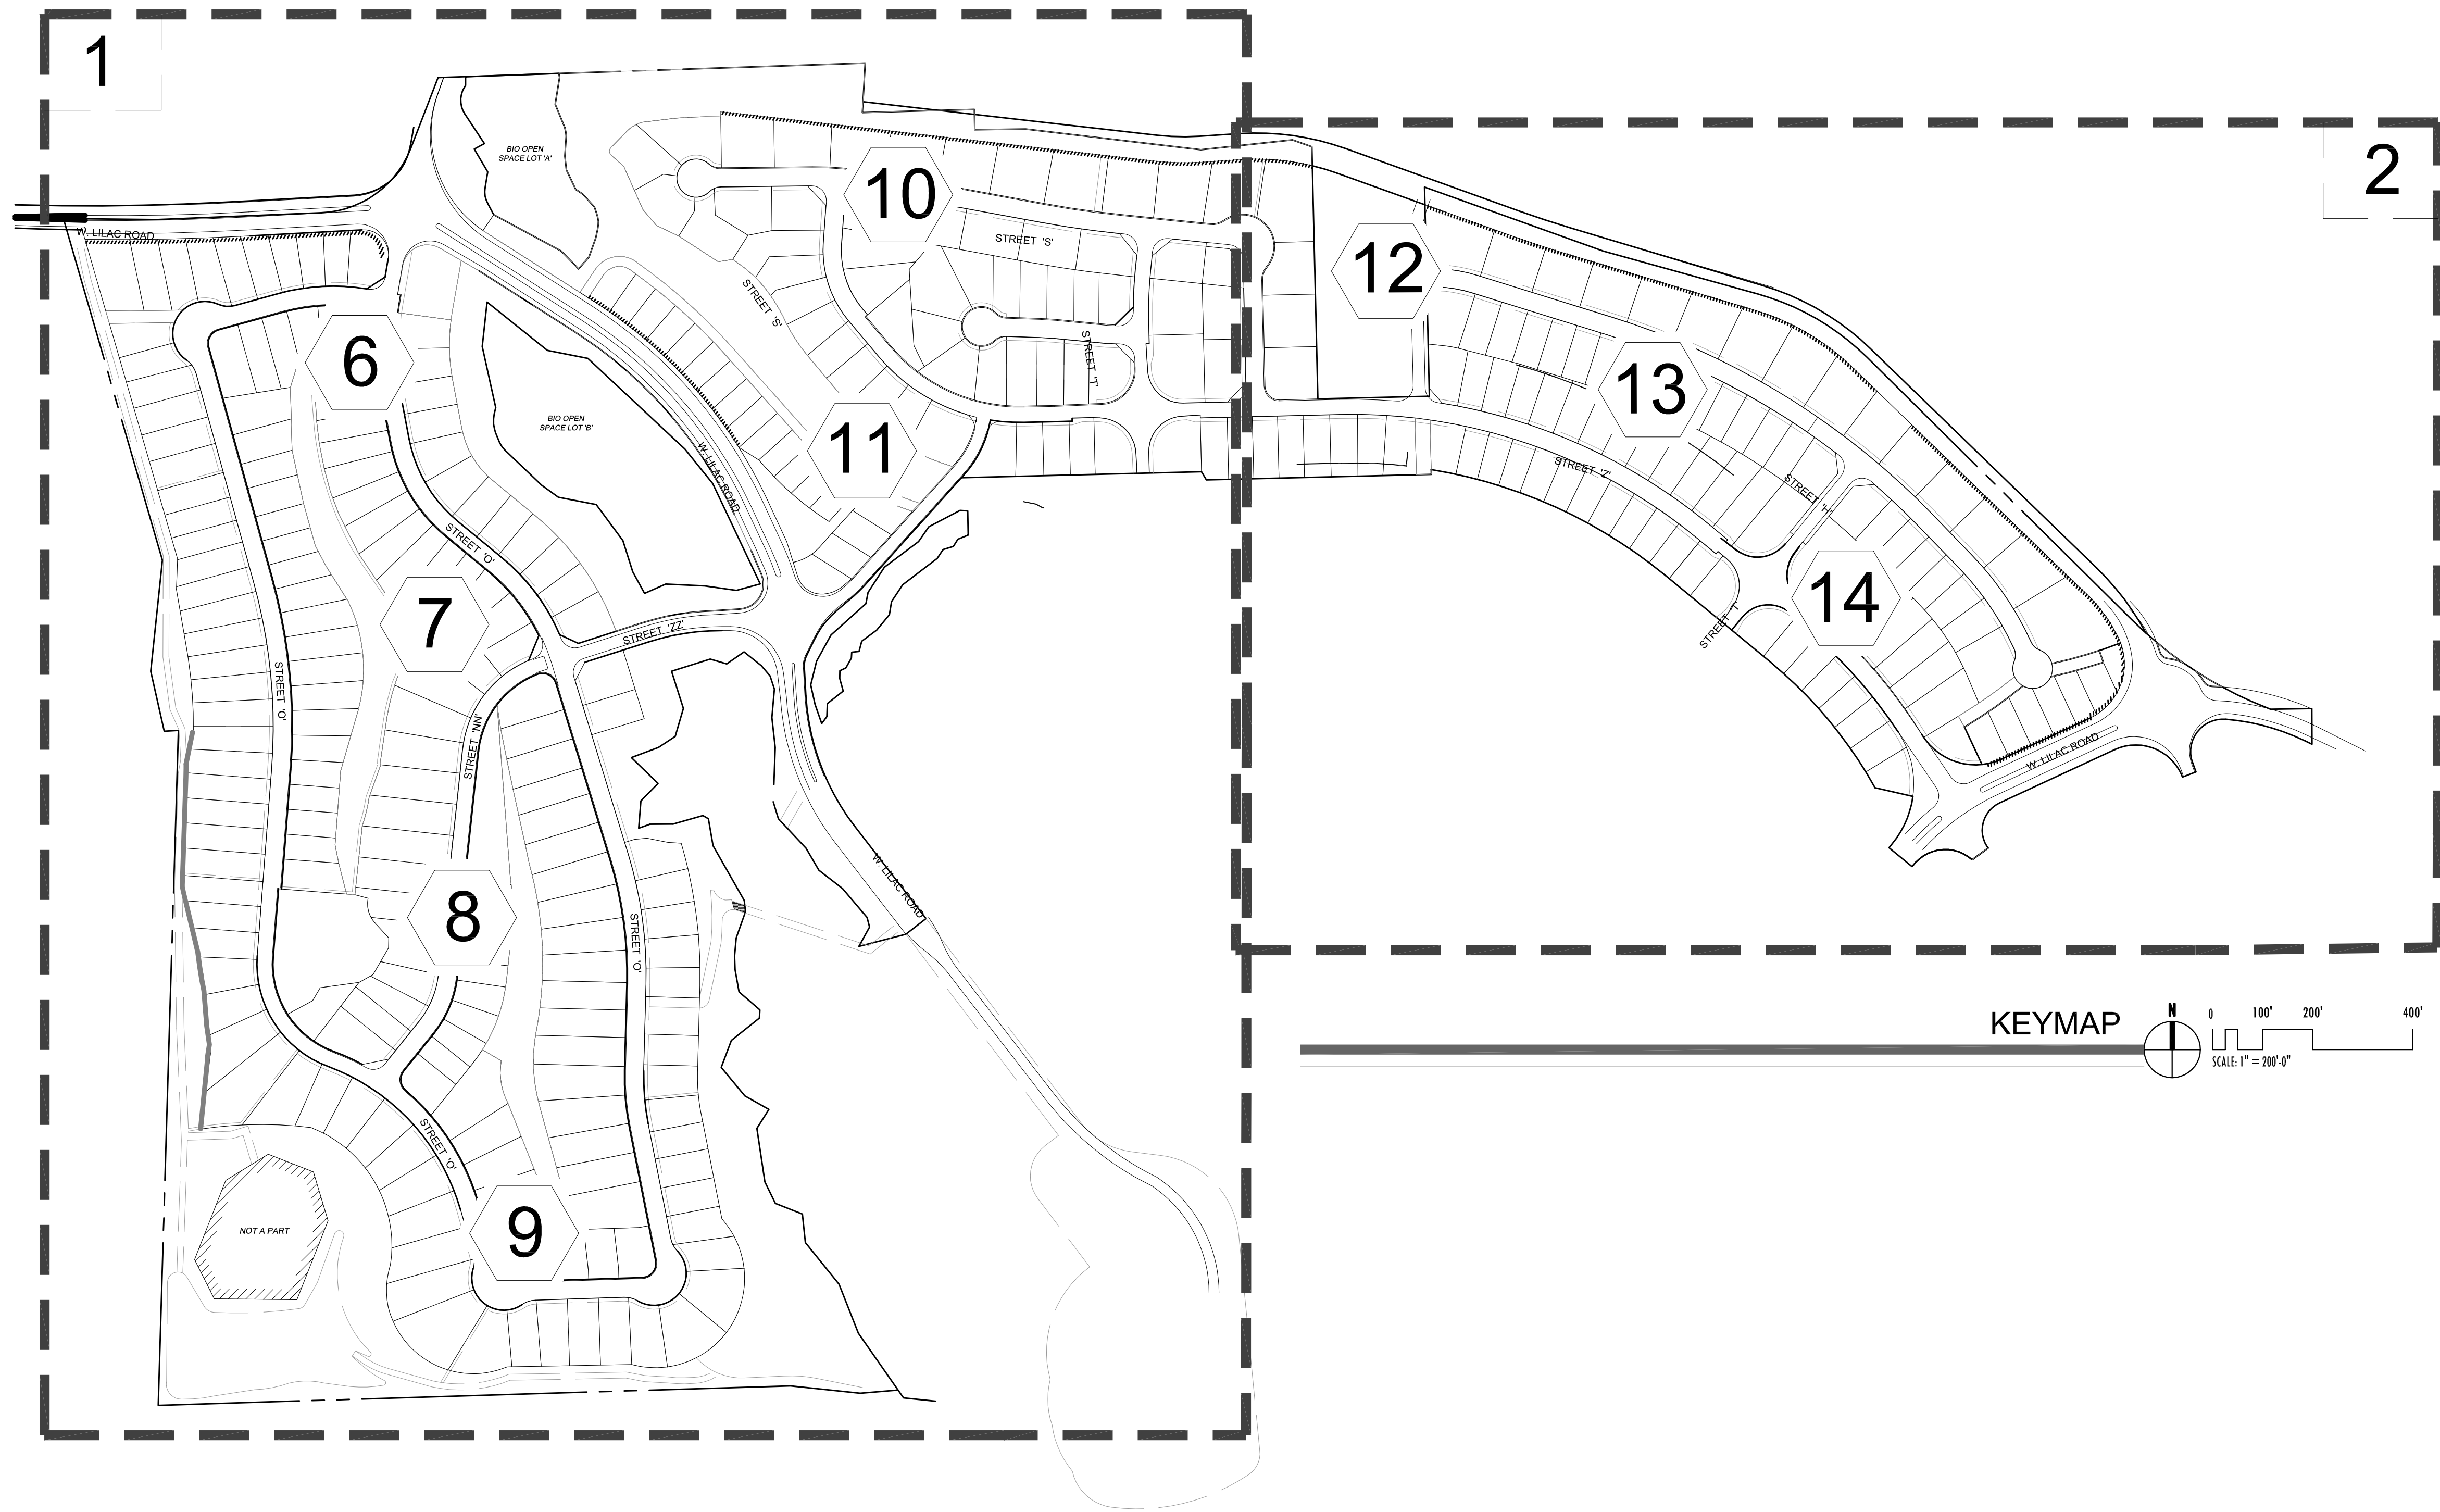

TURPIN & RATTAN
ENGINEERING, INC.
CONSULTING ENGINEERS
4719 PALM AVENUE
LA MESA, CA 91941-5221
619 / 466 / 6224 FAX 666 / 6233
E-MAIL: ENGINEER@TRERO.COM
TREI # 11348.00
E-FILED 05/21/12 5:03PM
S-1111348-00CAGADPDU/11348.00_SHT 1-2 STREET LIGHTING.dwg

Wimmer
Yamada
and
Caughey

Landscape Architecture | Environmental Planning
3067 Fifth Avenue, San Diego, California 92103-1840
T 619-232-4004 F 619-232-0640 www.wyac.com

PREPARED BY:

LANDMARK
Civil & Mechanical Engineering
Planning Engineering Surveying
8505 Camarillo Avenue, Suite 200
San Diego, CA 92121 (619) 581-6070

COUNTY OF SAN DIEGO TM 5572-RPL1

LILAC HILL RANCH

PHOTOMETRIC TITLE SHEET

T-1




- LEGEND**
- SINGLE ARM POLE/FIXTURE TYPE 'A' AT ±80'-0" ON CENTER.
 - DOUBLE ARM POLE/FIXTURES TYPE 'A' AT ±120'-0" ON CENTER.
 - ⊠ BOLLARD TYPE 'B' AT ±30'-0" ON CENTER.

- KEYNOTES**
- 1 PROVIDE WP JUNCTION BOX SET FLUSH WITH FINISHED GRADE AND 20 AMP 480 VOLT POWER SOURCE FOR PRIMARY ENTRY MONUMENT (TYPICAL OF 2 LOCATIONS)


PARTIAL PHASE 1 STREET LIGHTING
SCALE: 1"=100'-0"



TURPIN & RATTAN
ENGINEERING, INC.
CONSULTING ENGINEERS
4719 PALM AVENUE
LA MEHA, CA 91941-5221
P: 619 / 450-1624 FAX: 619 / 693-3333
E-MAIL: ENGINEER@TRISB.COM
TREI # 11348.01

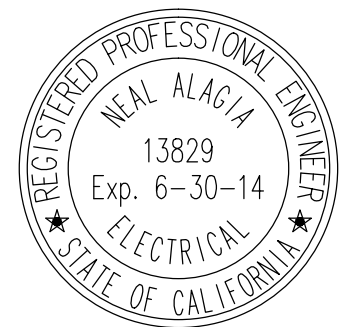

**Wimmer
Yamada
and
Caughy**

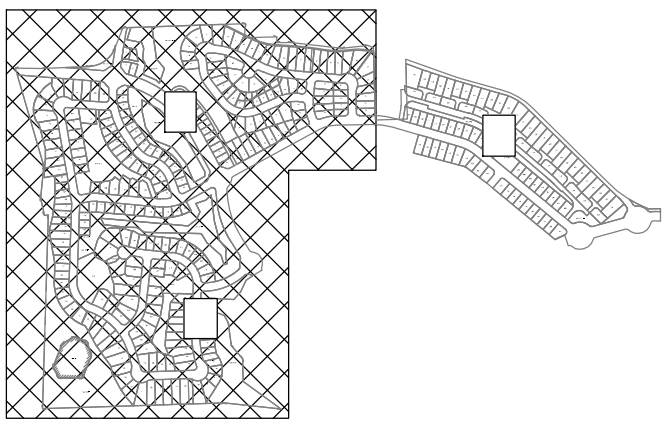


COUNTY OF SAN DIEGO TM 5572-RPL1
IMPLEMENTING TM LANDSCAPE CONCEPT PLAN FOR:

LILAC HILL RANCH

PARTIAL PHASE 1 STREET LIGHTING

MATCH LINE. FOR CONTINUATION SEE SHEET 1

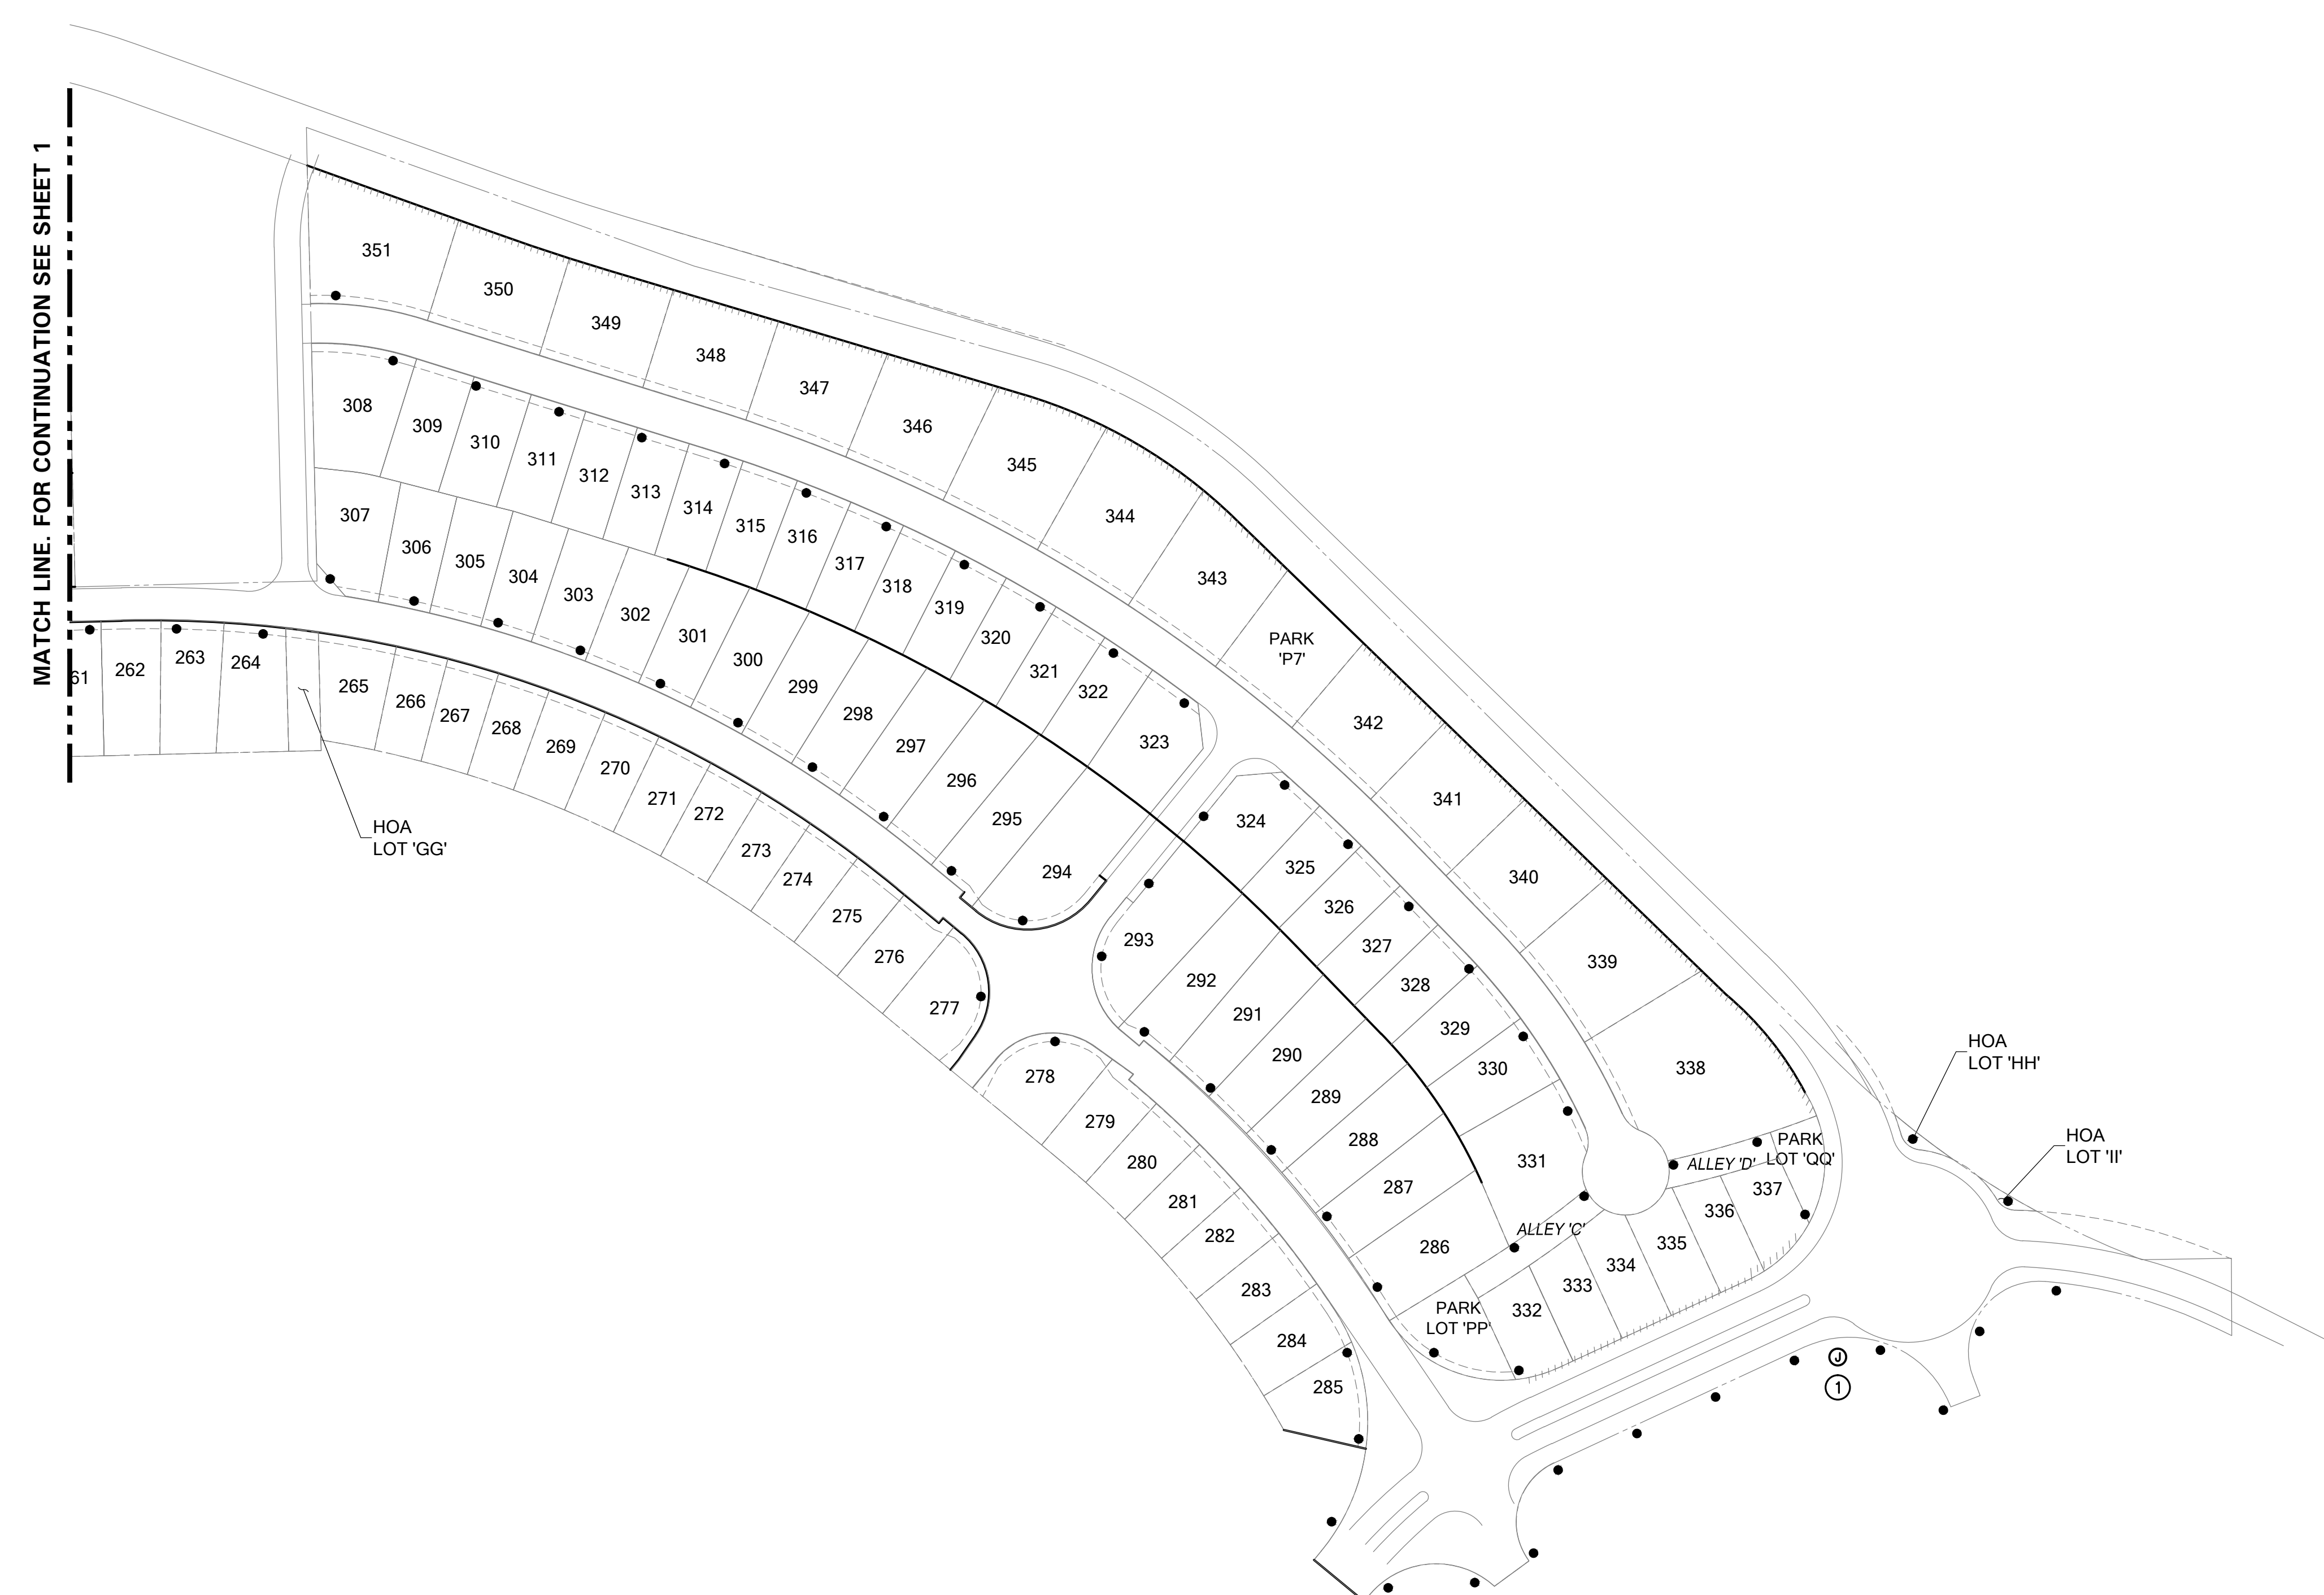

LEGEND



- SINGLE ARM POLE/FIXTURE TYPE 'A' AT ±80'-0" ON CENTER.
- DOUBLE ARM POLE/FIXTURES TYPE 'A' AT ±120'-0" ON CENTER.
- ⊠ BOLLARD TYPE 'B' AT ±30'-0" ON CENTER.

KEYNOTES

- ① PROVIDE WP JUNCTION BOX SET FLUSH WITH FINISHED GRADE AND 20 AMP 480 VOLT POWER SOURCE FOR PRIMARY ENTRY MONUMENT (TYPICAL OF 2 LOCATIONS)

PARTIAL PHASE 1 STREET LIGHTING

SCALE: 1"=100'-0"

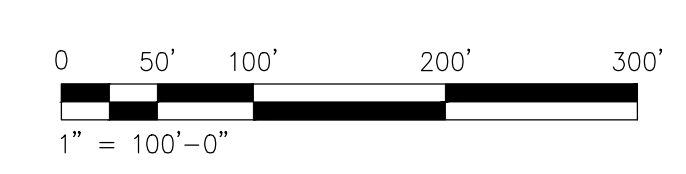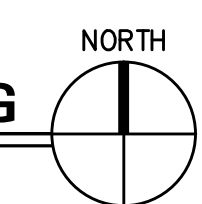

TURPIN & RATTAN
ENGINEERING, INC.
CONSULTING ENGINEERS
4719 PALM AVENUE
LA MESA, CA 91941-5221
619 / 450-1624 FAX 408 / 6233
E-MAIL: ENGINEER@TREISO.COM
TREI # 11348.01

Wimmer
Yamada
and
Caughey

LANDMARK
ENGINEERING
CONSULTING ENGINEERS
619 / 450-1624 FAX 408 / 6233
E-MAIL: ENGINEER@TREISO.COM

COUNTY OF SAN DIEGO TM 5572- RPL1
IMPLEMENTING TM LANDSCAPE CONCEPT PLAN FOR:
LILAC HILL RANCH
PARTIAL PHASE 1 STREET LIGHTING
SHEET NO. 2 OF 14

ORDERING INFORMATION

PARK RIDGE 1910LED / 5RLM

POST & ARM FIXTURES EXAMPLE

No. of Arms	Arm Mounted Fixture	Center Post Top Feature (PT)	Post	Post Cap	Light Source	Driver	Options	Finish
2	1910LED/A/5RLM18/RPM		3900RT4/12AG		4A1R45T5	ML		BKT
B	A, B	A	(See Post Spec Sheet)	C	C1	D, E, G	F	

A. Fixture

 1910LED/ 5RLM18 Polycarbonate or Acrylic	 1910LED/ 5RLM24 Polycarbonate or Acrylic	 1910LED/ 5RLM32 Polycarbonate or Acrylic	 1910LED/A/ 5RLM18/FL Acrylic	 1910LED/A/ 5RLM24/FL Acrylic
--	--	--	---	---

B. Mounting Styles

ARMS - POST MOUNT (PM) WALL BRACKET (WB)

More arms available, see spec sheet.

C. Light Sources

• 4A1R60T5 32W, 6000K Type V Optics	• 4A1R35T5 32W, 3500K Type V Optics	• 4A1R45T5 32W, 4500K Type V Optics	• 1RND60T5 32W, 6000K Type V Optics	• 1RND35T5 32W, 3500K Type V Optics
• 4A1R65T3 32W, 6500K Type III Optics	• 4A1R45T3 32W, 4500K Type III Optics	• 4A1R35T3 32W, 3500K Type III Optics	• 1RND65T3 32W, 6500K Type III Optics	• 1RND45T3 32W, 4500K Type III Optics

C1. Drivers

ML 120-277
MH 347-480
MDL Dimming 120-277
MIDH Dimming 347-480

D. Optional Photocell

• PEC1 Photocell-Bimetal 120 Volt	• PEC1-E Photocell-Electronic 120 Volt
• PEC2 Photocell-Bimetal 208-277 Volt	• PEC2-E Photocell-Electronic 208-277 Volt

E. Feature Fusing

• FHD Dual Fuse and Holder - 120, 208, 240, 277, 480 Volt

G. Optional Hangerstay (HS-V)

F. Finish

STANDARD	
BKT Black Textured	ABZ Architectural Medium Bronze
BL Black	SI Swedish Iron
VG Venis Green	DBT Dark Bronze Textured
PGT Park Green Textured	DB Dark Bronze
PG Park Green	OWST One World Gray Textured
ABZT Architectural Medium Bronze Textured	OWG Old World Gray

DUSTM

WH1 White Textured	CD Cedar
WH1 White	AT Red
CU Copper Venis	DI Oil Iron
WBK Weathered Black	TT Two Tones
WBK Weathered Brown	CM Custom Match


NOTE: See website for complete specifications and IES files.

SYNTRONICS

47

FIXTURE TYPE 'A'

NO SCALE

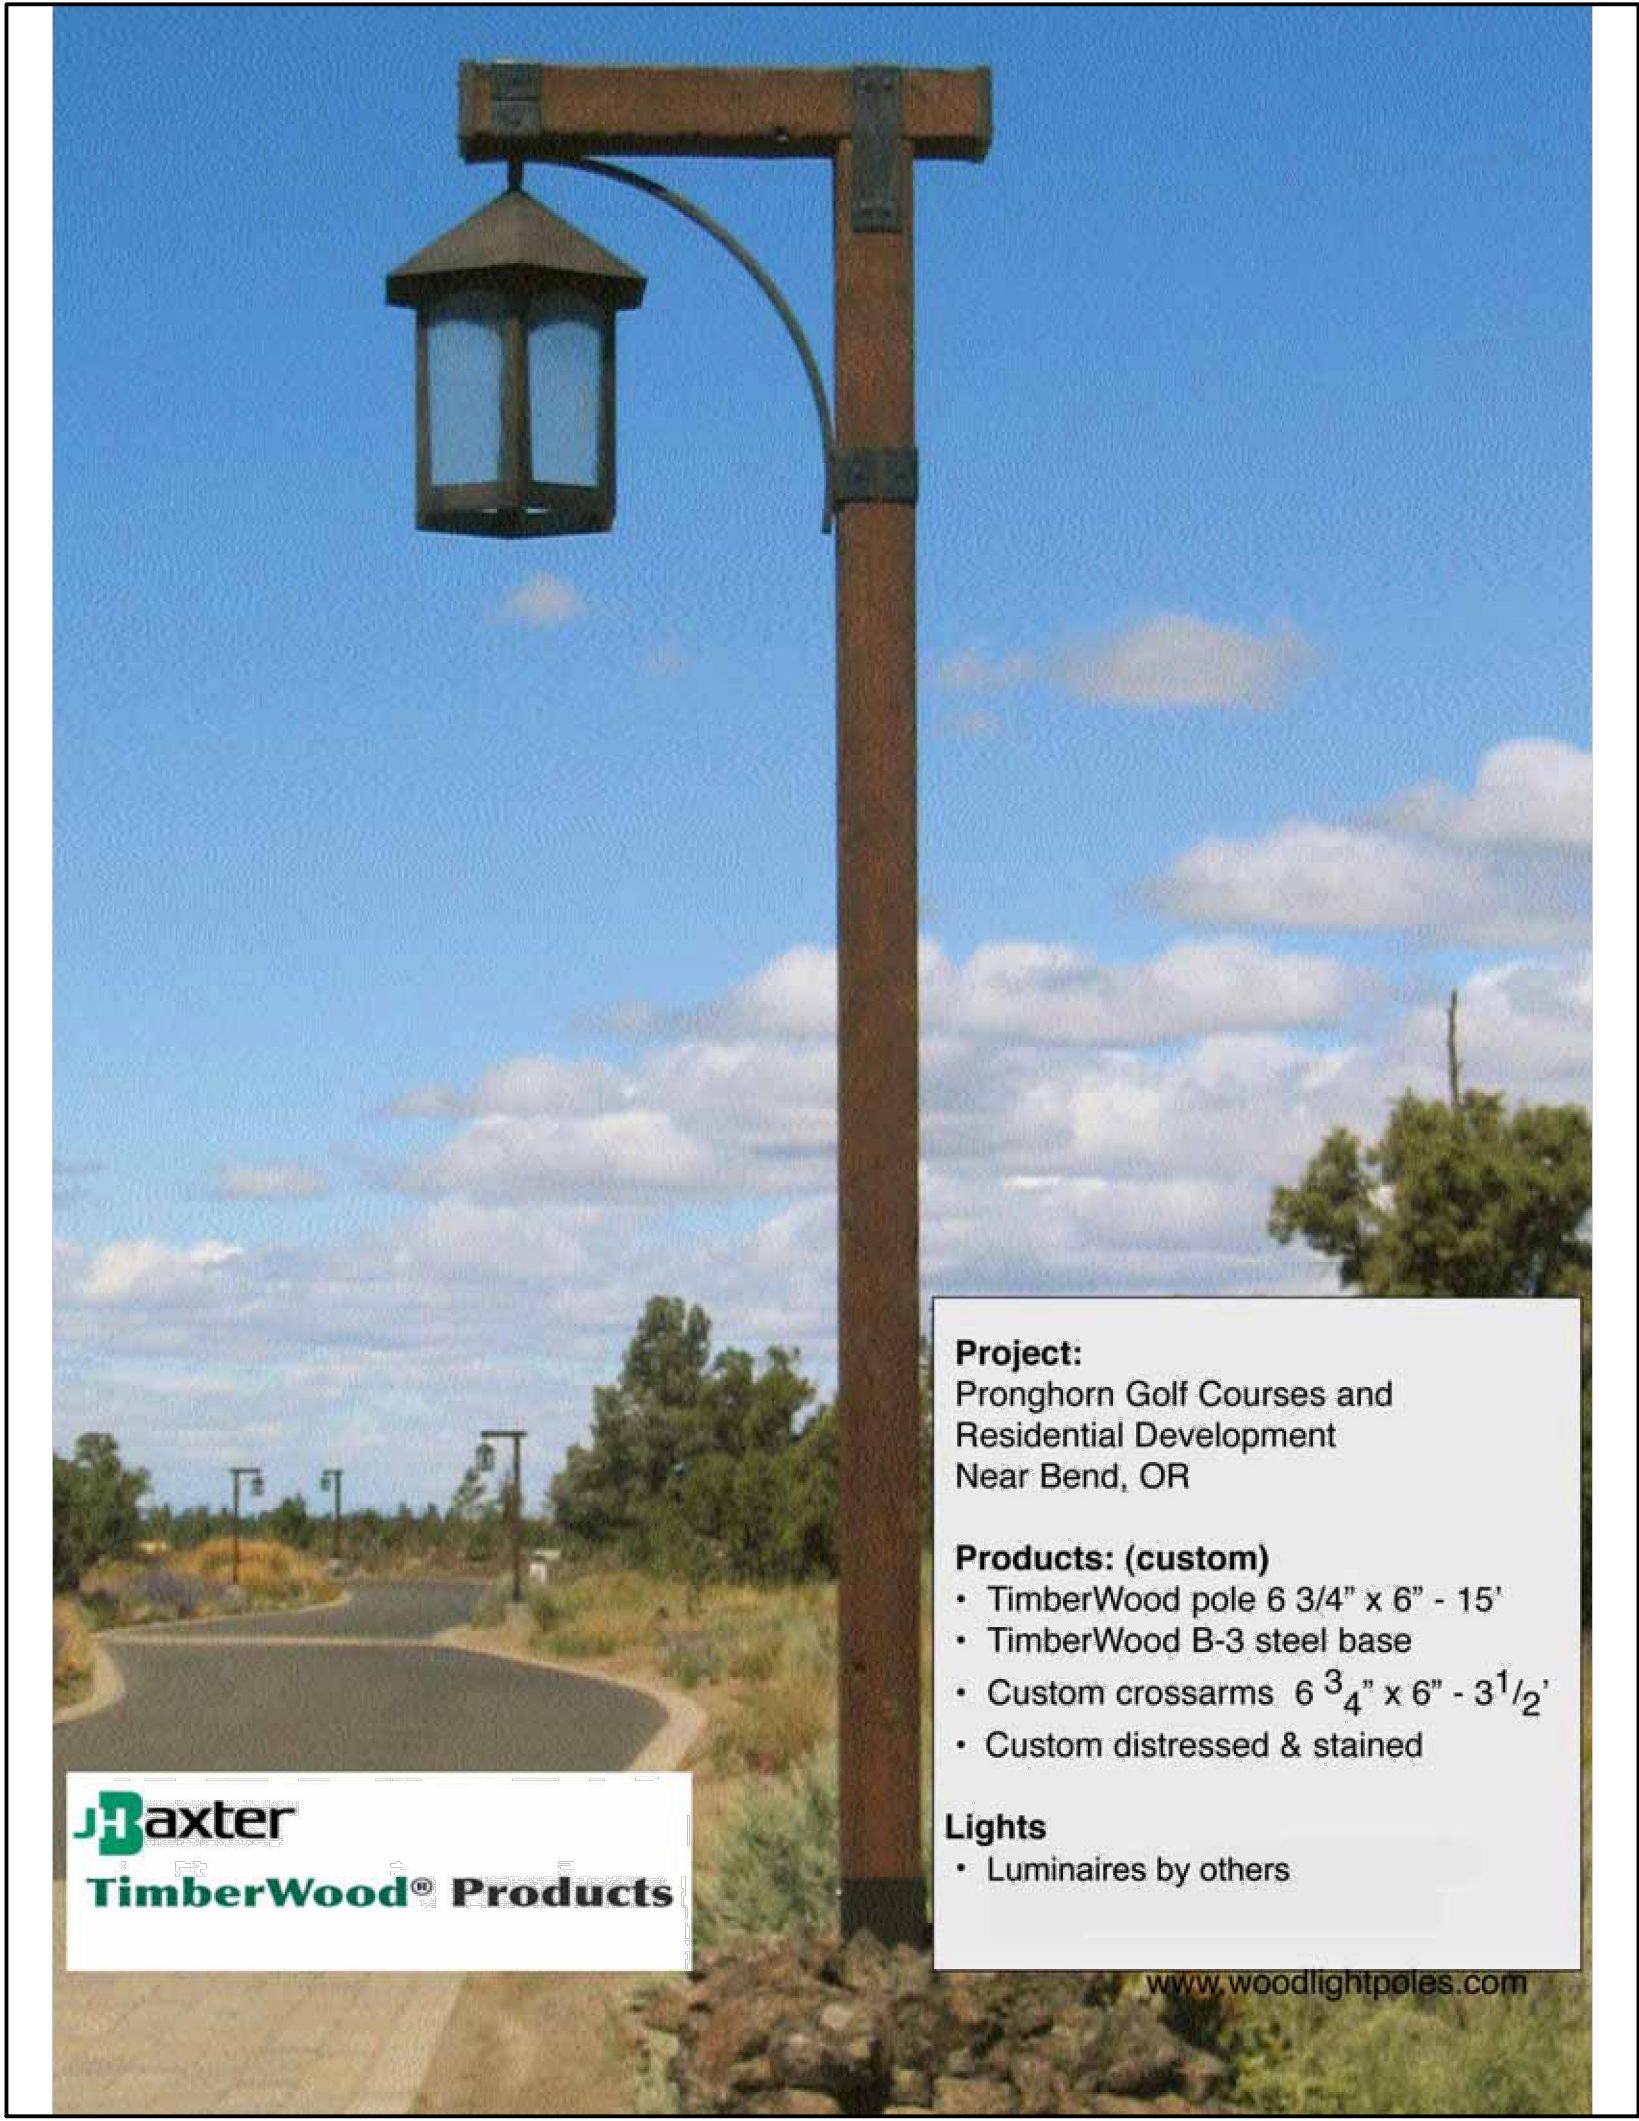

POLE FOR FIXTURE TYPE 'A'

NO SCALE



ALTERNATE POLE FOR FIXTURE TYPE 'A'

NO SCALE

LIGHTING FIXTURE SCHEDULE										
FIXTURE TYPE	MANUFACTURER AND CATALOG NUMBER	LAMPS				FIXTURE		BALLAST TYPE ①	MOUNTING ②④⑤	DESCRIPTION
		QTY.	TYPE	WATTS	COLOR TEMP.	INPUT VOLTS	TOTAL INPUT WATTS			
A	STERNBERG 1910LED/A/5RLM18/FL/4ARC45T3-FHD	-	LED	66	4500° K	480	66	DRIVER	POLE	FULL CUT OFF DECORATIVE LED FIXTURE WITH ACRYLIC LENS MOUNTED ON WOODEN POLE WITH +3'-0" ARM. BOTTOM OF FIXTURE AT 15'-0" AFG. (FIXTURE FINISH UNDETERMINED).
B	WAYNE-TYLER 310RT	-	CMH	39	4500° K	480	44	HPF	GRADE	TAPERED DECORATIVE CONCRETE BOLLARD.

Wayne :: Tyler

310R Series

Fixture type:

Catalog Number & Options:

Project:

Description: Exterior Bollard Luminaire

Luminaire Construction:

Heavy wall bronze cap and base castings with solid machined Brass support columns and spacers with heavy wall copper disk. Diffuser is etched, cylindrical polycarbonate and fully gasketed. Guard rings are heavy stainless steel and are available with a Copper plate option. H.L.D. models are provided with an integral Core and coil ballast and bracket enclosed by a cavity in the Concrete bollard base. Fluorescent models are supplied with an integral electronic ballast. A silicone gasket is provided between the lamp housing base and concrete bollard. All fasteners are stainless steel. ETL listed for wet locations.

Bollard Base Construction:

High strength cast concrete available in optional color and texture reinforced with integral steel rebar. Provided with threaded stainless steel inserts for luminaire and anchor bolt mounting.

Catalog Numbering System:

Series	Lamp	Standard Voltage	Standard Luminaire Finish	Standard Concrete Color	Standard Concrete Texture
*310RSA	60w A 19	120v	Natural	See Concrete Selection Guide for concrete color and texture	
310RSP	26w CFL	120v	Natural		
310RSH	35w HPS ED 17	120v	Natural		
310RSM	70w CMH	120v	Natural		
Series	Lamp	Standard Voltage	Standard Luminaire Finish	Standard Concrete Color	Standard Concrete Texture
*310RTA	60w A 19	120v	Natural	See Concrete Selection Guide for concrete color and texture	
310RTP	26w CFL	120v	Natural		
310RTH	35w HPS ED 17	120v	Natural		

See "CONCRETE OPTIONS" for additional color and texture options at no additional cost.

Options available at additional cost:

1. Use suffix **NP** for nickel plate
2. Use suffix **277** to specify 277 volt operation. 120v is standard, asterisk (*) indicates luminaires not available in 277 volts

5797 Chesapeake Ct. Suite 100 San Diego, Ca 92123 p: (858) 560-4800 :: f: (858) 560-4802

FIXTURE TYPE 'B'

NO SCALE

TURPIN & RATTAN

ENGINEERING, INC.

CONSULTING ENGINEERS

4719 PALM AVENUE

LA MESA, CA 91941-5221

619 / 480-1622 FAX 480-1623

E-MAIL: ENGINEER@TREISO.COM

TREI # 11348.01

6.0004.02/14/13 - 0.377W

01/11/15 48010ACADPREU11348.01_SHT 3_FIXTURE SCHEDULE.DWG

REGISTERED PROFESSIONAL ENGINEER

NEAL ALAQUA

13829


Exp. 6-30-14

ELECTRICAL


STATE OF CALIFORNIA

Wimmer
Yamada
and
Caughy


COUNTY OF SAN DIEGO TM 5572- RPL1
IMPLEMENTING TM LANDSCAPE CONCEPT PLAN FOR:
LILAC HILL RANCH
LIGHT FIXTURE SCHEDULE

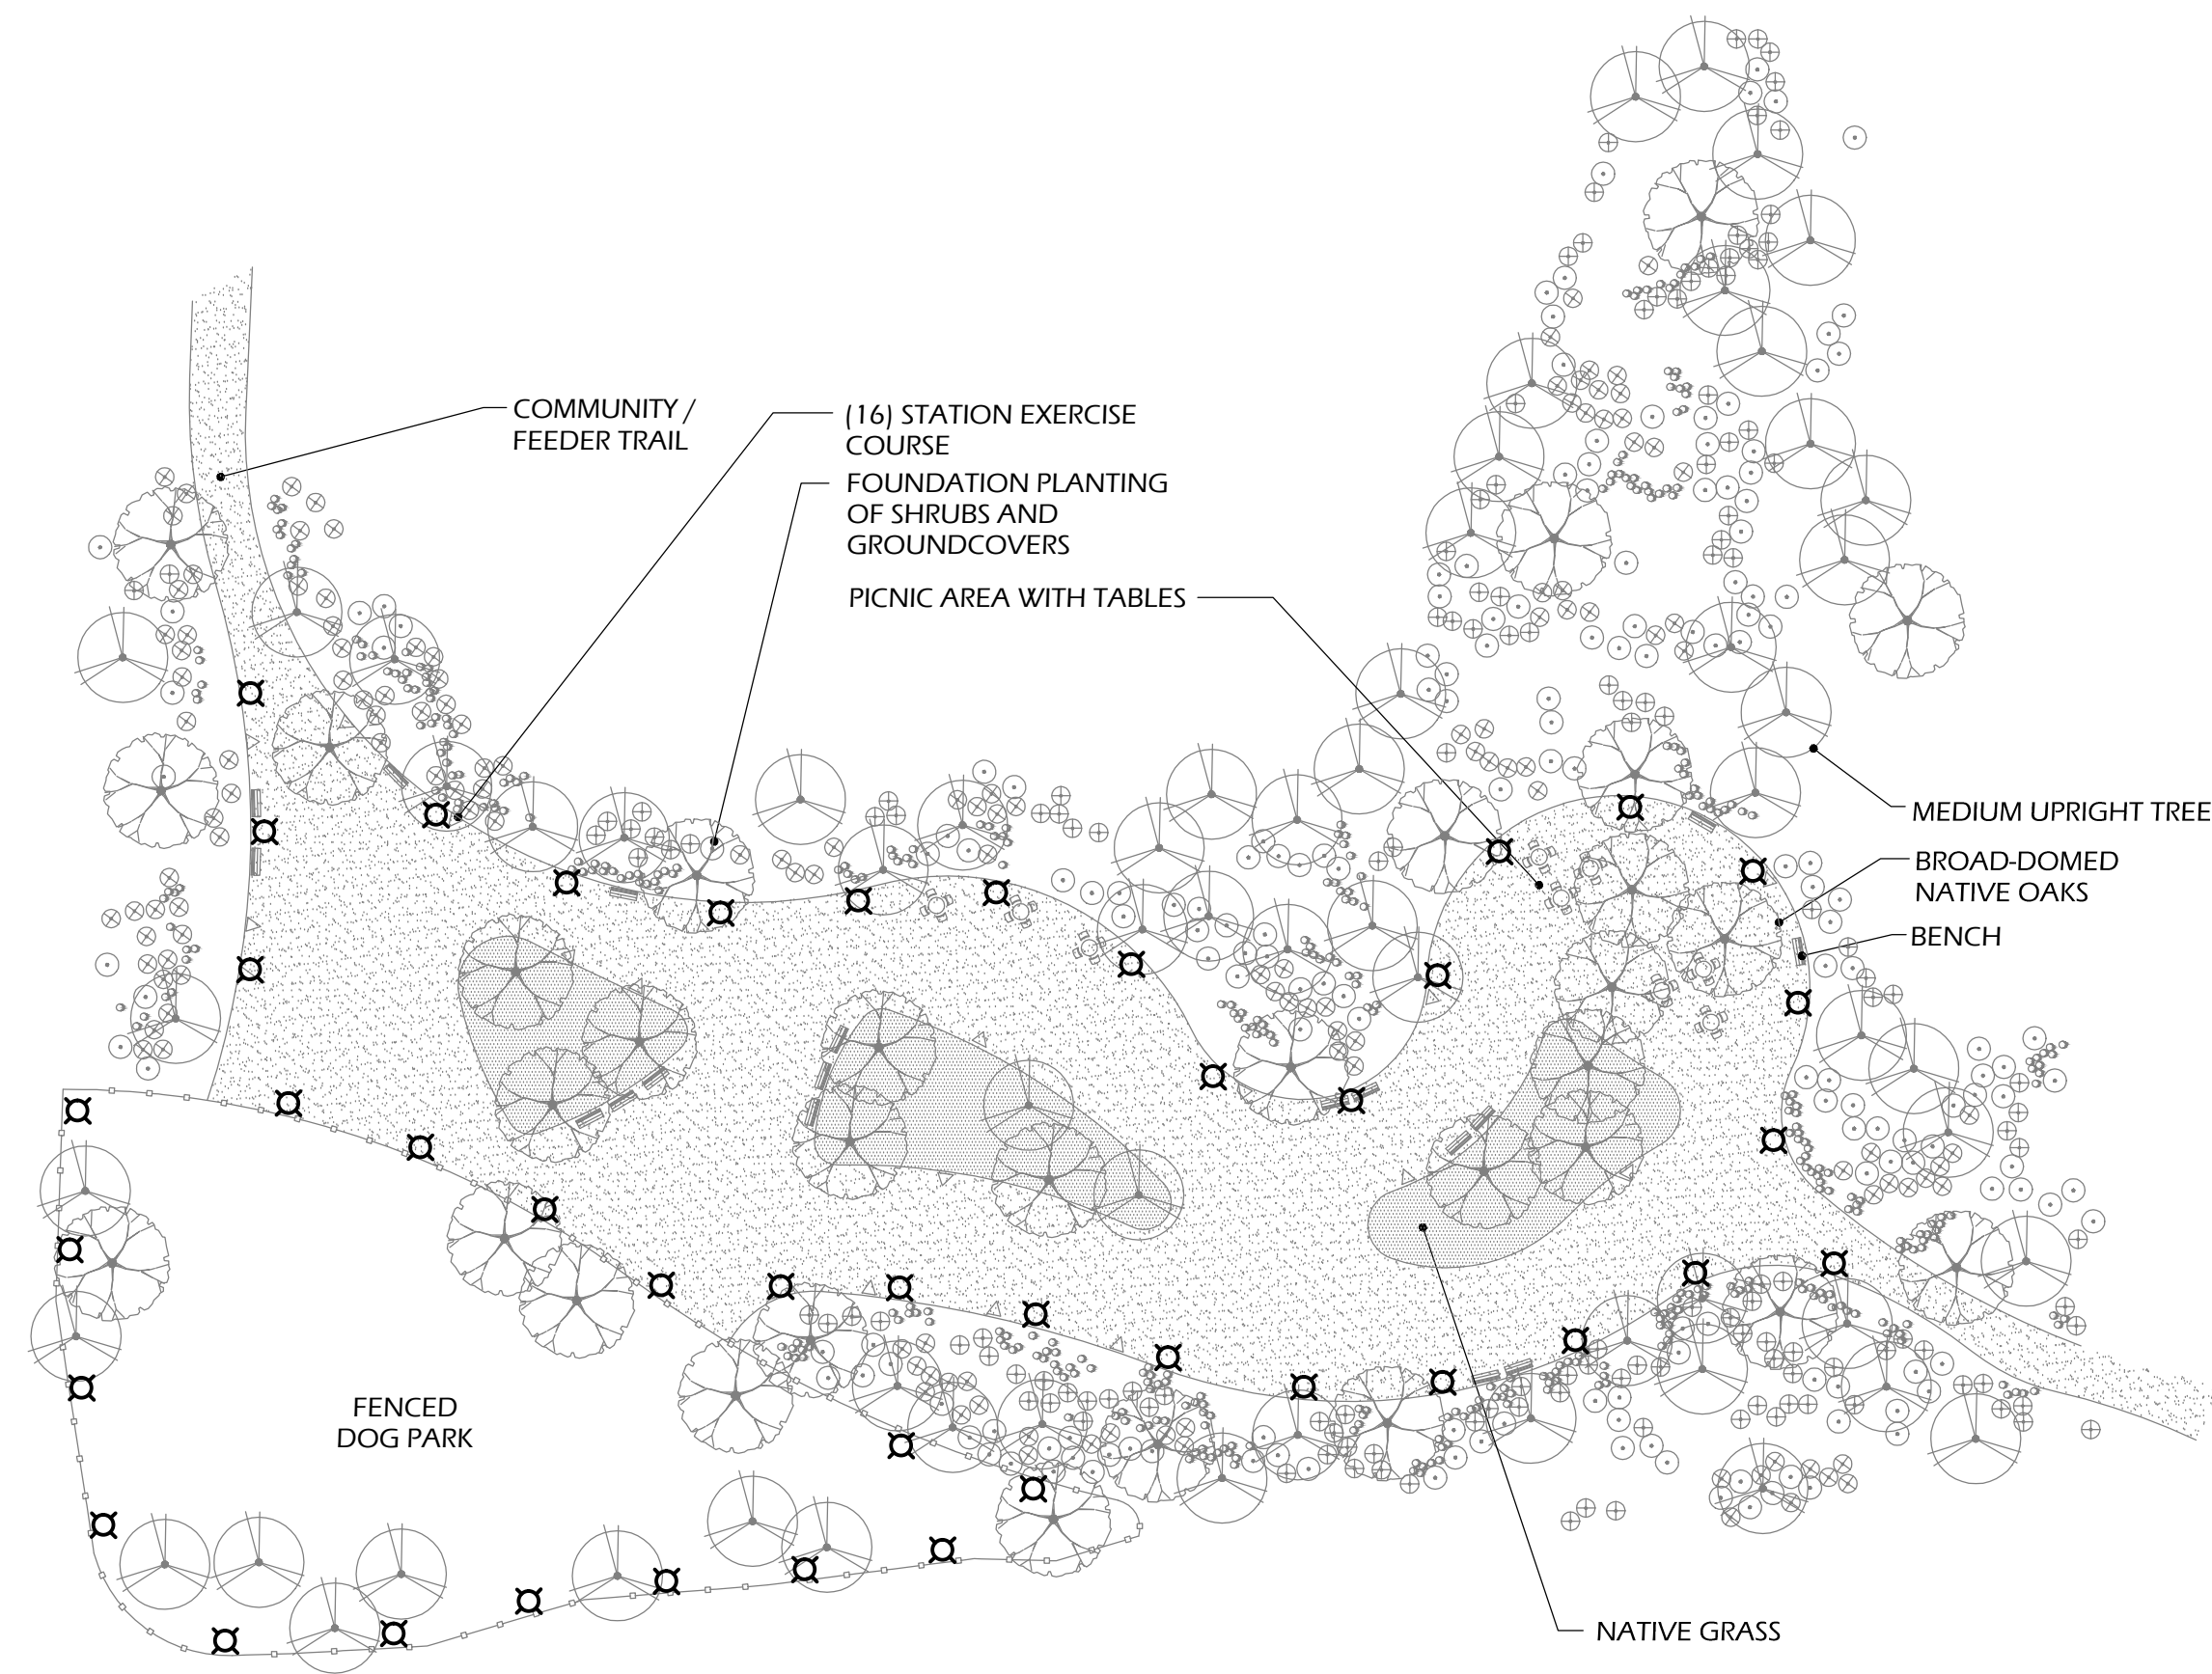


ENLARGED FITNESS CENTER PARK (P1)
SCALE: 1"=40'-0"
0 20' 40' 80' 120'
1" = 40'-0"

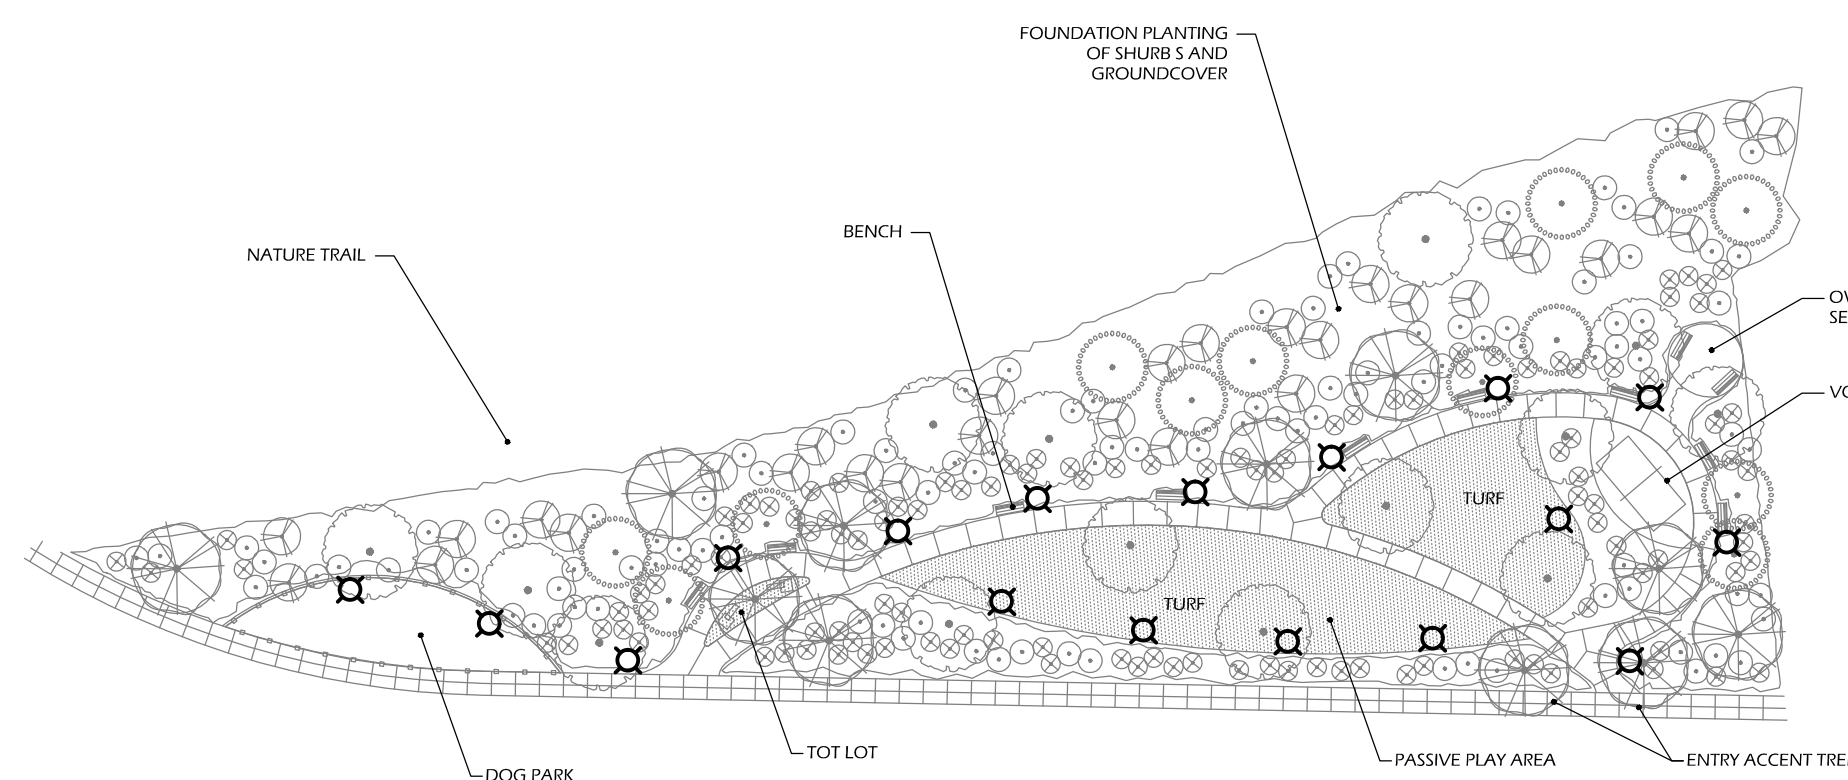


ENLARGED PORT PARK (P2)
SCALE: 1"=40'-0"
0 20' 40' 80' 120'
1" = 40'-0"

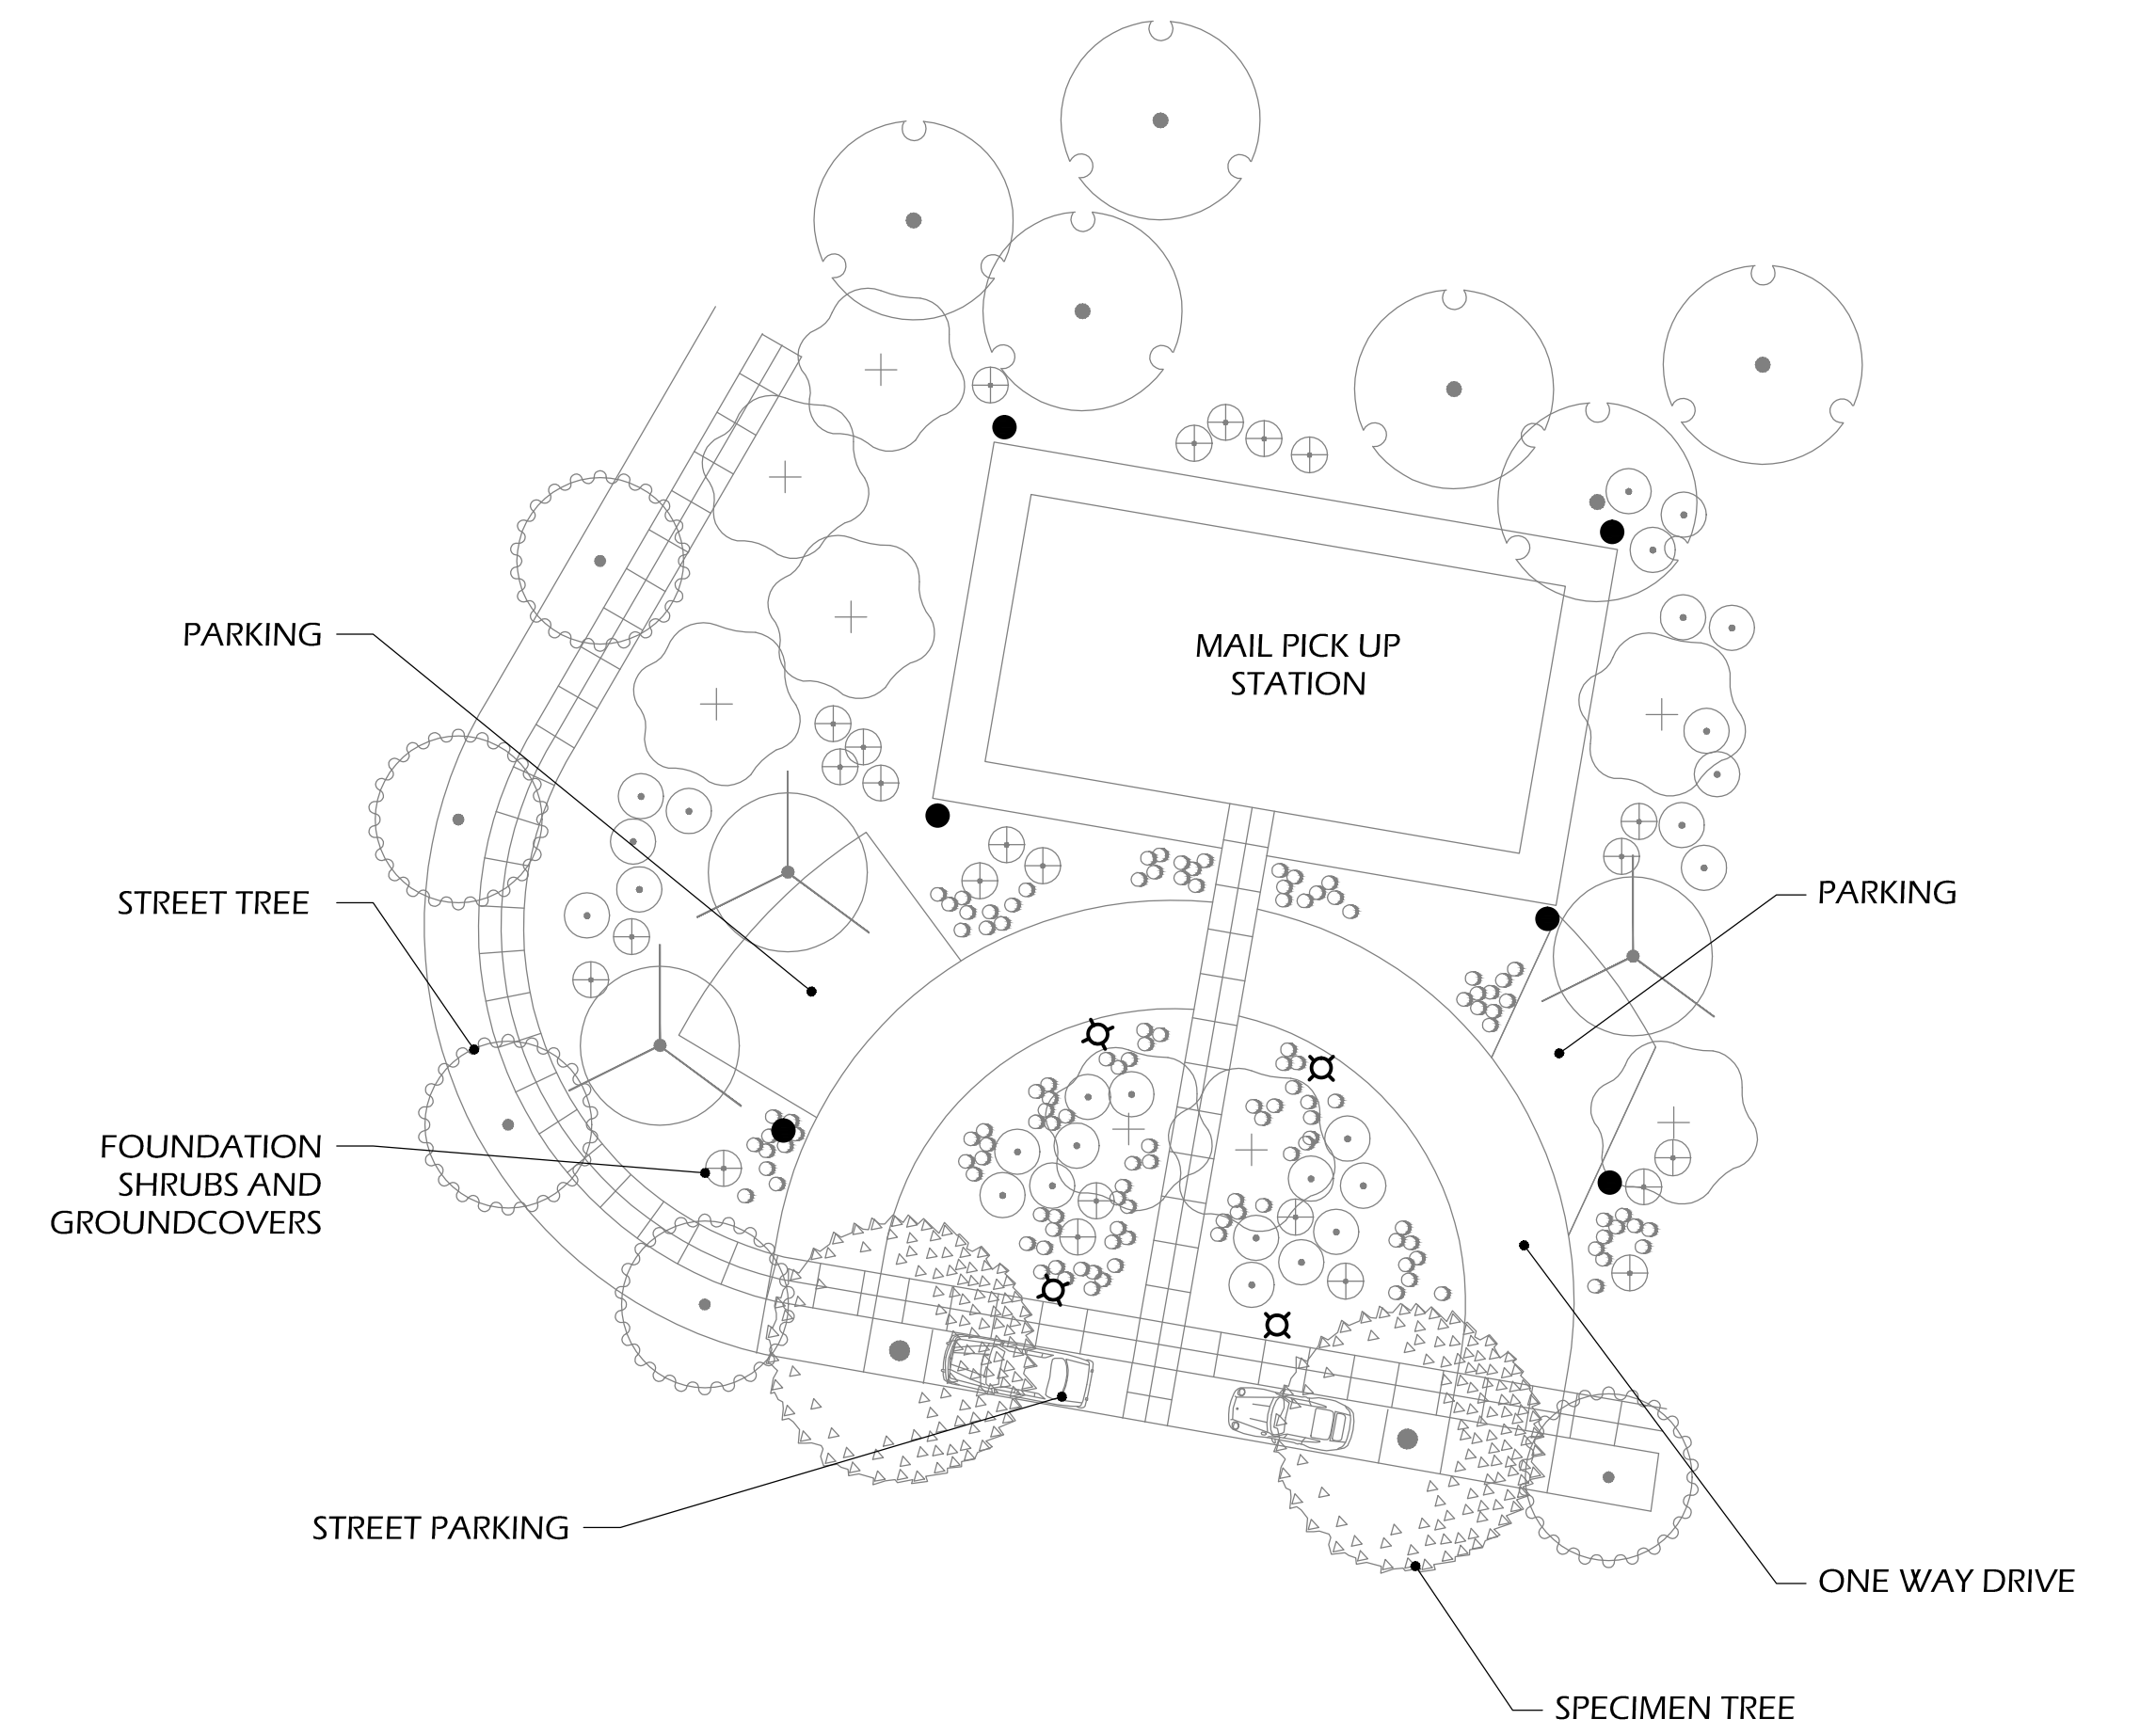

ENLARGED PICK UP STATION (P3)
SCALE: 1"=20'-0"
0 10' 20' 40' 60'
1" = 20'-0"

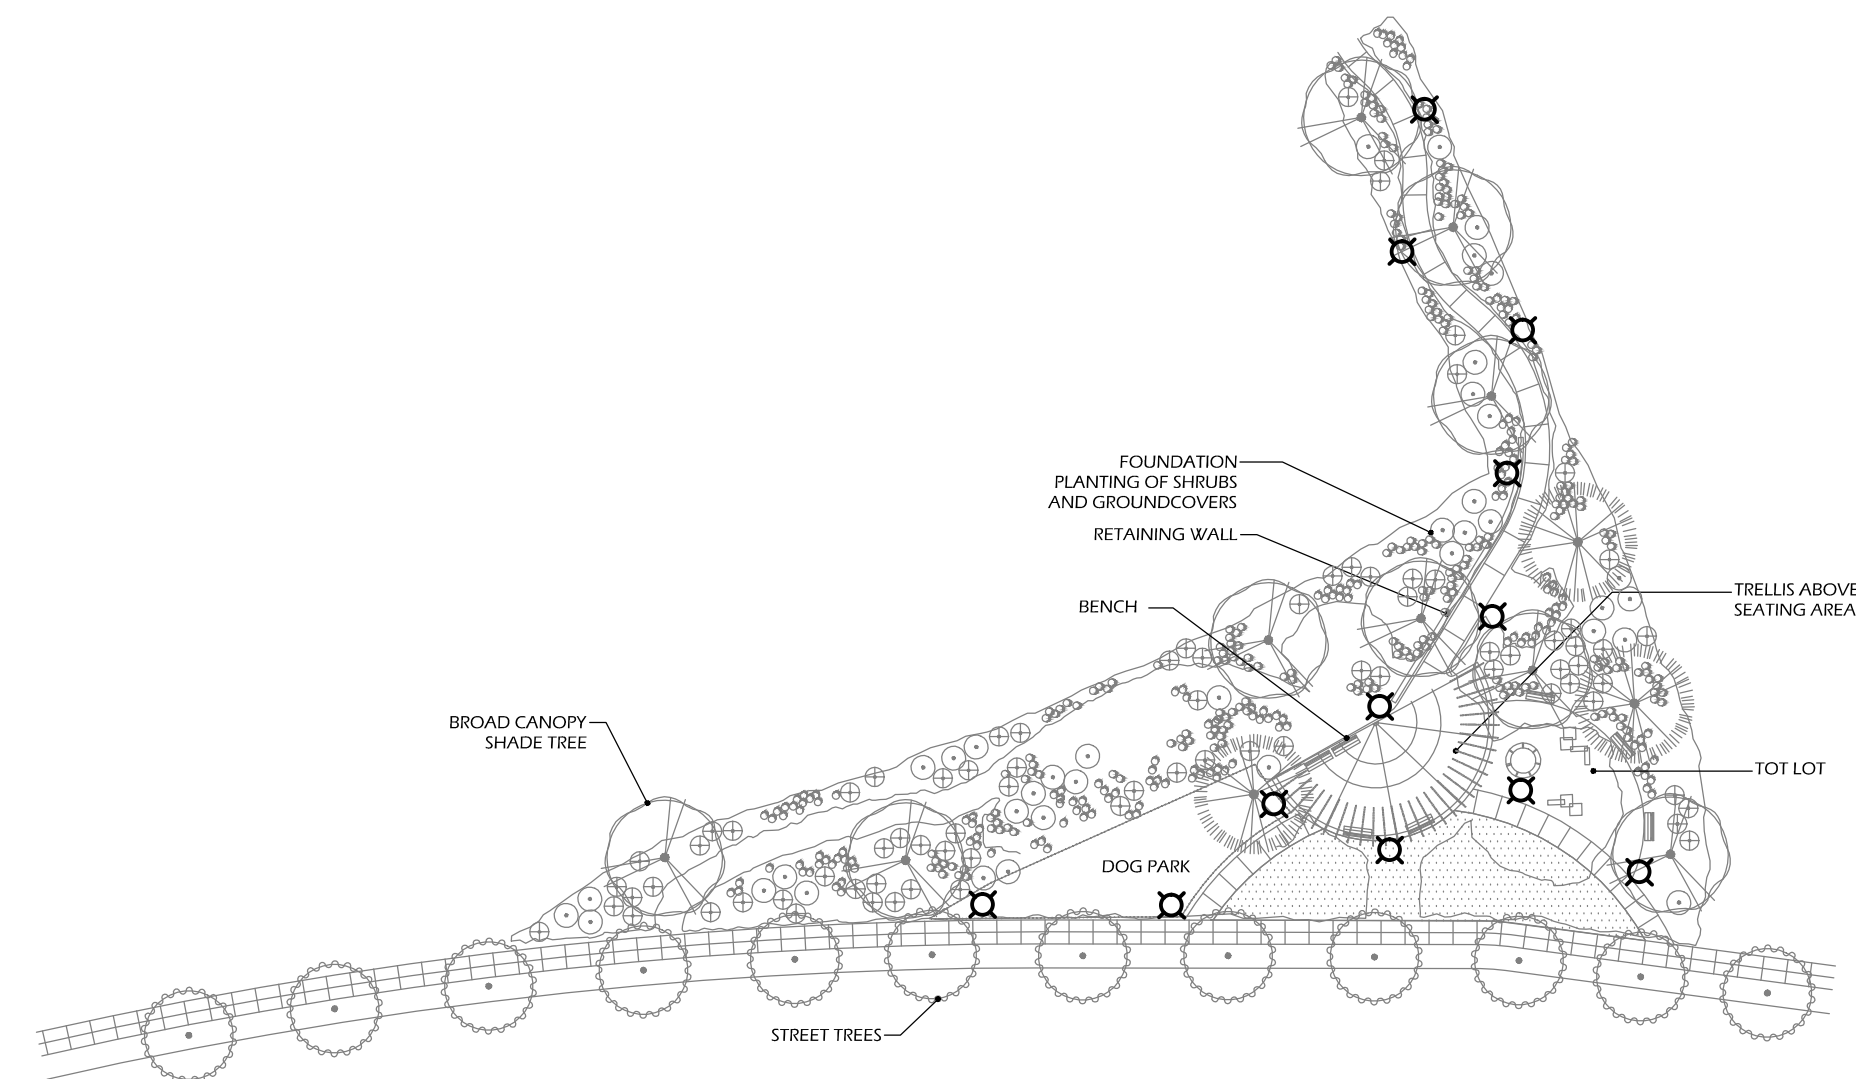


ENLARGED GARDEN PARK (P4)
SCALE: 1"=40'-0"
0 20' 40' 80' 120'
1" = 40'-0"

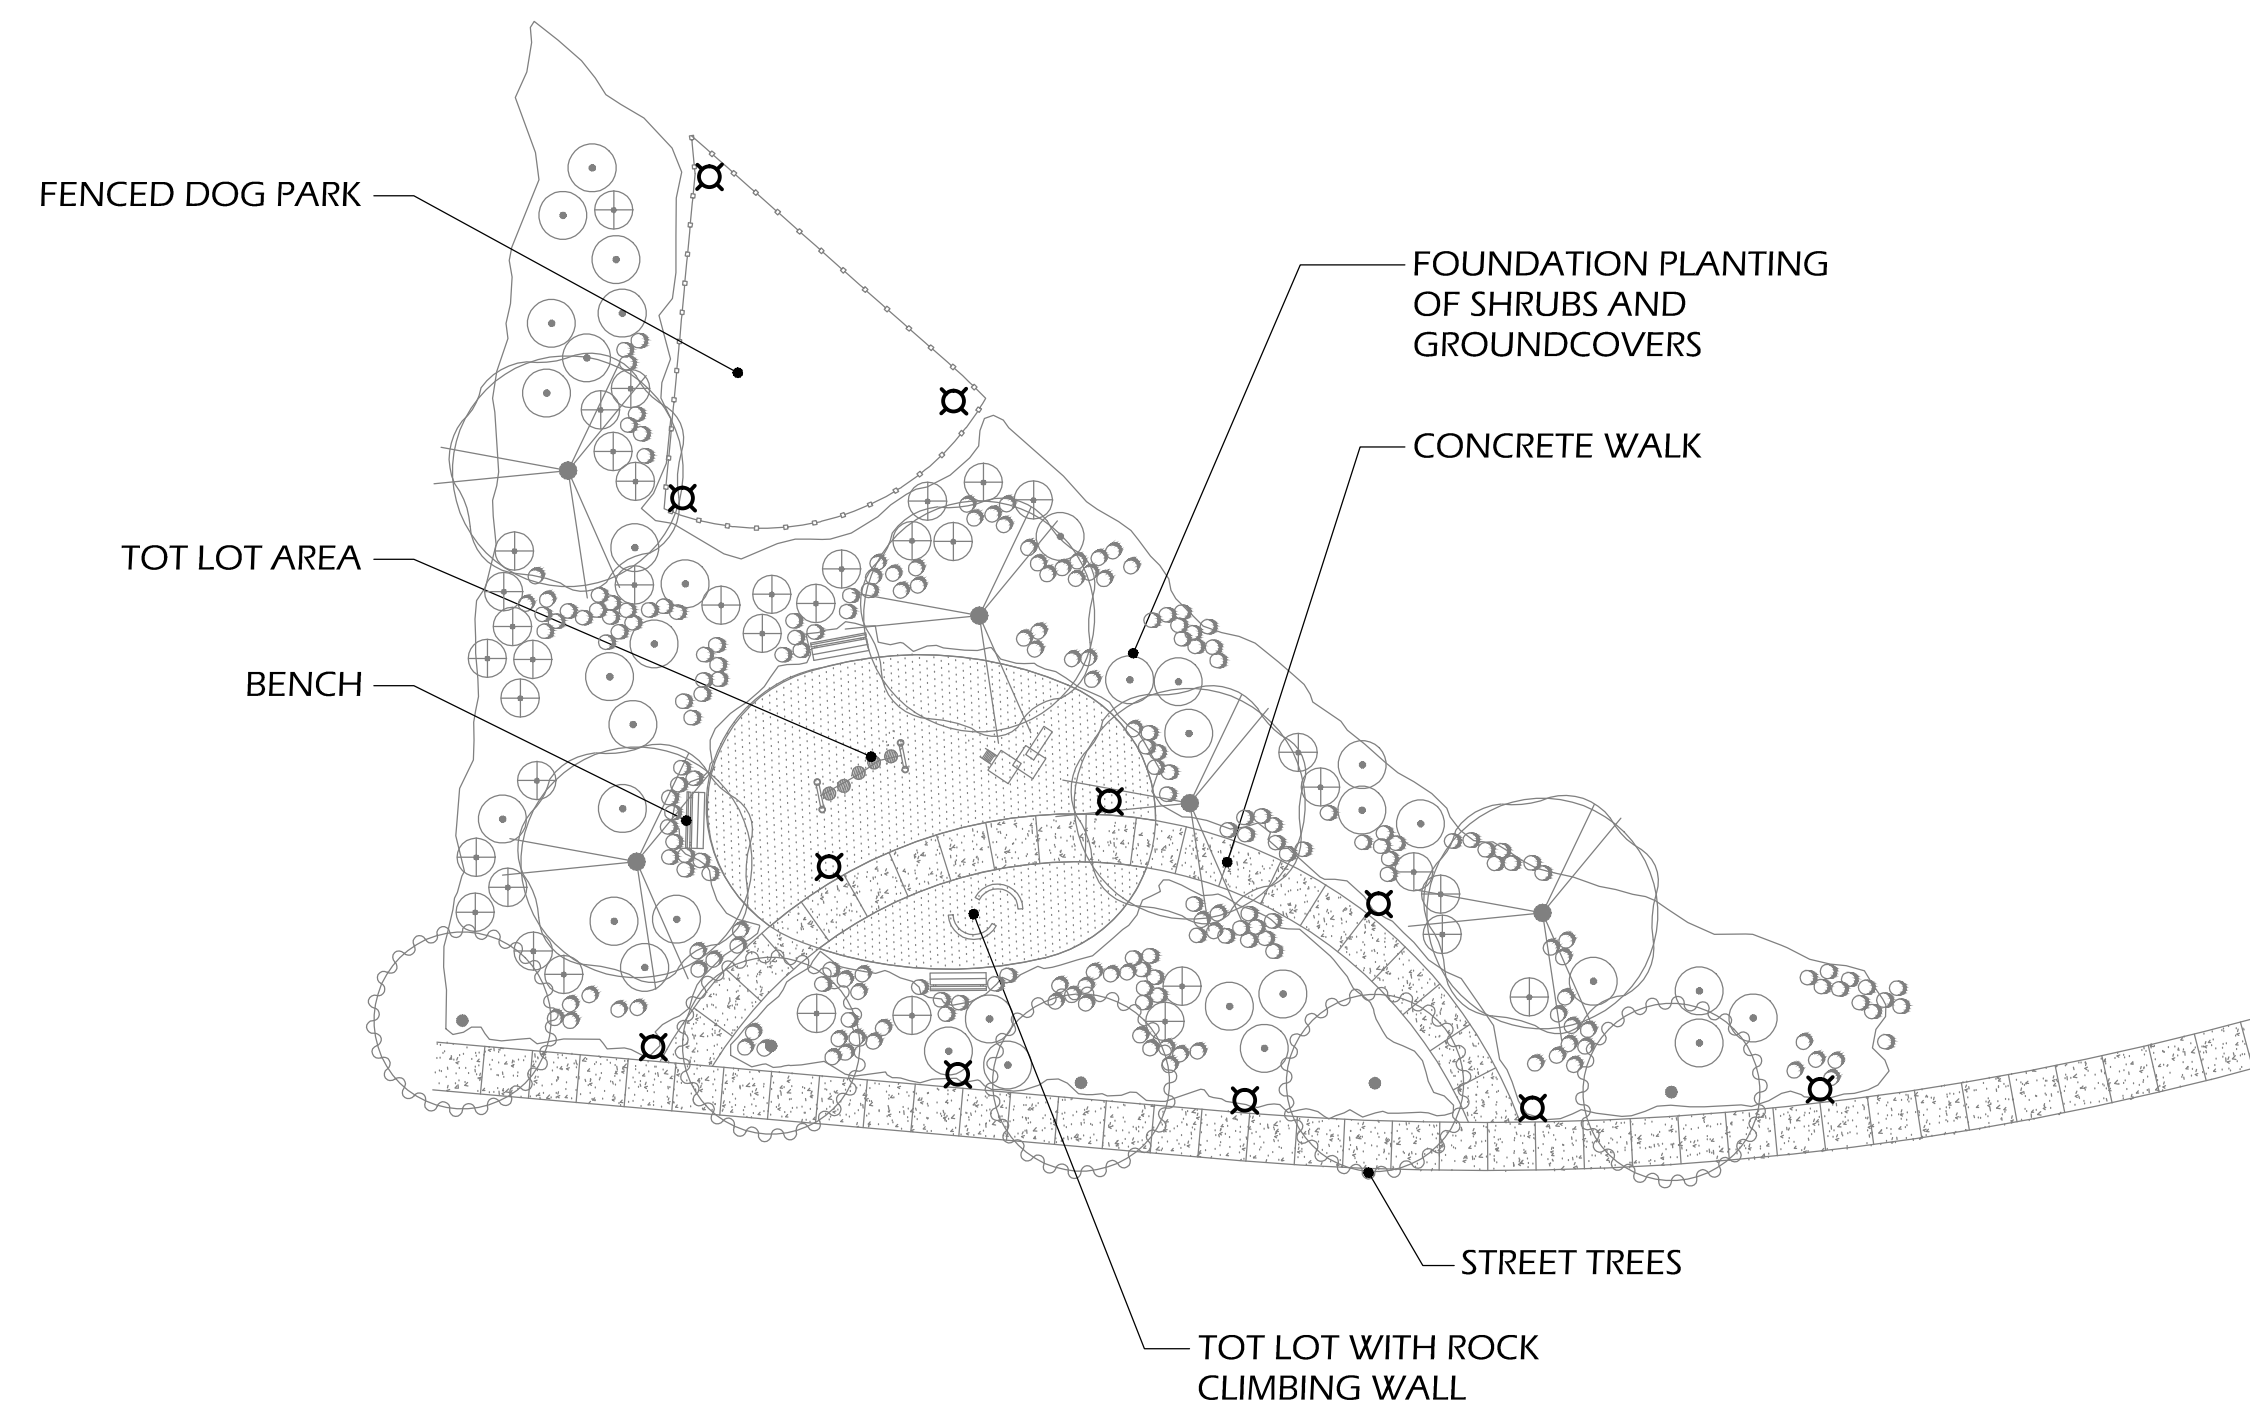

ENLARGED CLIMBER POCKET PARK (P5)
SCALE: 1"=20'-0"
0 10' 20' 40' 60'
1" = 20'-0"

TURPIN & RATTAN
ENGINEERING, INC.
CONSULTING ENGINEERS
4719 PALM AVENUE
LA MESA, CA 91941-5221
619 / 480-1622 FAX 480-1623
E-MAIL: ENGINEER@TRBIO.COM
TREI # 11348.01

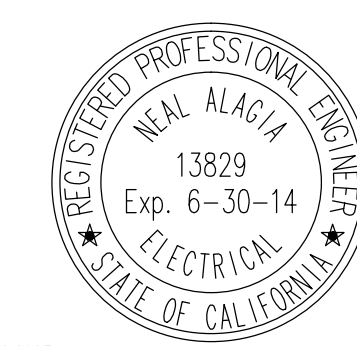


**Wimmer
Yamada
and
Caughy**

COUNTY OF SAN DIEGO TM 5572-RPL1
IMPLEMENTING TM LANDSCAPE CONCEPT PLAN FOR:

LILAC HILL RANCH

ENLARGED PARK PLANS

SHEET NO. 4 OF 14


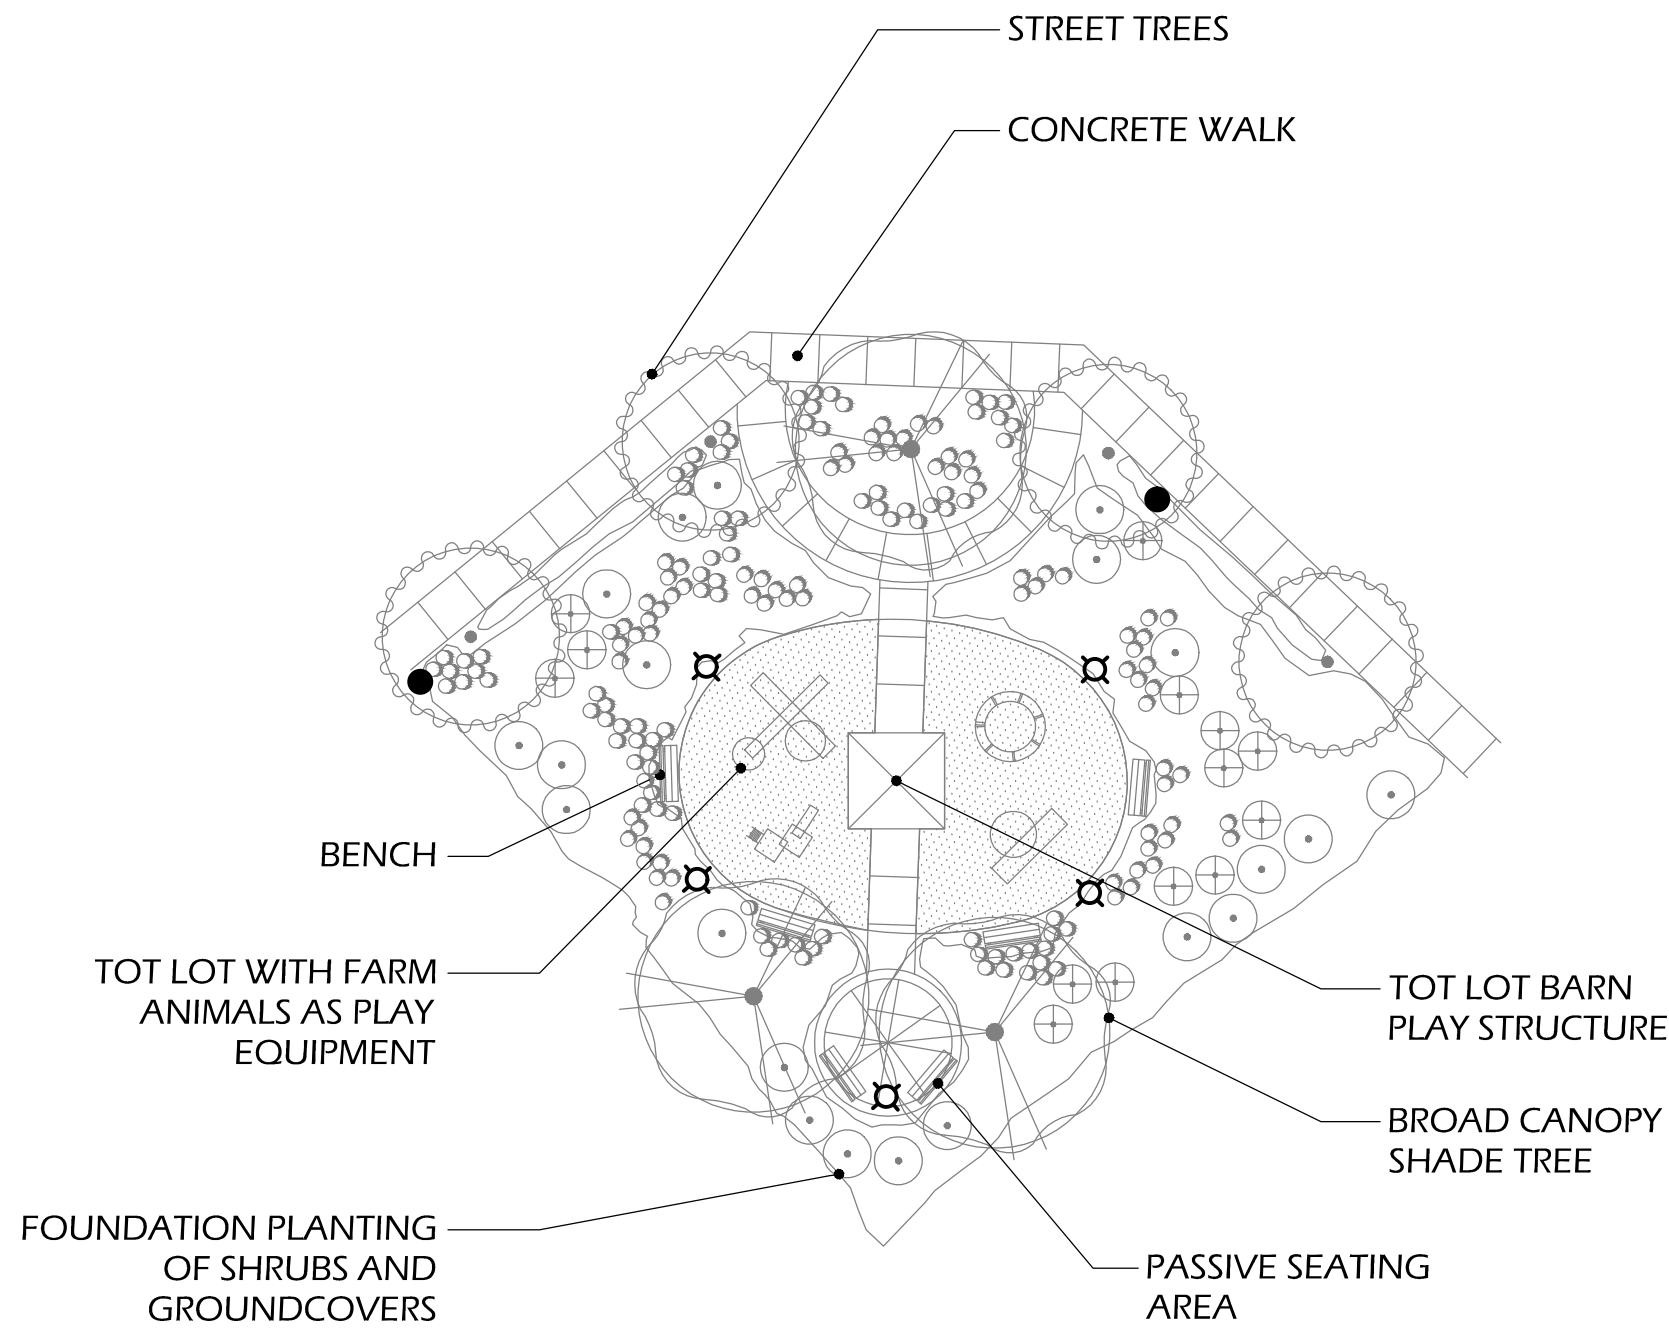


ENLARGED THE BARN (P6)

SCALE: 1"=40'-0"



1" = 20'-0"

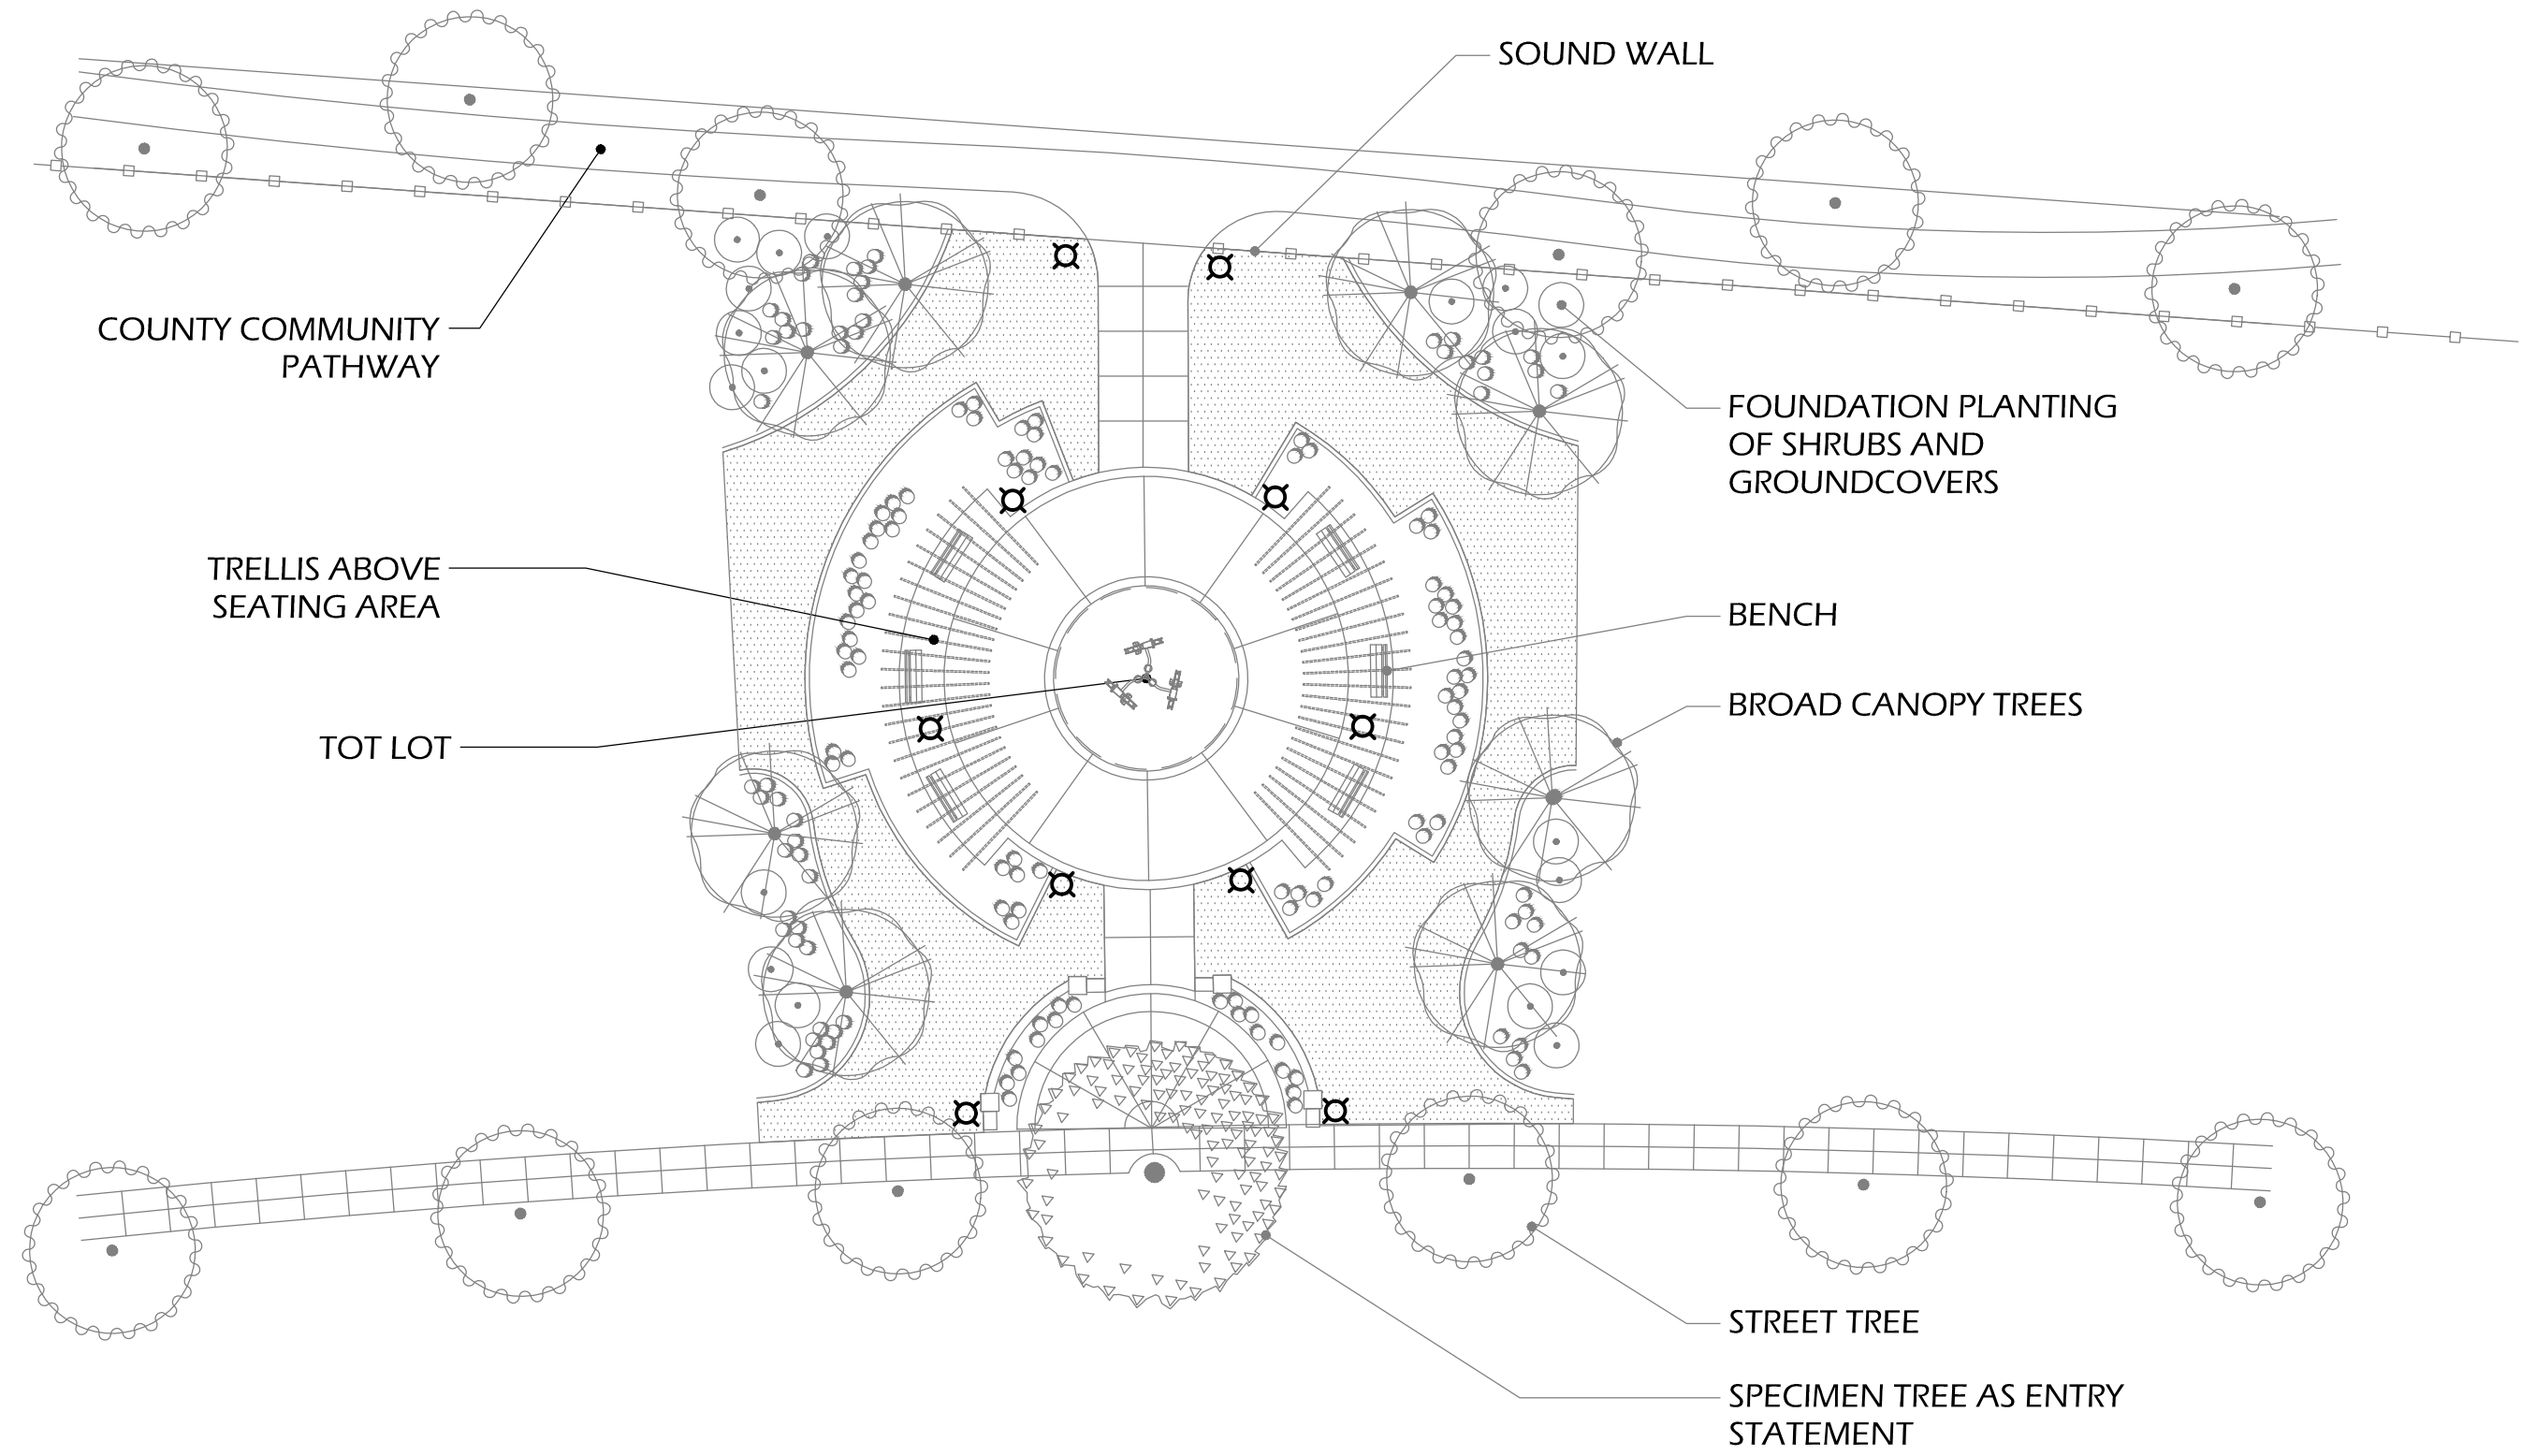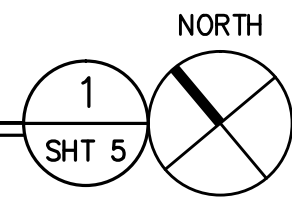


ENLARGED NEIGHBORHOOD PARK (P7)


SCALE: 1"=40'-0"



1" = 20'-0"

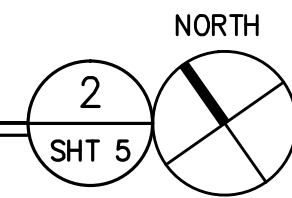

TURPIN & RATTAN
ENGINEERING, INC.
CONSULTING ENGINEERS
4719 PALM AVENUE
LA MESA, CA 91941-5221
619 / 480 / 6224 FAX 406 / 6233
E-MAIL: ENGINEER@TR&R.COM
TREI # 11348.01

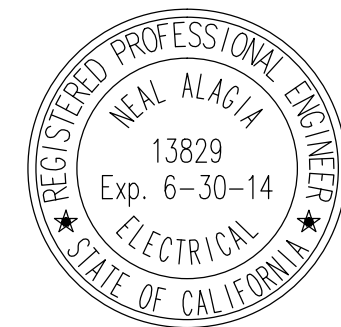

**Wimmer
Yamada
and
Caughy**



COUNTY OF SAN DIEGO TM 5572- RPL1
IMPLEMENTING TM LANDSCAPE CONCEPT PLAN FOR:

LILAC HILL RANCH

ENLARGED PARK PLANS

SHEET NO. 5 OF 14



PARTIAL PHOTOMETRICS SHEET #1

SCALE: 1"=30'-0"




TURPIN & RATTAN
ENGINEERING, INC.
CONSULTING ENGINEERS
4719 PALM AVENUE
LA MESA, CA 91941-5221
619 / 486-6224 FAX 486-6233
E-MAIL: ENGINEER@TREISO.COM

TREI # 11348.01
6/19/13 02:14:13 0:30PM
D:\11348\61348\PHOTO\11348-01_SHT 6-13_Photometrics.dwg



**Wimmer
Yamada
and
Caughy**

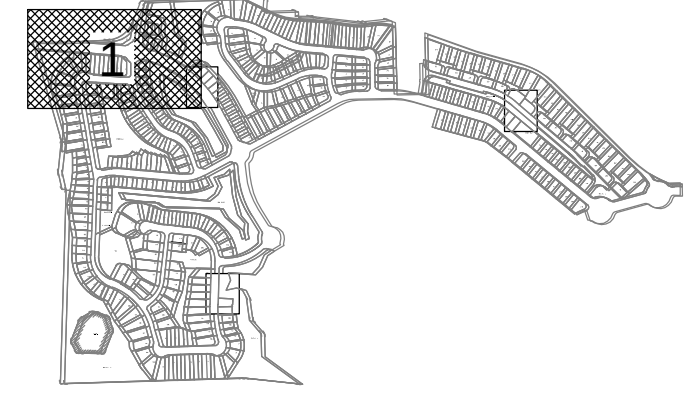


SHEET INDEX
NOT TO SCALE

**COUNTY OF SAN DIEGO TM 5572- RPL1
IMPLEMENTING TM LANDSCAPE CONCEPT PLAN FOR:**

LILAC HILL RANCH

PARTIAL PHOTOMETRICS SHEET #1

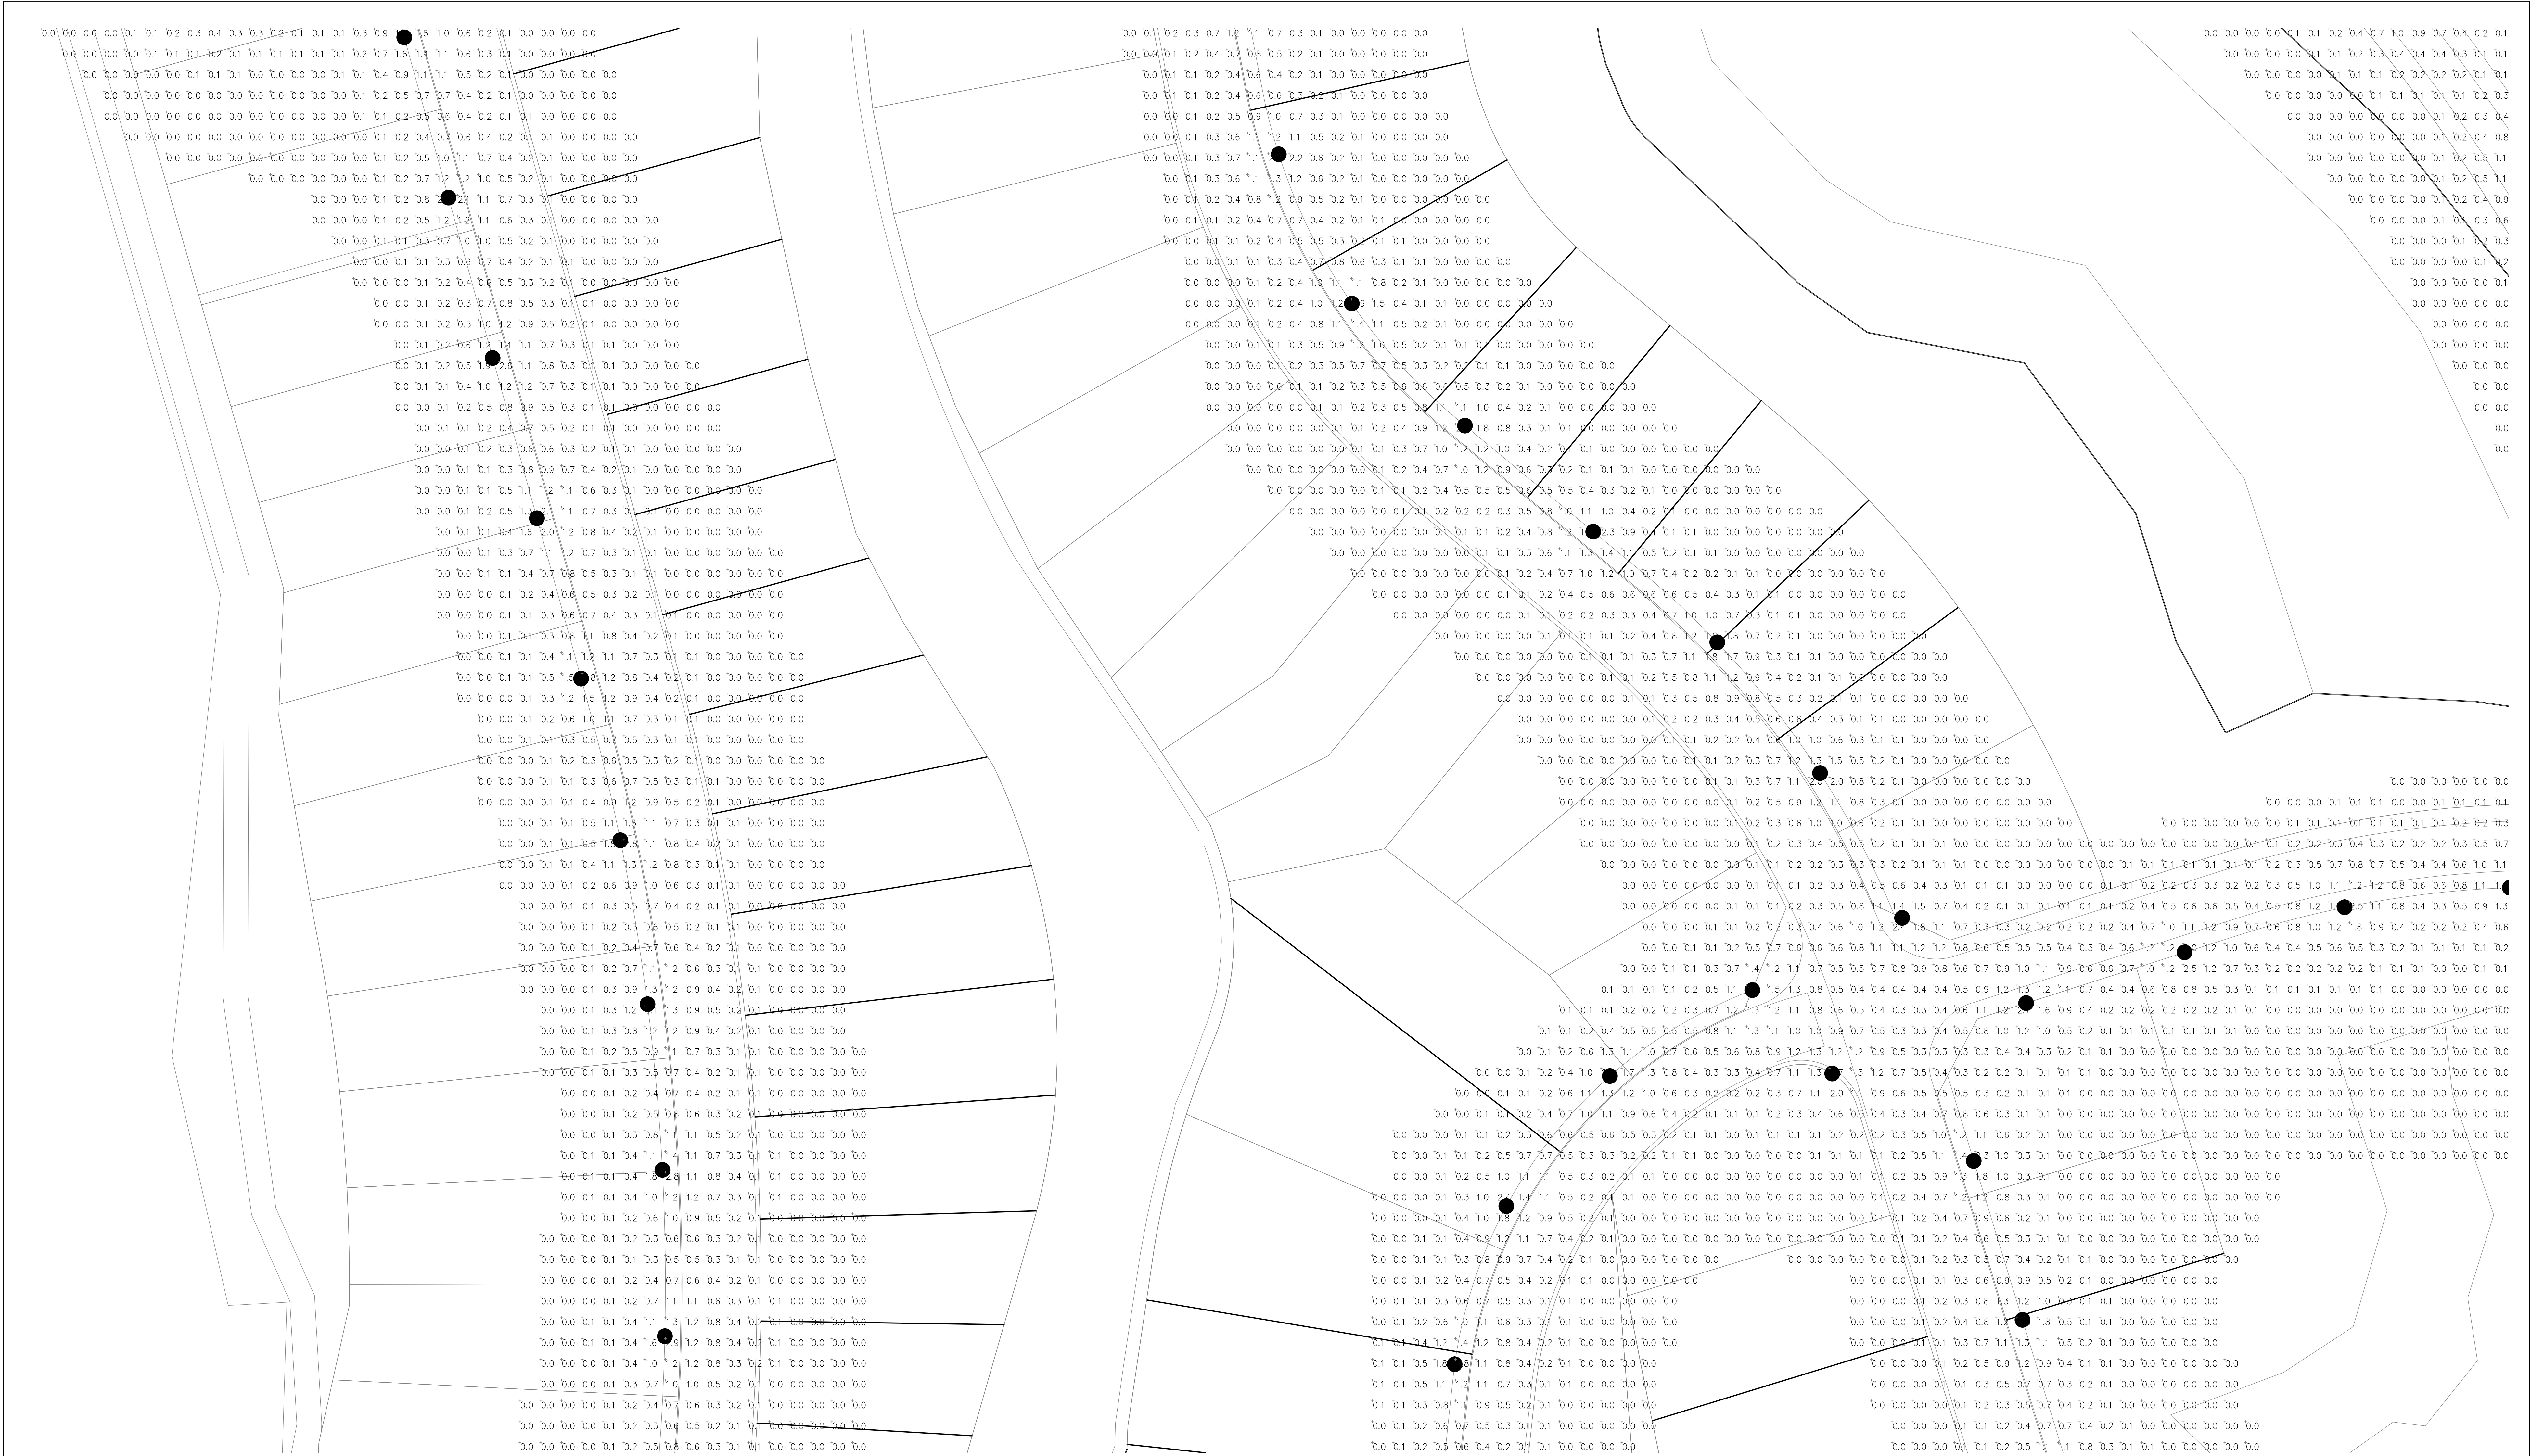

PARTIAL PHOTOMETRICS SHEET #2
SCALE: 1"=30'-0"




TURPIN & RATTAN
ENGINEERING, INC.
CONSULTING ENGINEERS
4719 PALM AVENUE
LA MESA, CA 91941-5221
619 / 486-6224 FAX 486-6233
E-MAIL: ENGINEER@TREI.COM

TREI # 11348.01
6/20/04 02:14:13 P:330H
01111154801ACADPREU11348.01_SHT 6-13_Photometrics.dwg




**Wimmer
Yamada
and
Caughy**

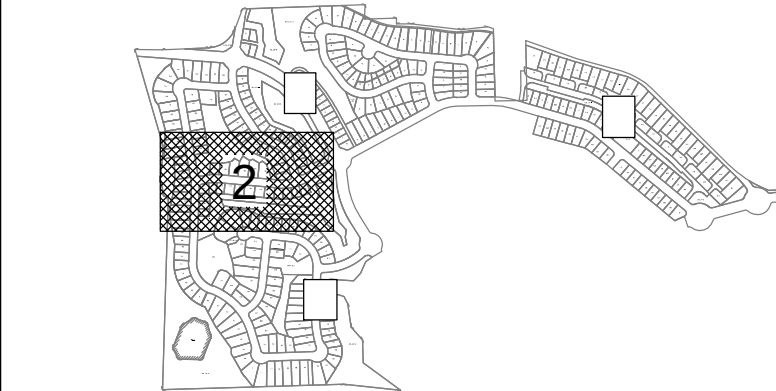

COUNTY OF SAN DIEGO TM 5572- RPL1
IMPLEMENTING TM LANDSCAPE CONCEPT PLAN FOR:

LILAC HILL RANCH

PARTIAL PHOTOMETRICS SHEET #2

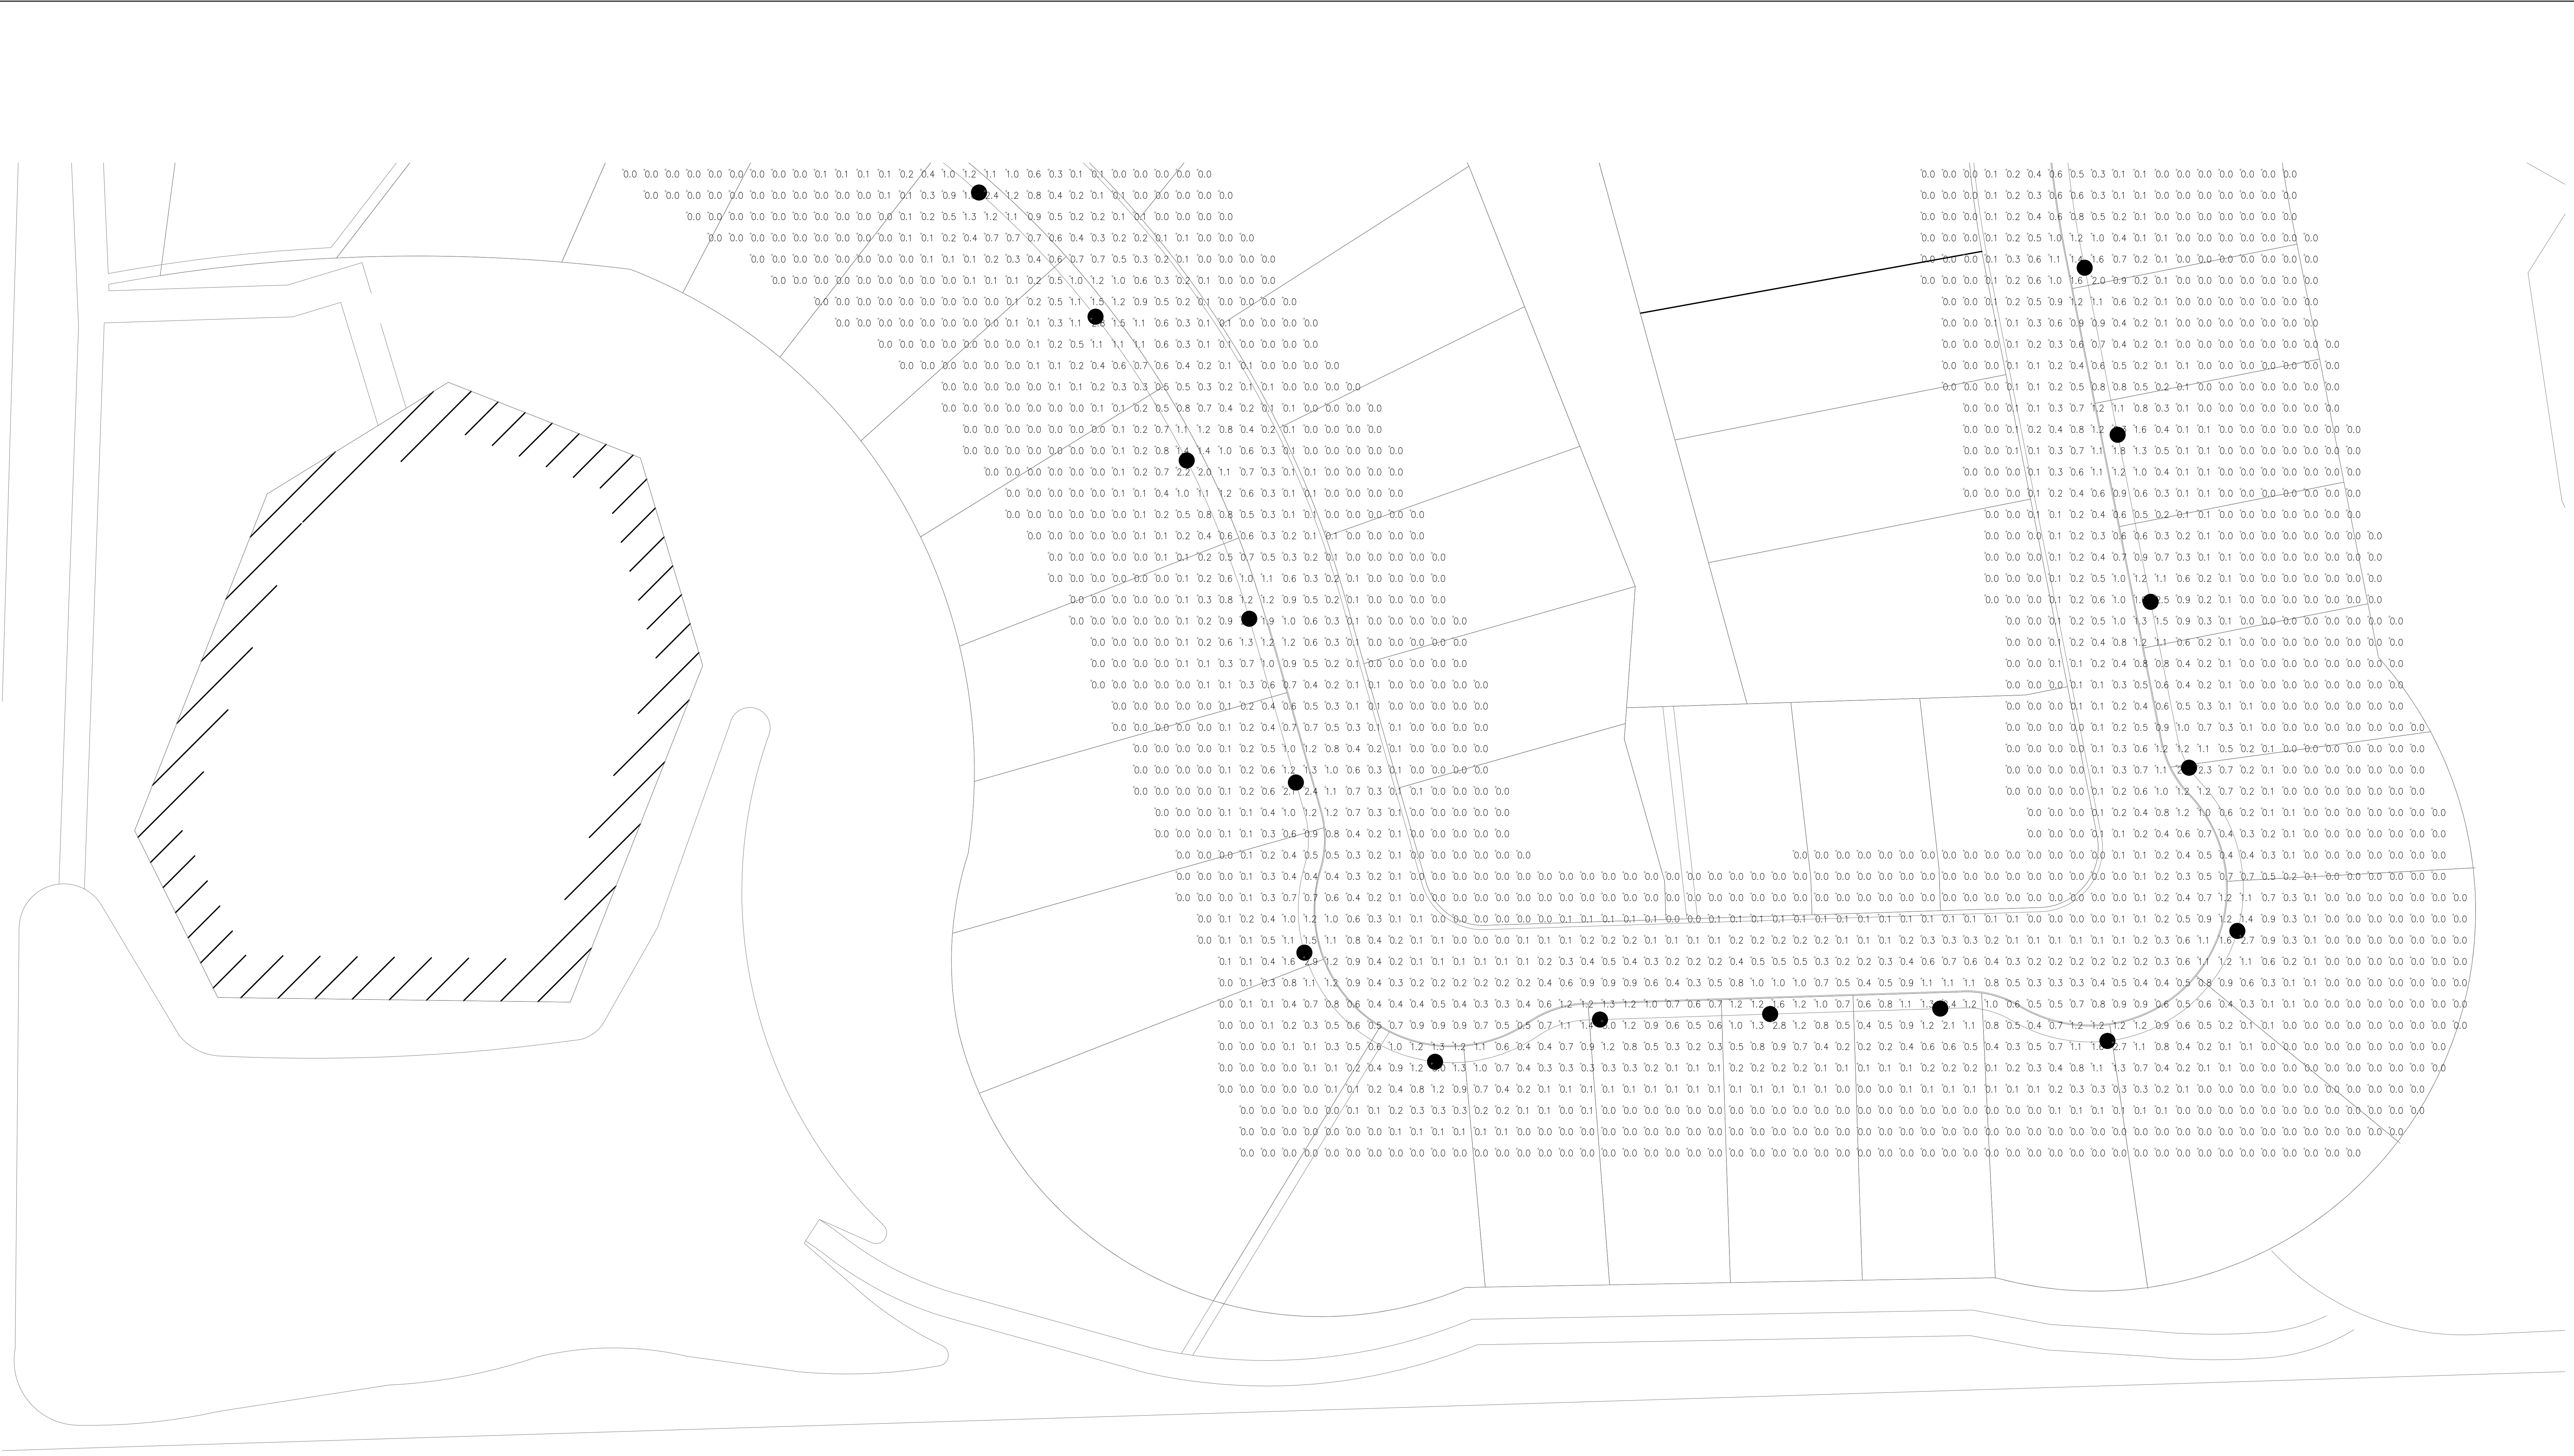


PARTIAL PHOTOMETRICS SHEET #4

SCALE: 1"=30'-0"




TURPIN & RATTAN
ENGINEERING, INC.
CONSULTING ENGINEERS
4719 PALM AVENUE
LA MESA, CA 91941-5221
619 / 480 / 6224 FAX 480 / 6233
E-MAIL: ENGINEER@TRBIO.COM
TREI # 11348.01

6/20/2014 11:13 AM
01111134801ACADPHOTO11348.01_SHT 4-13_Photometrics.dwg

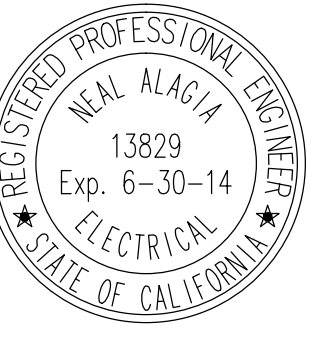

**Wimmer
Yamada
and
Caughy**

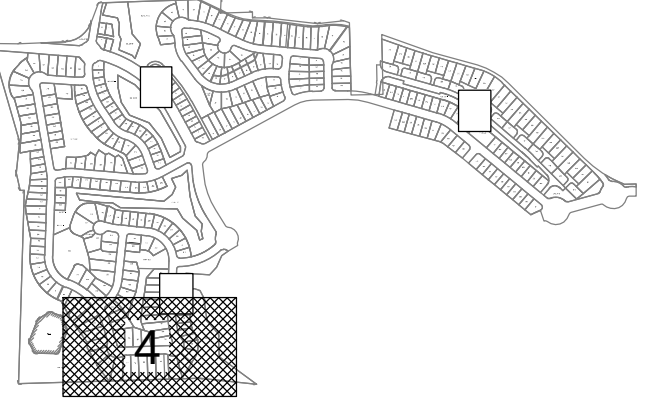


SHEET INDEX
NOT TO SCALE

**COUNTY OF SAN DIEGO TM 5572- RPL1
IMPLEMENTING TM LANDSCAPE CONCEPT PLAN FOR:**

LILAC HILL RANCH

PARTIAL PHOTOMETRICS SHEET #4

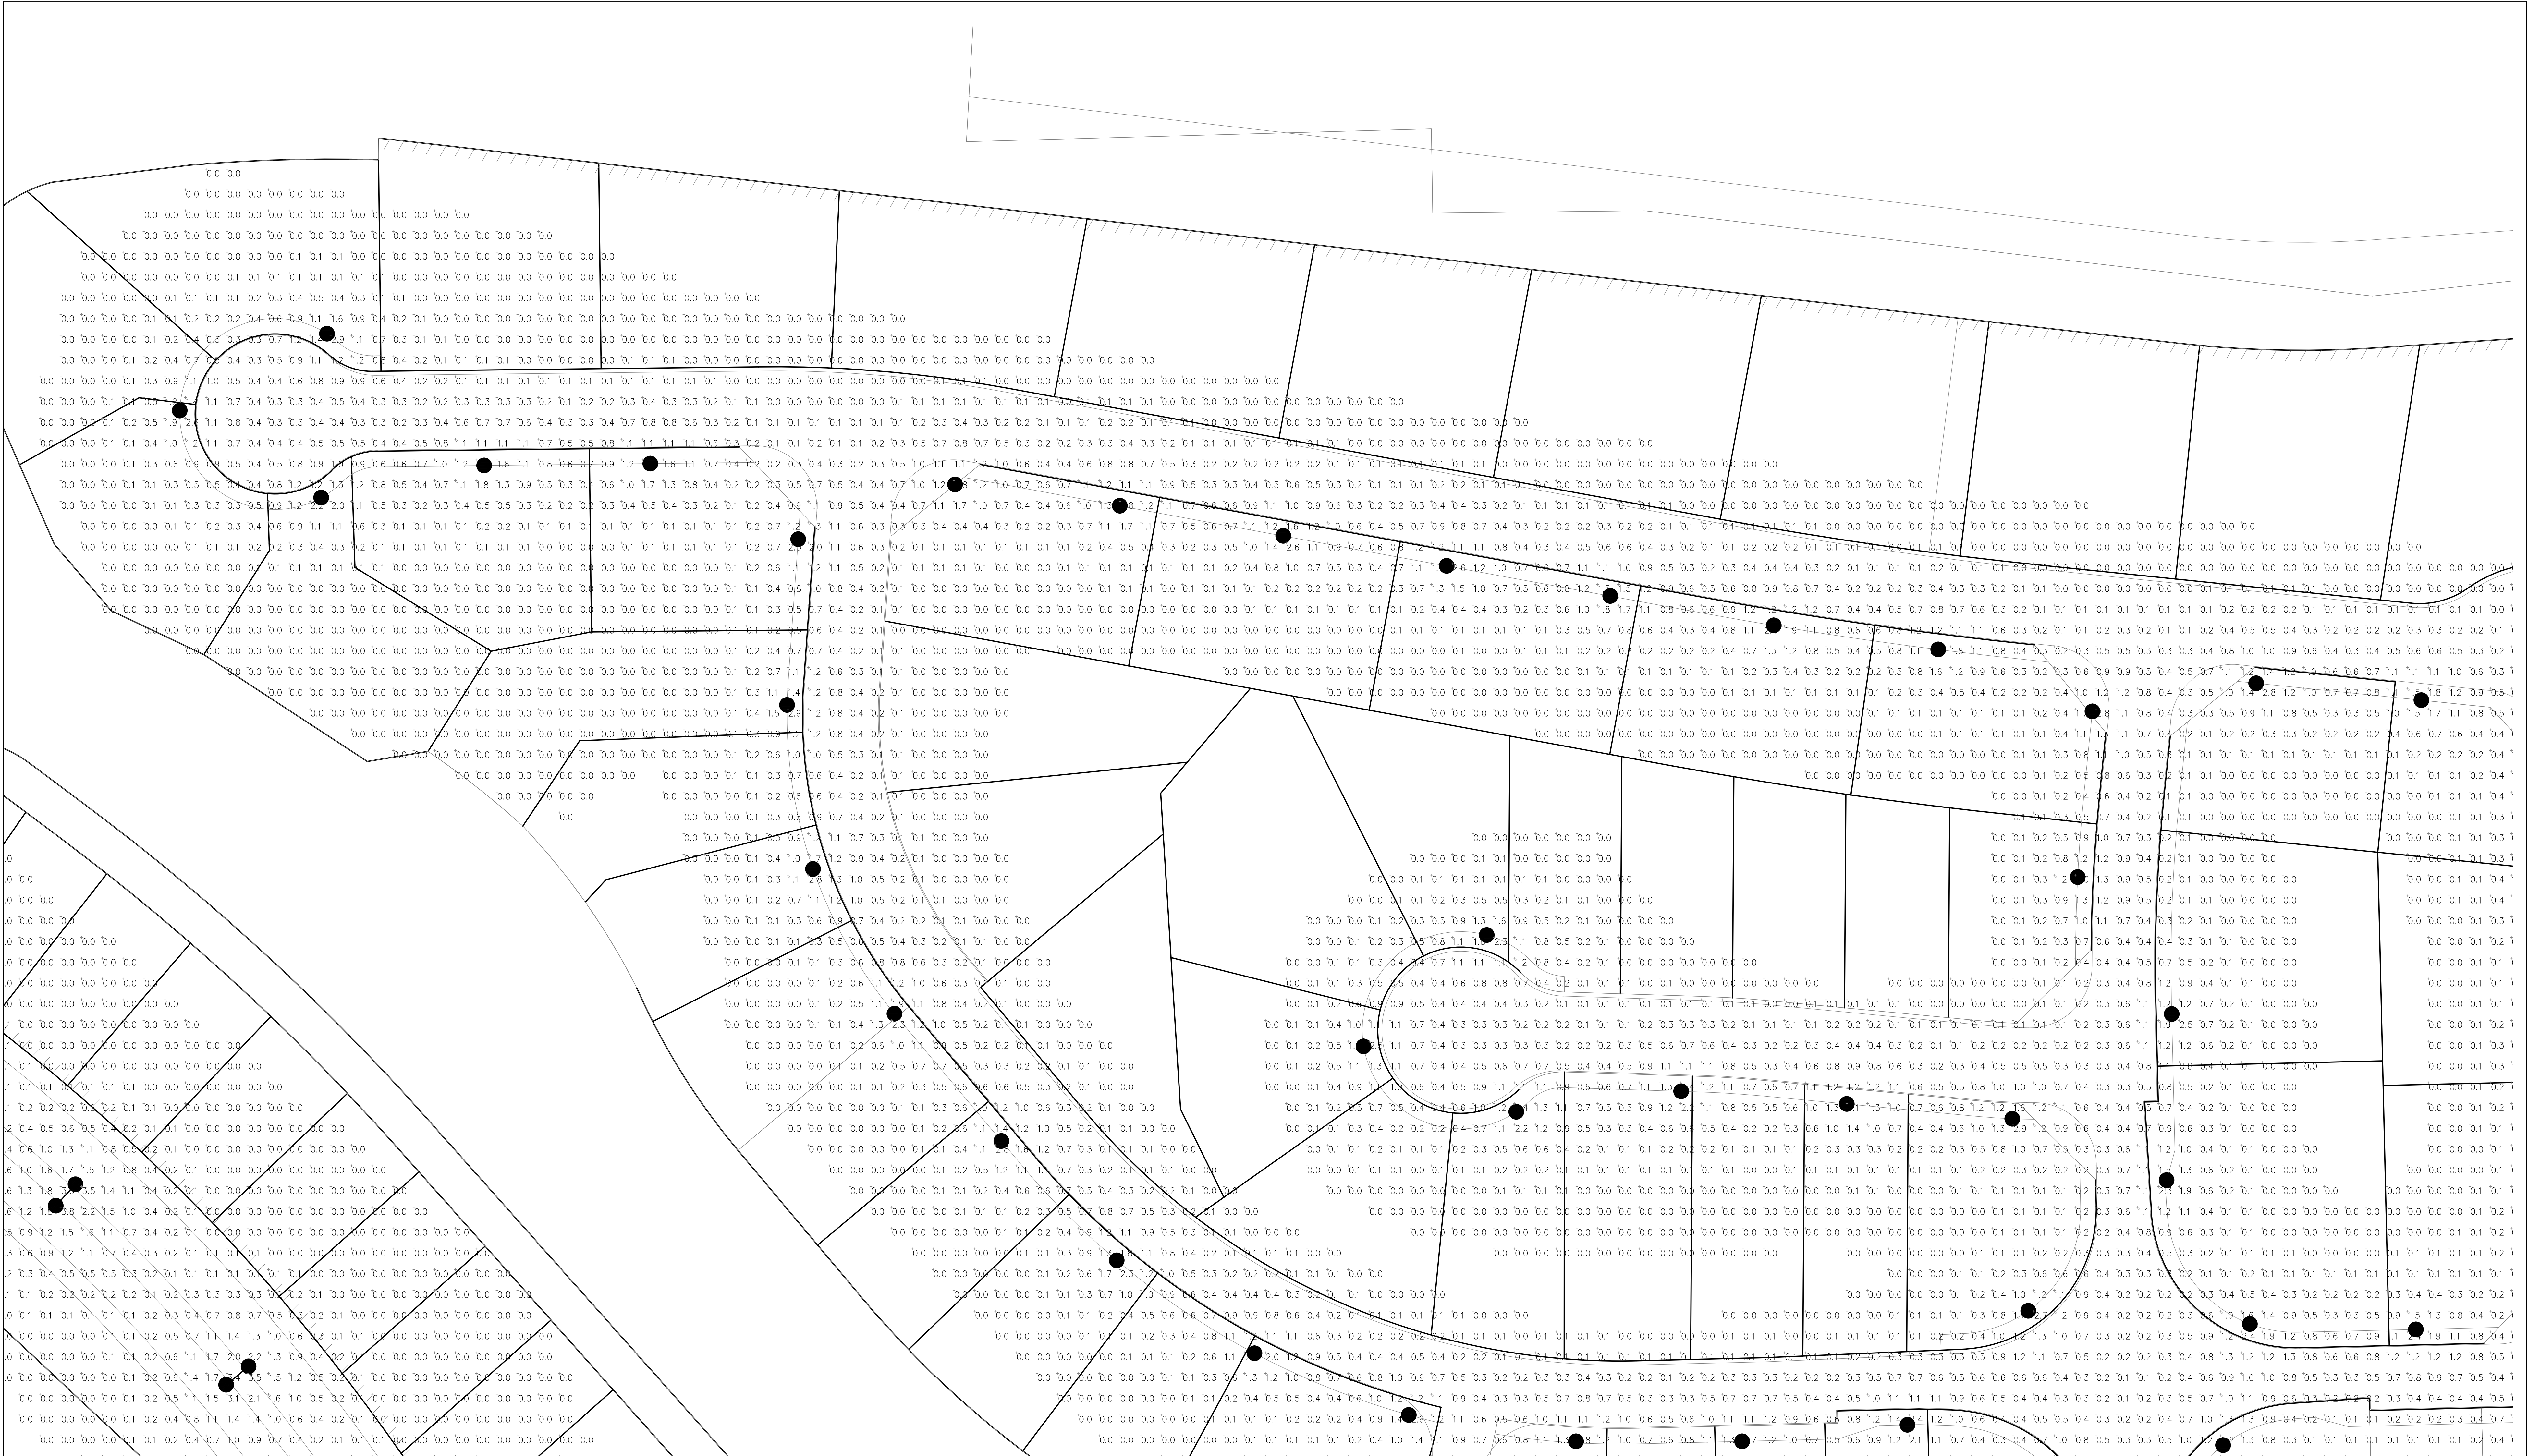


PARTIAL PHOTOMETRICS SHEET #5
SCALE: 1"=30'-0"




TURPIN & RATTAN
ENGINEERING, INC.
CONSULTING ENGINEERS
4719 PALM AVENUE
LA MESA, CA 91941-5221
619 / 486 - 6224 FAX 408 / 6233
E-MAIL: ENGINEER@TREISO.COM

TREI # 11348.01
6/10/04 02/14/13 5:39PM
011111548013480RPL111348.01_SHT 5-13_Photometrics.dwg

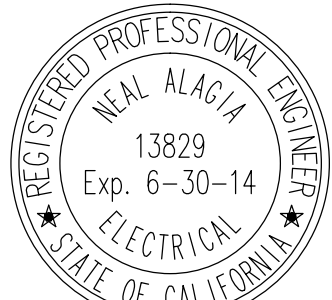

Wimmer
Yamada
and
Caughy

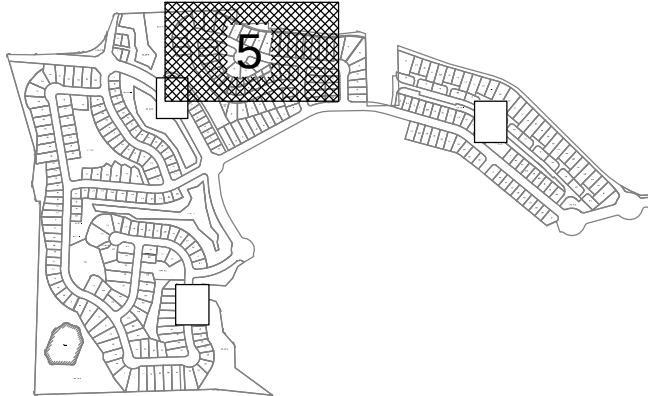


SHEET INDEX
NOT TO SCALE

COUNTY OF SAN DIEGO TM 5572- RPL1
IMPLEMENTING TM LANDSCAPE CONCEPT PLAN FOR:


LILAC HILL RANCH

PARTIAL PHOTOMETRICS SHEET #5

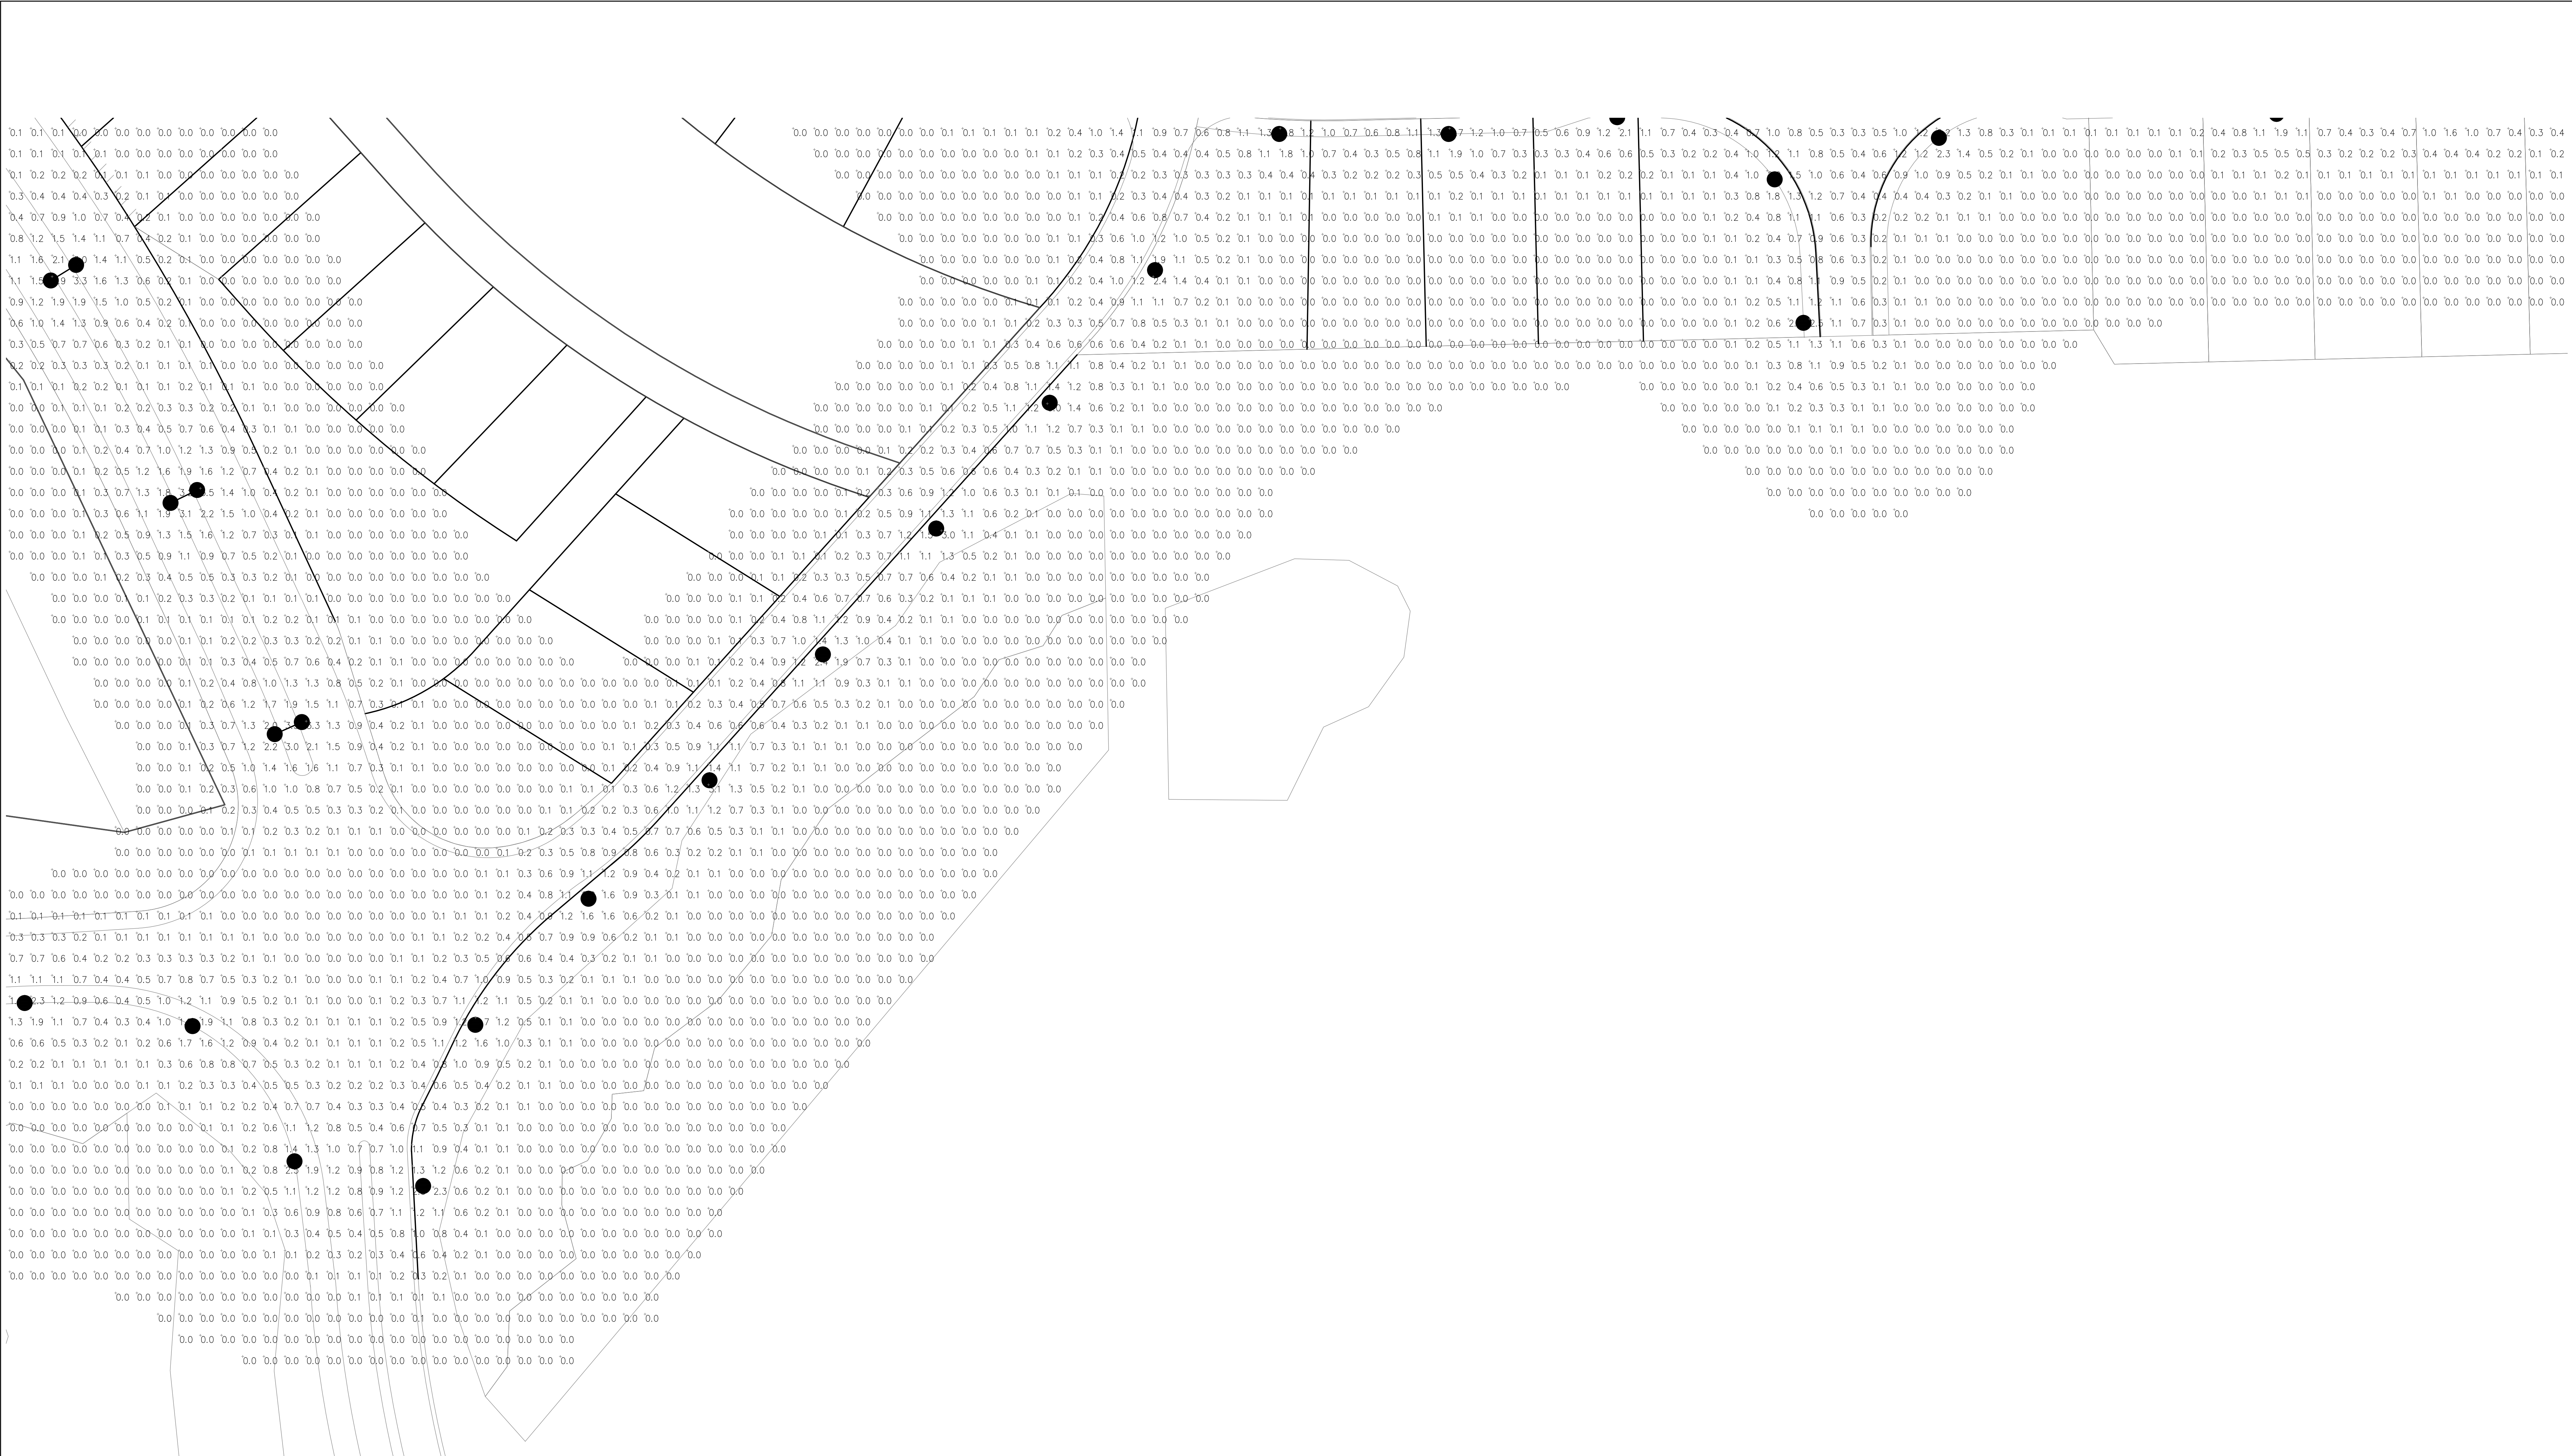


PARTIAL PHOTOMETRICS SHEET #6

 
SCALE: 1"=30'-0"



TURPIN & RATTAN
ENGINEERING, INC.
CONSULTING ENGINEERS
4719 PALM AVENUE
LA MESA, CA 91941-5221
619 / 486-6224 FAX 486-6233
E-MAIL: ENGINEER@TRFEB.COM
TREI # 11348.01
6/10/13 02/14/13 0:30PM
01111154801ACADPREP11348.01_SHT 6-13_Photometrics.dwg

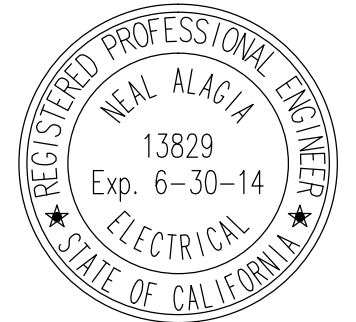

**Wimmer
Yamada
and
Caughey**

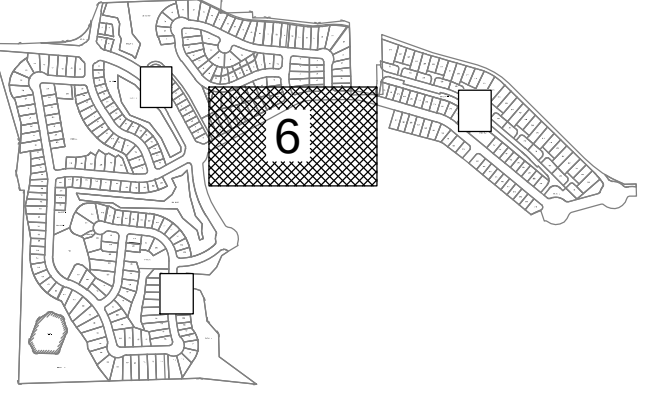


SHEET INDEX
NOT TO SCALE

COUNTY OF SAN DIEGO TM 5572- RPL1
IMPLEMENTING TM LANDSCAPE CONCEPT PLAN FOR:

LILAC HILL RANCH

PARTIAL PHOTOMETRICS SHEET #6

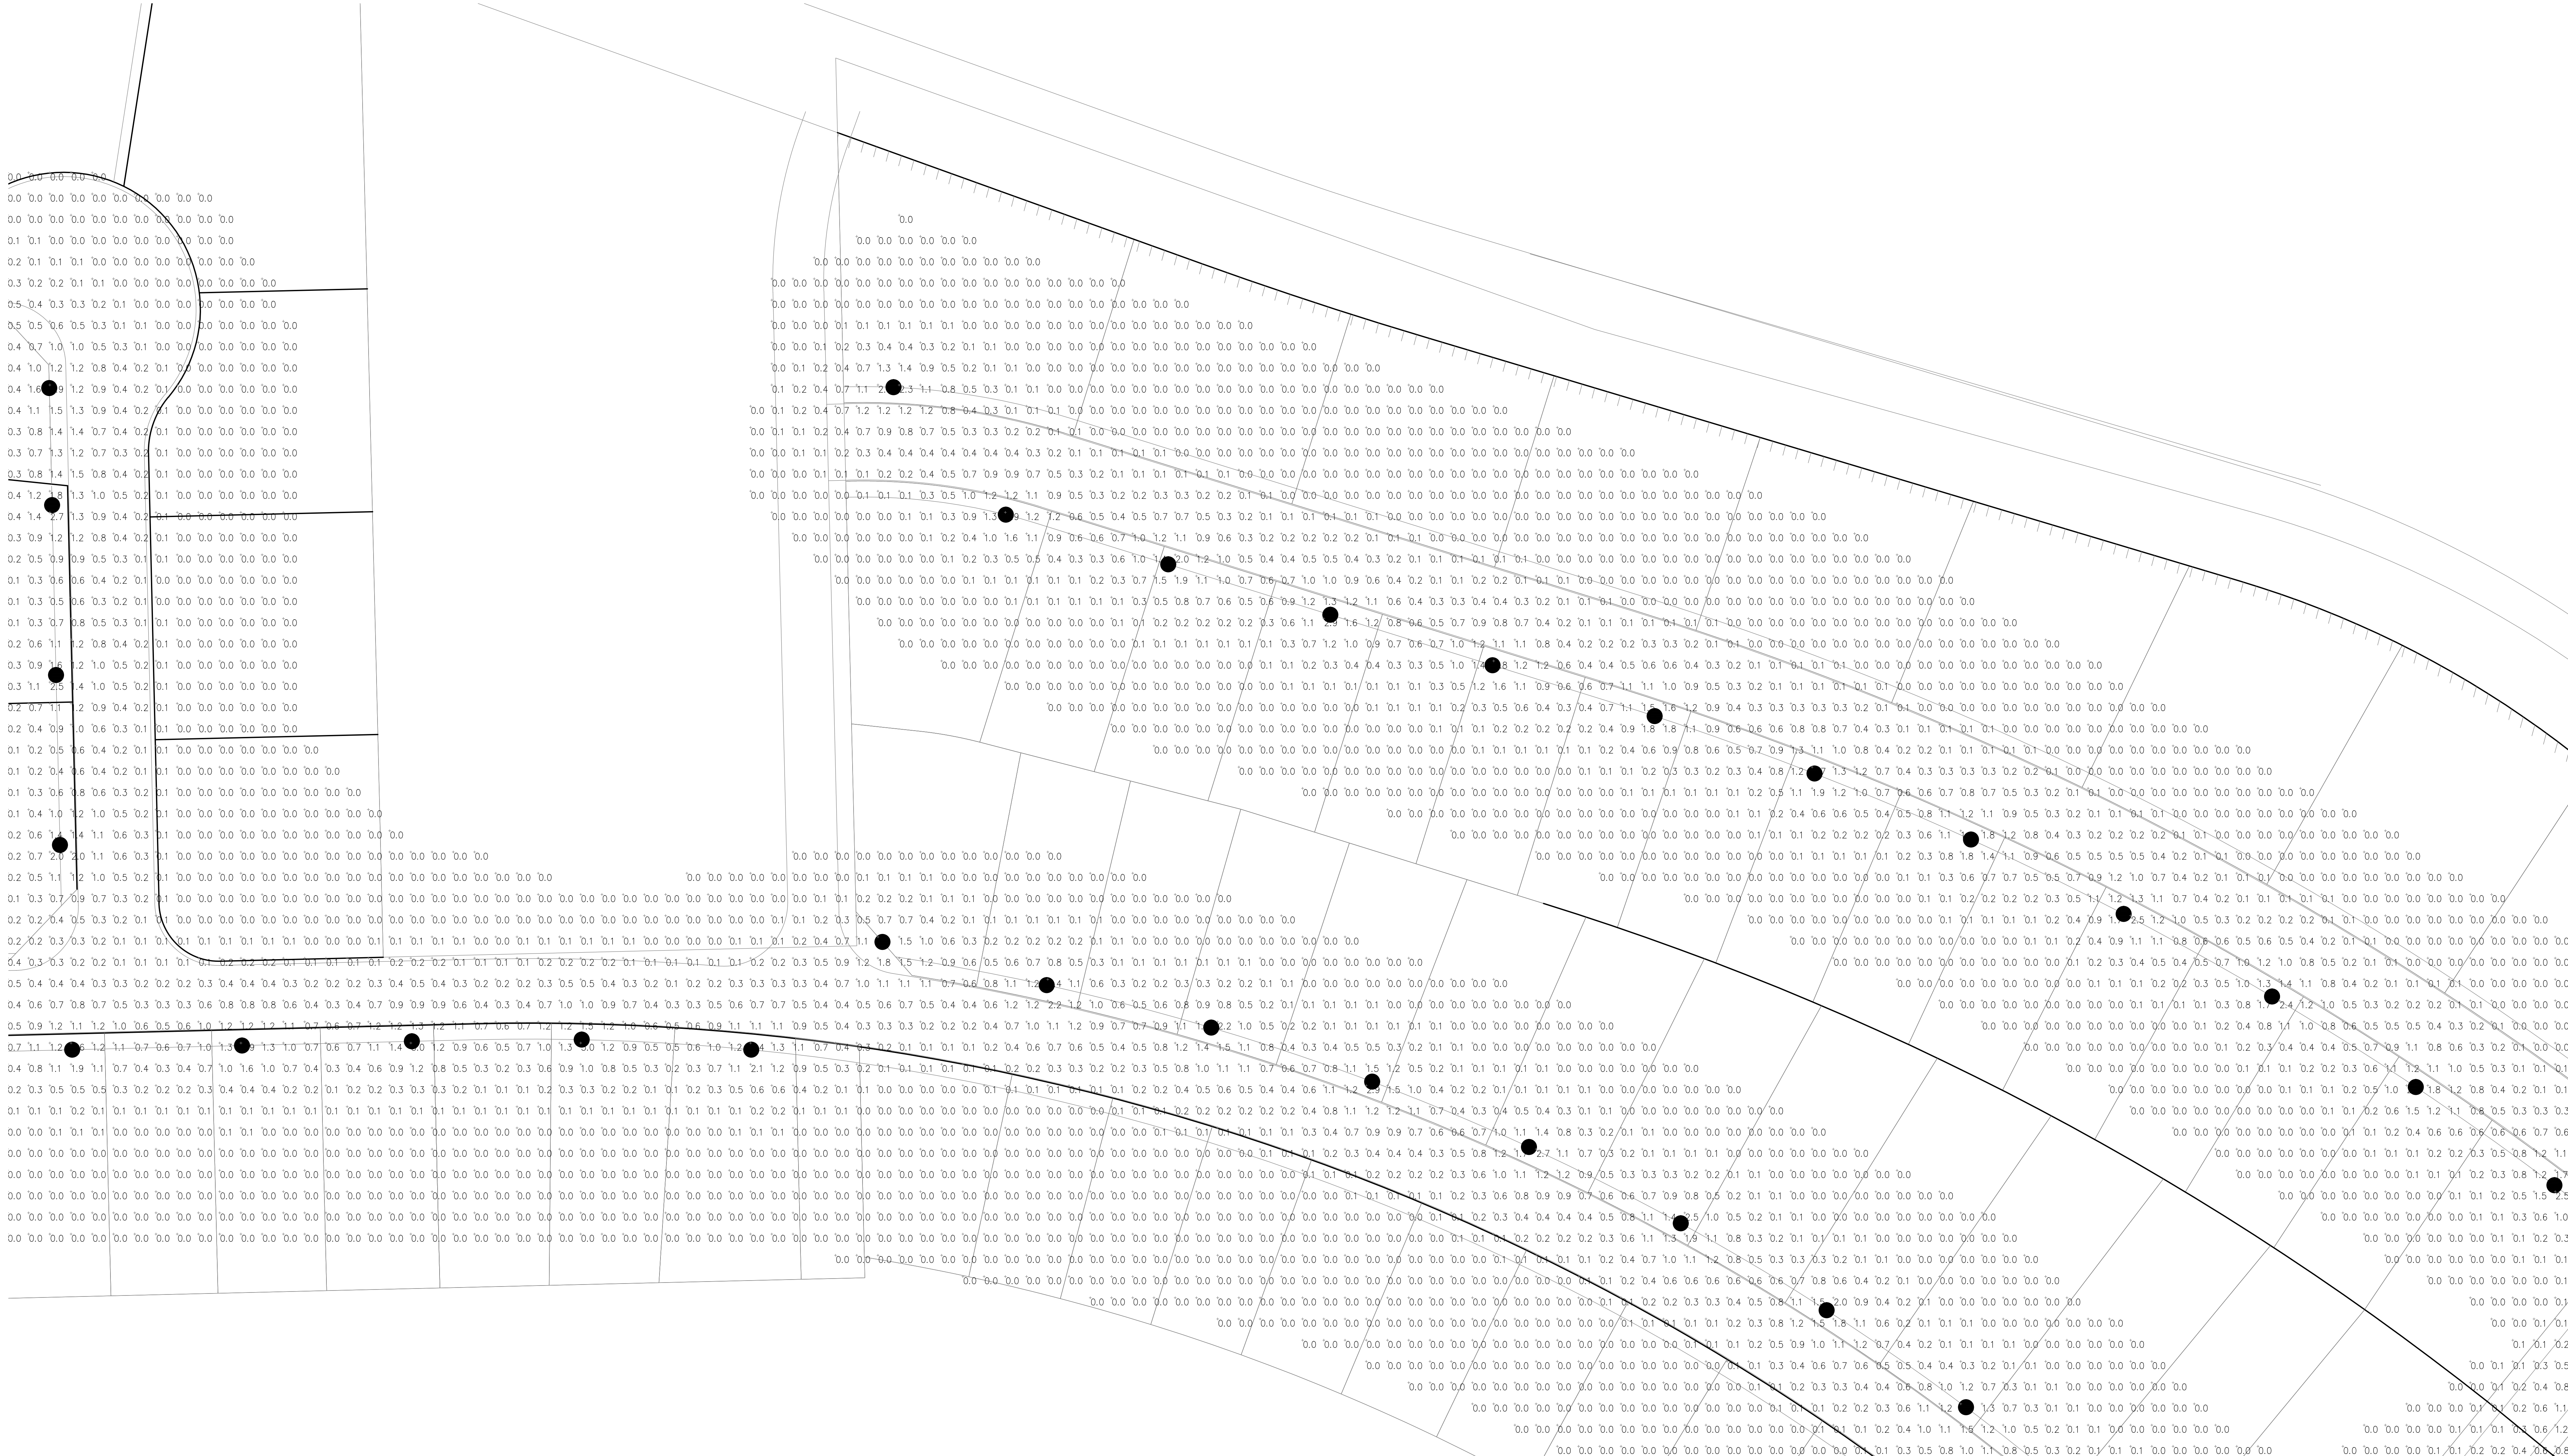

PARTIAL PHOTOMETRICS SHEET #7

SCALE: 1"=30'-0"




TURPIN & RATTAN
ENGINEERING, INC.
CONSULTING ENGINEERS
4719 PALM AVENUE
LA MESA, CA 91941-5221
619 / 486-6224 FAX 486-6233
E-MAIL: ENGINEER@TREISO.COM

TREI # 11348.01
6/19/02/14/15 5:30PM
01111154801ACADPHOT11348.01_SHT 6-13_Photometrics.dwg



**Wimmer
Yamada
and
Caughy**

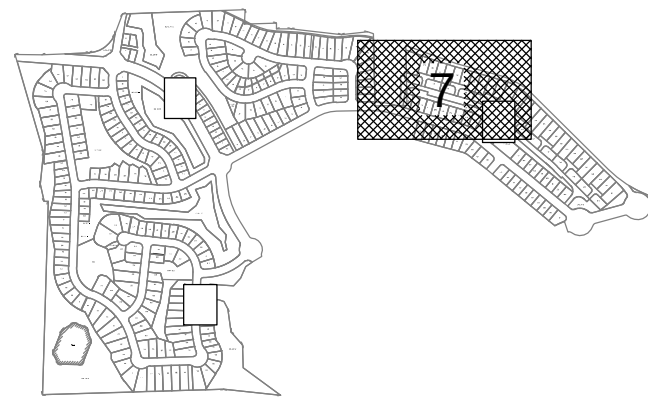


SHEET INDEX
NOT TO SCALE


COUNTY OF SAN DIEGO TM 5572- RPL1
IMPLEMENTING TM LANDSCAPE CONCEPT PLAN FOR:

LILAC HILL RANCH

PARTIAL PHOTOMETRICS SHEET #7

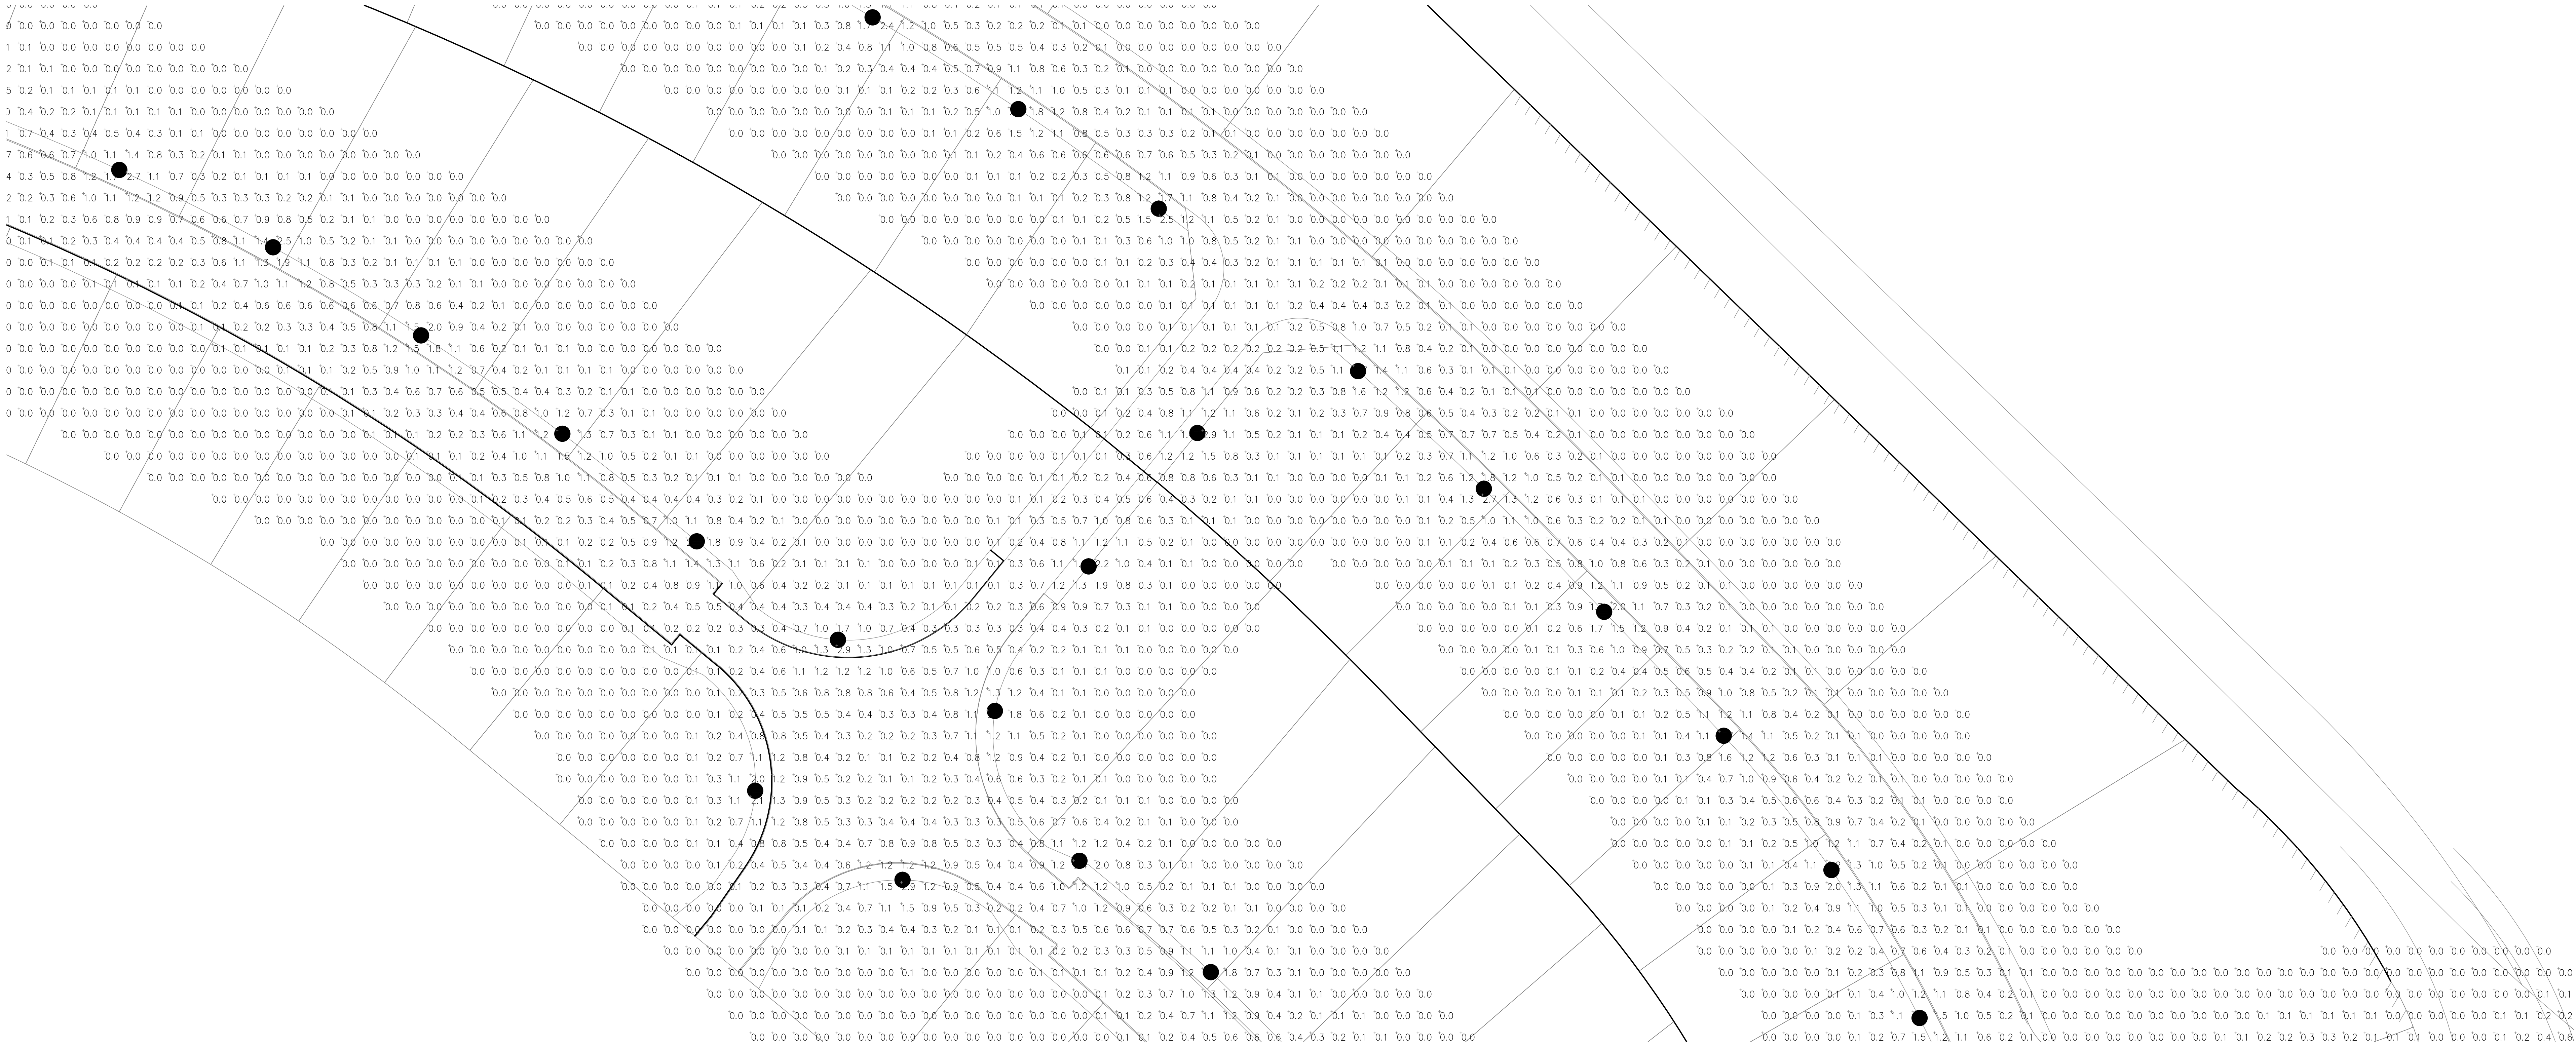


PARTIAL PHOTOMETRICS SHEET #8
SCALE: 1"=30'-0"

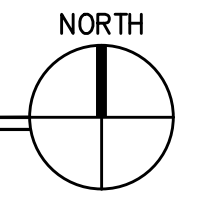

TURPIN & RATTAN
ENGINEERING, INC.
CONSULTING ENGINEERS
4719 PALM AVENUE
LA MESA, CA 91941-5221
619 / 486-1624 FAX 486-1623
E-MAIL: ENGINEER@TREISO.COM
TREI # 11348.01
6/20/04 02:14:13 5:39PM
D:\11\11548\01\ACAD\PHOTO\11348.01_SHT 8-13_Photometrics.dwg



**Wimmer
Yamada
and
Caughy**

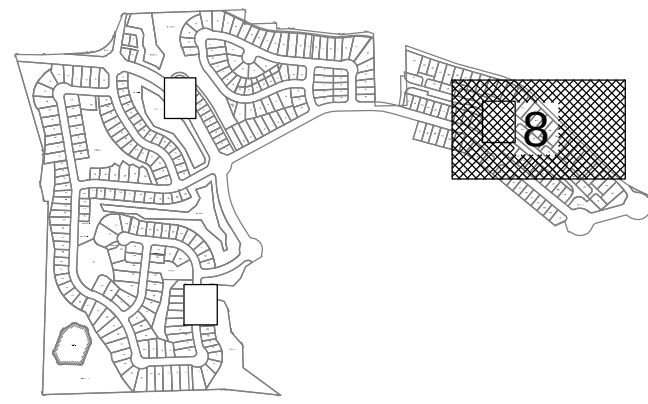


COUNTY OF SAN DIEGO TM 5572- RPL1
IMPLEMENTING TM LANDSCAPE CONCEPT PLAN FOR:

LILAC HILL RANCH

PARTIAL PHOTOMETRICS SHEET #8

SHEET NO. 13 OF 14

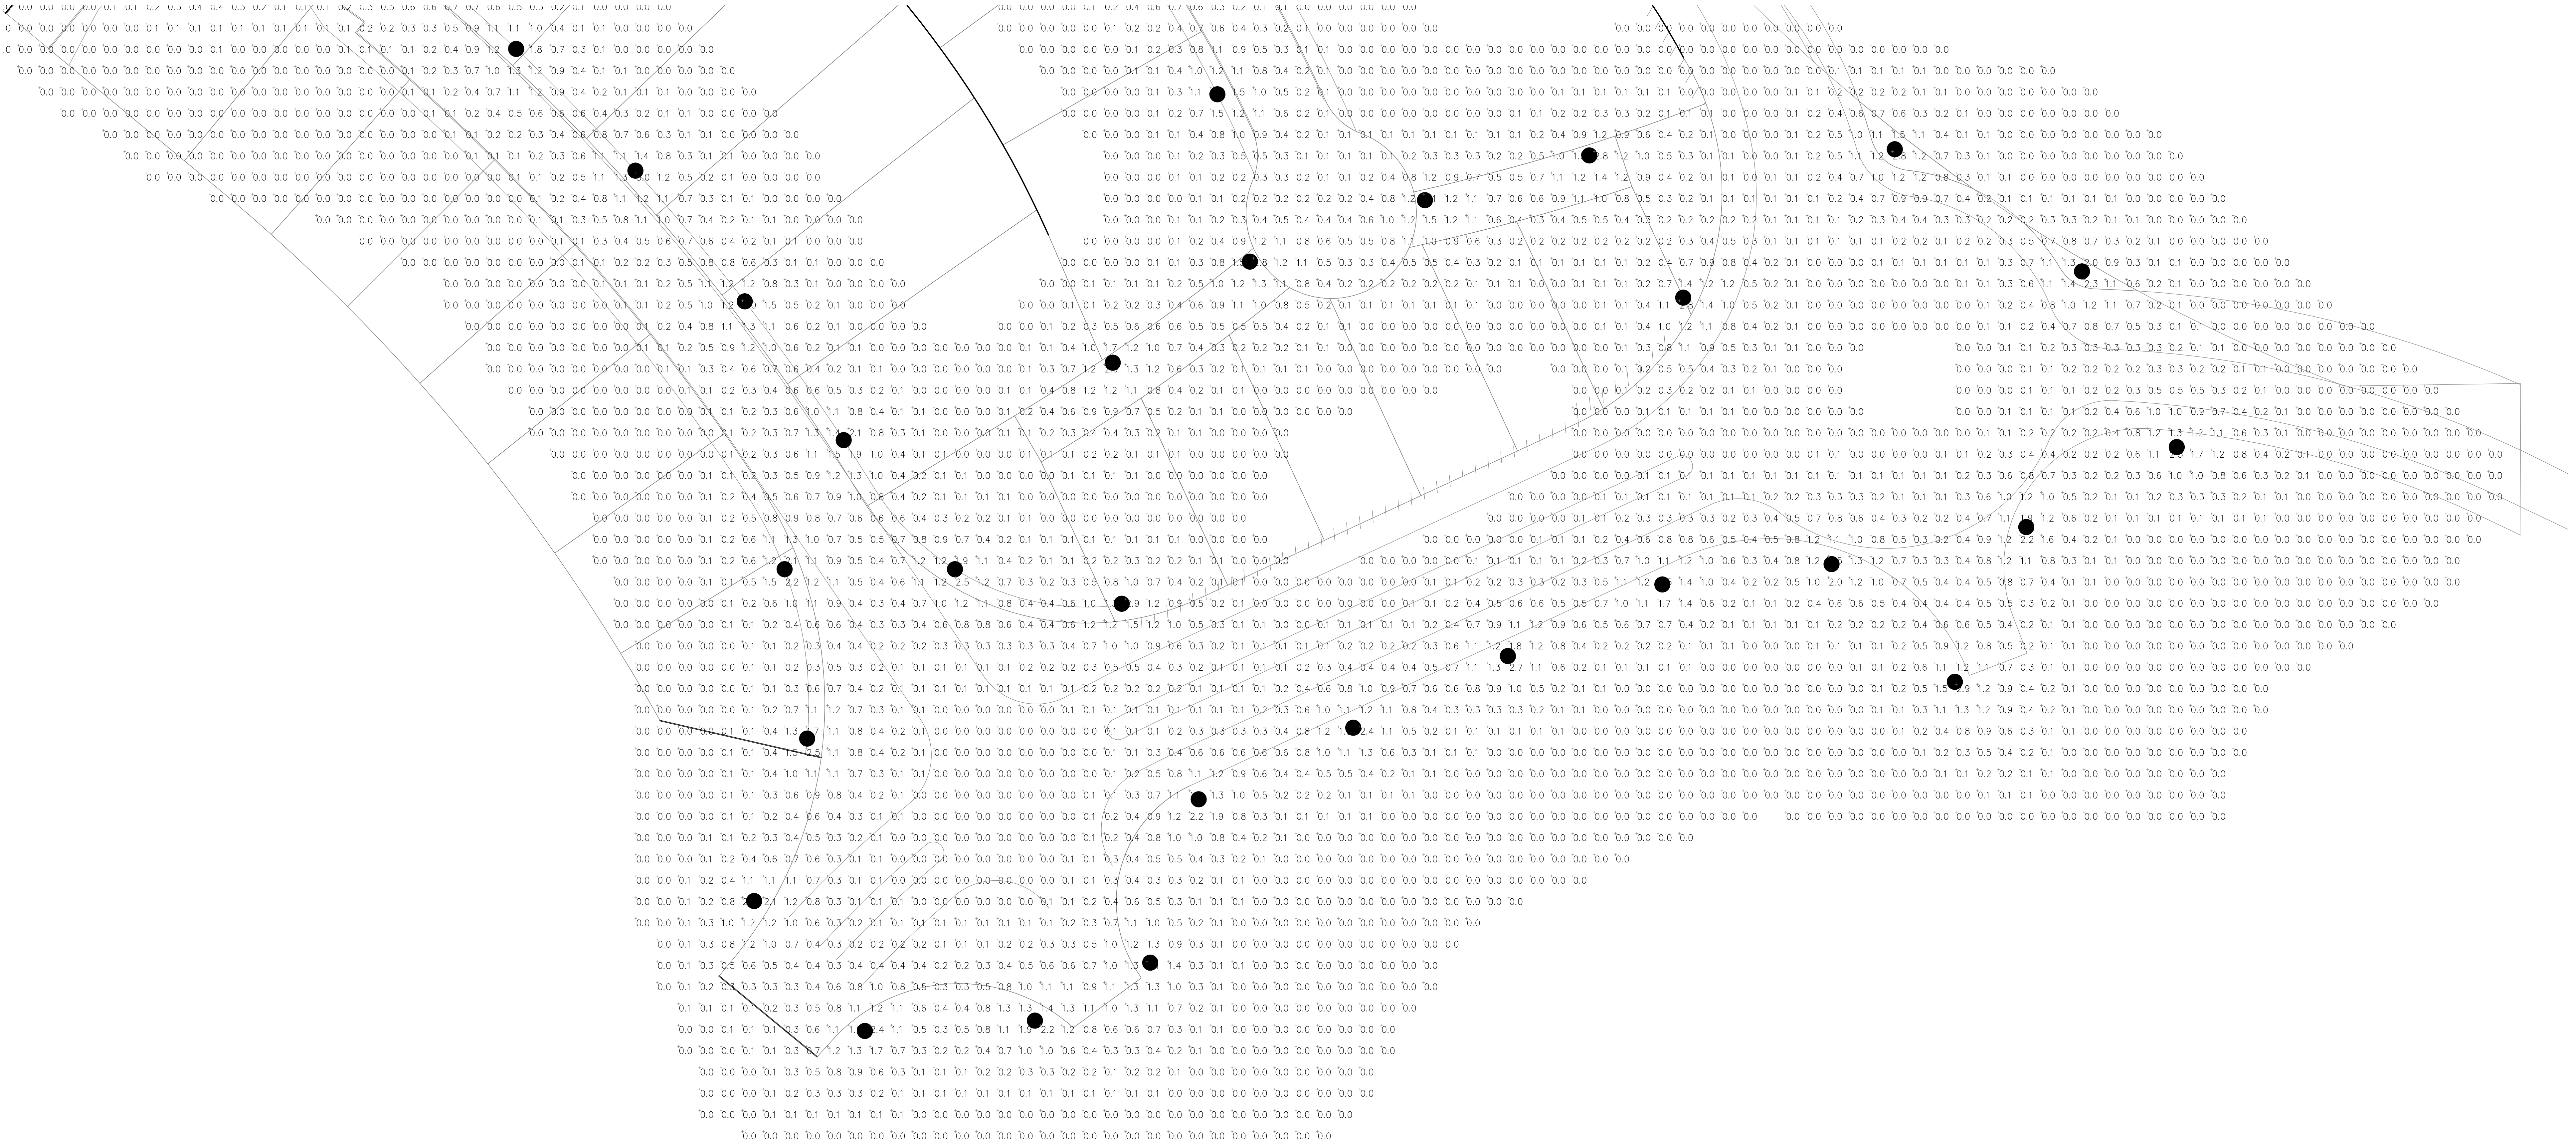


PARTIAL PHOTOMETRICS SHEET #9

SCALE: 1"=30'-0"




TURPIN & RATTAN
ENGINEERING, INC.
CONSULTING ENGINEERS
4719 PALM AVENUE
LA MESA, CA 91941-5221
619 / 486-6224 FAX 486-6233
E-MAIL: ENGINEER@TREISO.COM

TREI # 11348.01

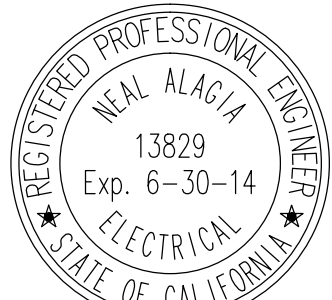

**Wimmer
Yamada
and
Caughy**

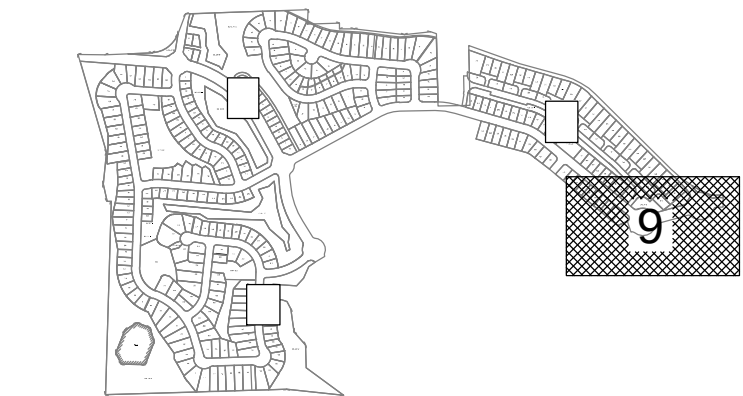

SHEET INDEX
NOT TO SCALE

COUNTY OF SAN DIEGO TM 5572- RPL1
IMPLEMENTING TM LANDSCAPE CONCEPT PLAN FOR:

LILAC HILL RANCH

PARTIAL PHOTOMETRICS SHEET #9

SHEET NO. 14 OF 14