



COUNTY OF SAN DIEGO TRACT 5572-RPL1
PHOTOMETRIC DESIGN CONCEPT
LILAC HILLS RANCH

VICINITY MAP

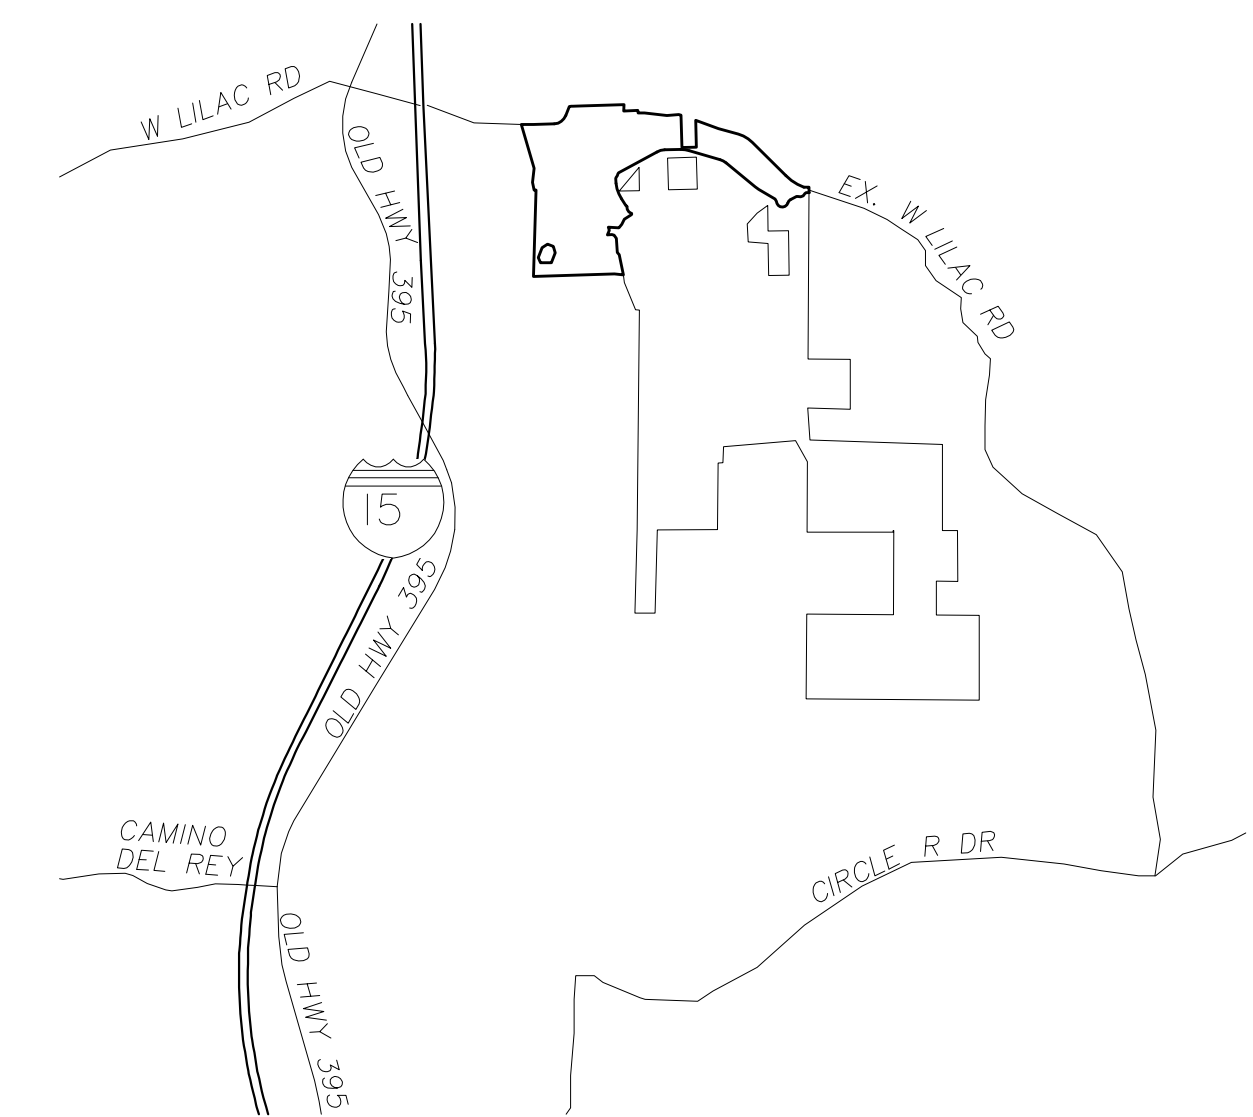

PHOTOMETRIC CONCEPT SHEET INDEX

SHEETS	PLANS
T-1	PHOTOMETRIC CONCEPTUAL TITLE SHEET
1-2	PARTIAL STREET LIGHTING
3	LIGHT FIXTURE SCHEDULE
4-5	PARK LIGHTING PLANS
6-14	PARTIAL PHOTOMETRICS

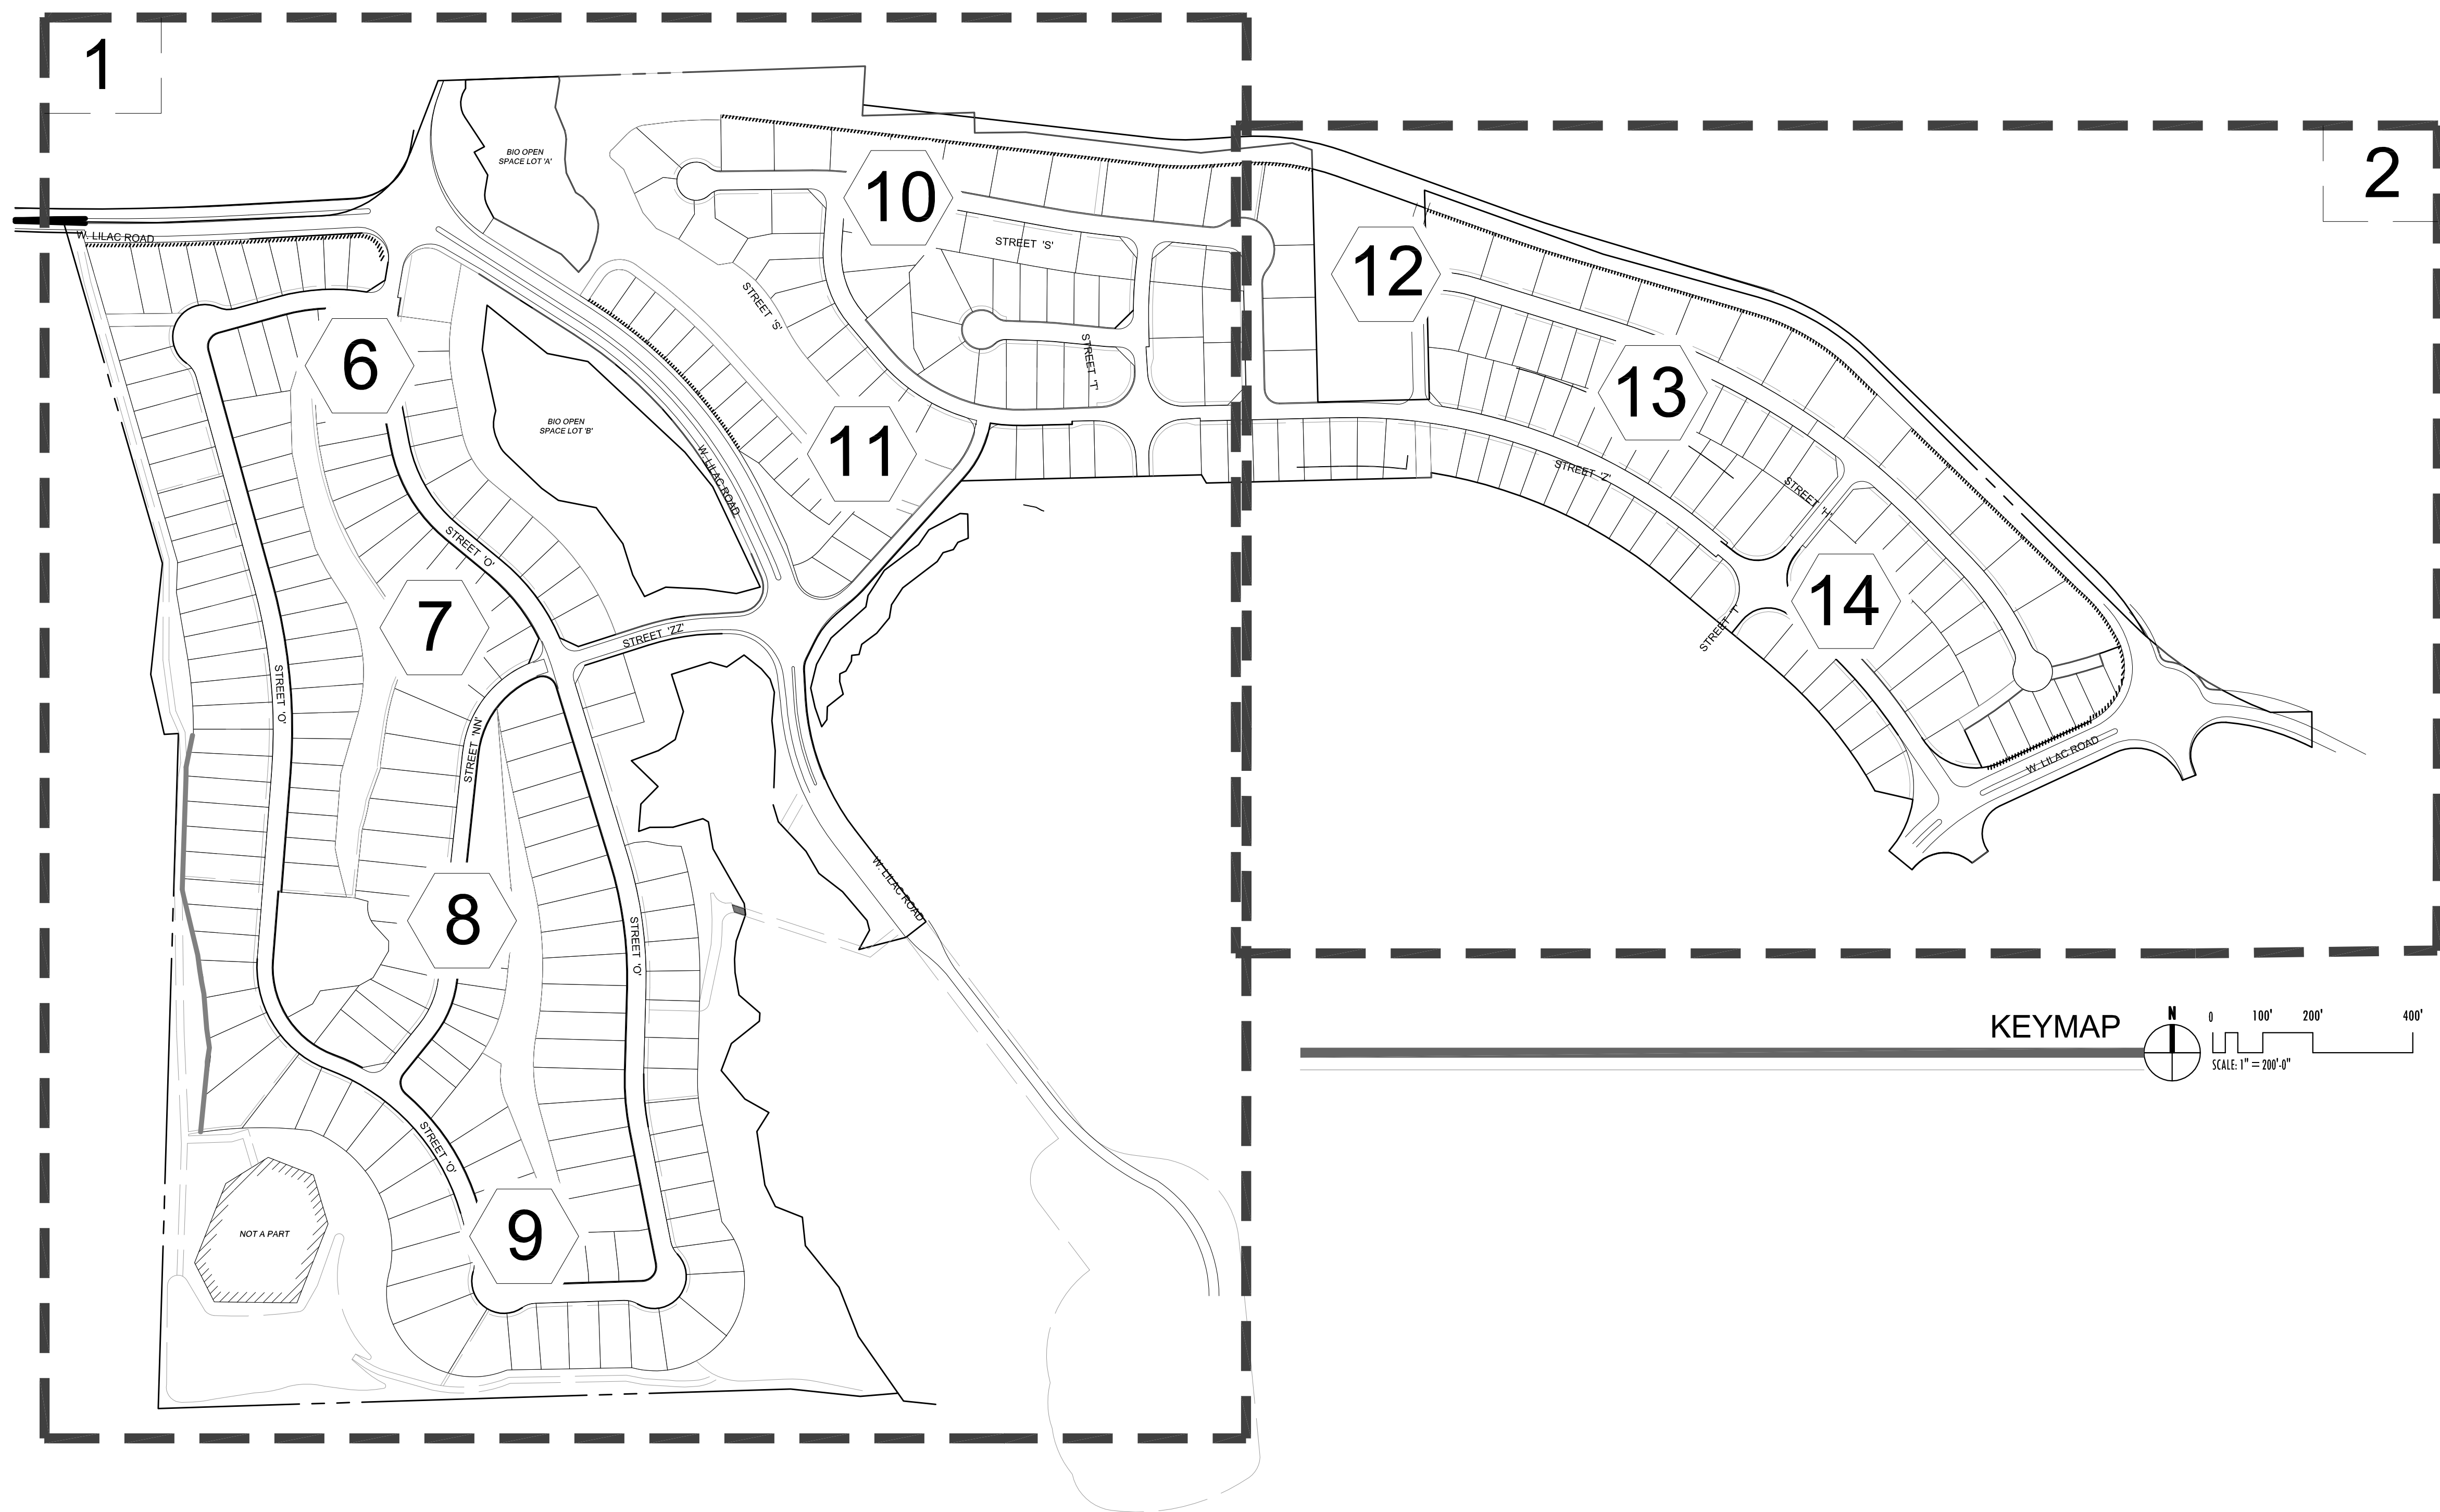

TURPIN & RATTAN
ENGINEERING, INC.
CONSULTING ENGINEERS
4719 PALM AVENUE
LA MESA, CA 91941-5221
619 / 466 / 6224 FAX 666 / 6233
E-MAIL: ENGINEER@TRERO.COM
TREI # 11348.00
E-FILED 05/21/12 5:03PM
S-1111348-00-CA-CDREG-11348.00_SHT 1-2 STREET LIGHTING.dwg

Wimmer
Yamada
and
Caughey

Landscape Architecture | Environmental Planning
3067 Fifth Avenue, San Diego, California 92103-1840
T 619.232.4004 F 619.232.0640 www.wyac.com

PREPARED BY:

LANDMARK
C. G. N. S. U. L. T. I. N. G.
Planning Engineering Surveying
8505 Carmichael Avenue, Suite 200
San Diego, CA 92121 (619) 581-6070

COUNTY OF SAN DIEGO TM 5572-RPL1

LILAC HILL RANCH

PHOTOMETRIC TITLE SHEET

T-1




- LEGEND**
- SINGLE ARM POLE/FIXTURE TYPE 'A' AT ±80'-0" ON CENTER.
 - DOUBLE ARM POLE/FIXTURES TYPE 'A' AT ±120'-0" ON CENTER.
 - ⊠ BOLLARD TYPE 'B' AT ±30'-0" ON CENTER.

- KEYNOTES**
- ① PROVIDE WP JUNCTION BOX SET FLUSH WITH FINISHED GRADE AND 20 AMP 480 VOLT POWER SOURCE FOR PRIMARY ENTRY MONUMENT (TYPICAL OF 2 LOCATIONS)


PARTIAL PHASE 1 STREET LIGHTING
SCALE: 1"=100'-0"



TURPIN & RATTAN
ENGINEERING, INC.
CONSULTING ENGINEERS
4719 PALM AVENUE
LA MESA, CA 91941-5221
P: 619 / 480-1624 FAX: 619 / 693-3333
E-MAIL: ENGINEER@TRISB.COM
TREI # 11348.01

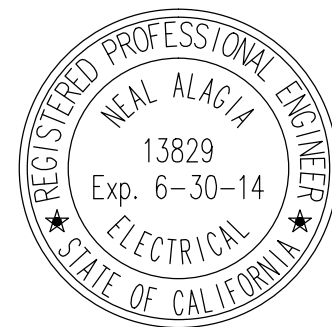

**Wimmer
Yamada
and
Caughy**

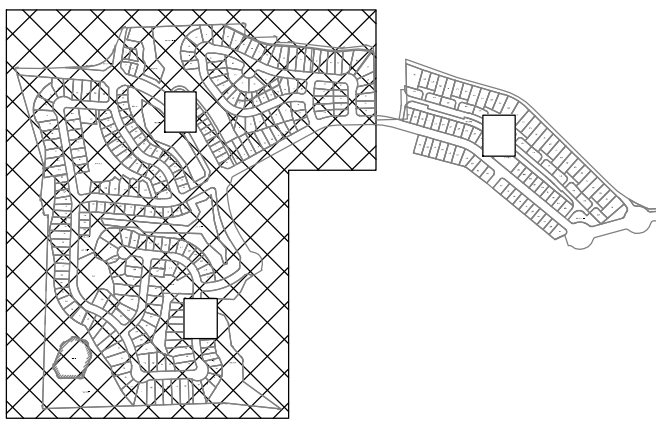


SHEET INDEX
NOT TO SCALE

COUNTY OF SAN DIEGO TM 5572-RPL1
IMPLEMENTING TM LANDSCAPE CONCEPT PLAN FOR:

LILAC HILL RANCH

PARTIAL PHASE 1 STREET LIGHTING

MATCH LINE. FOR CONTINUATION SEE SHEET 1

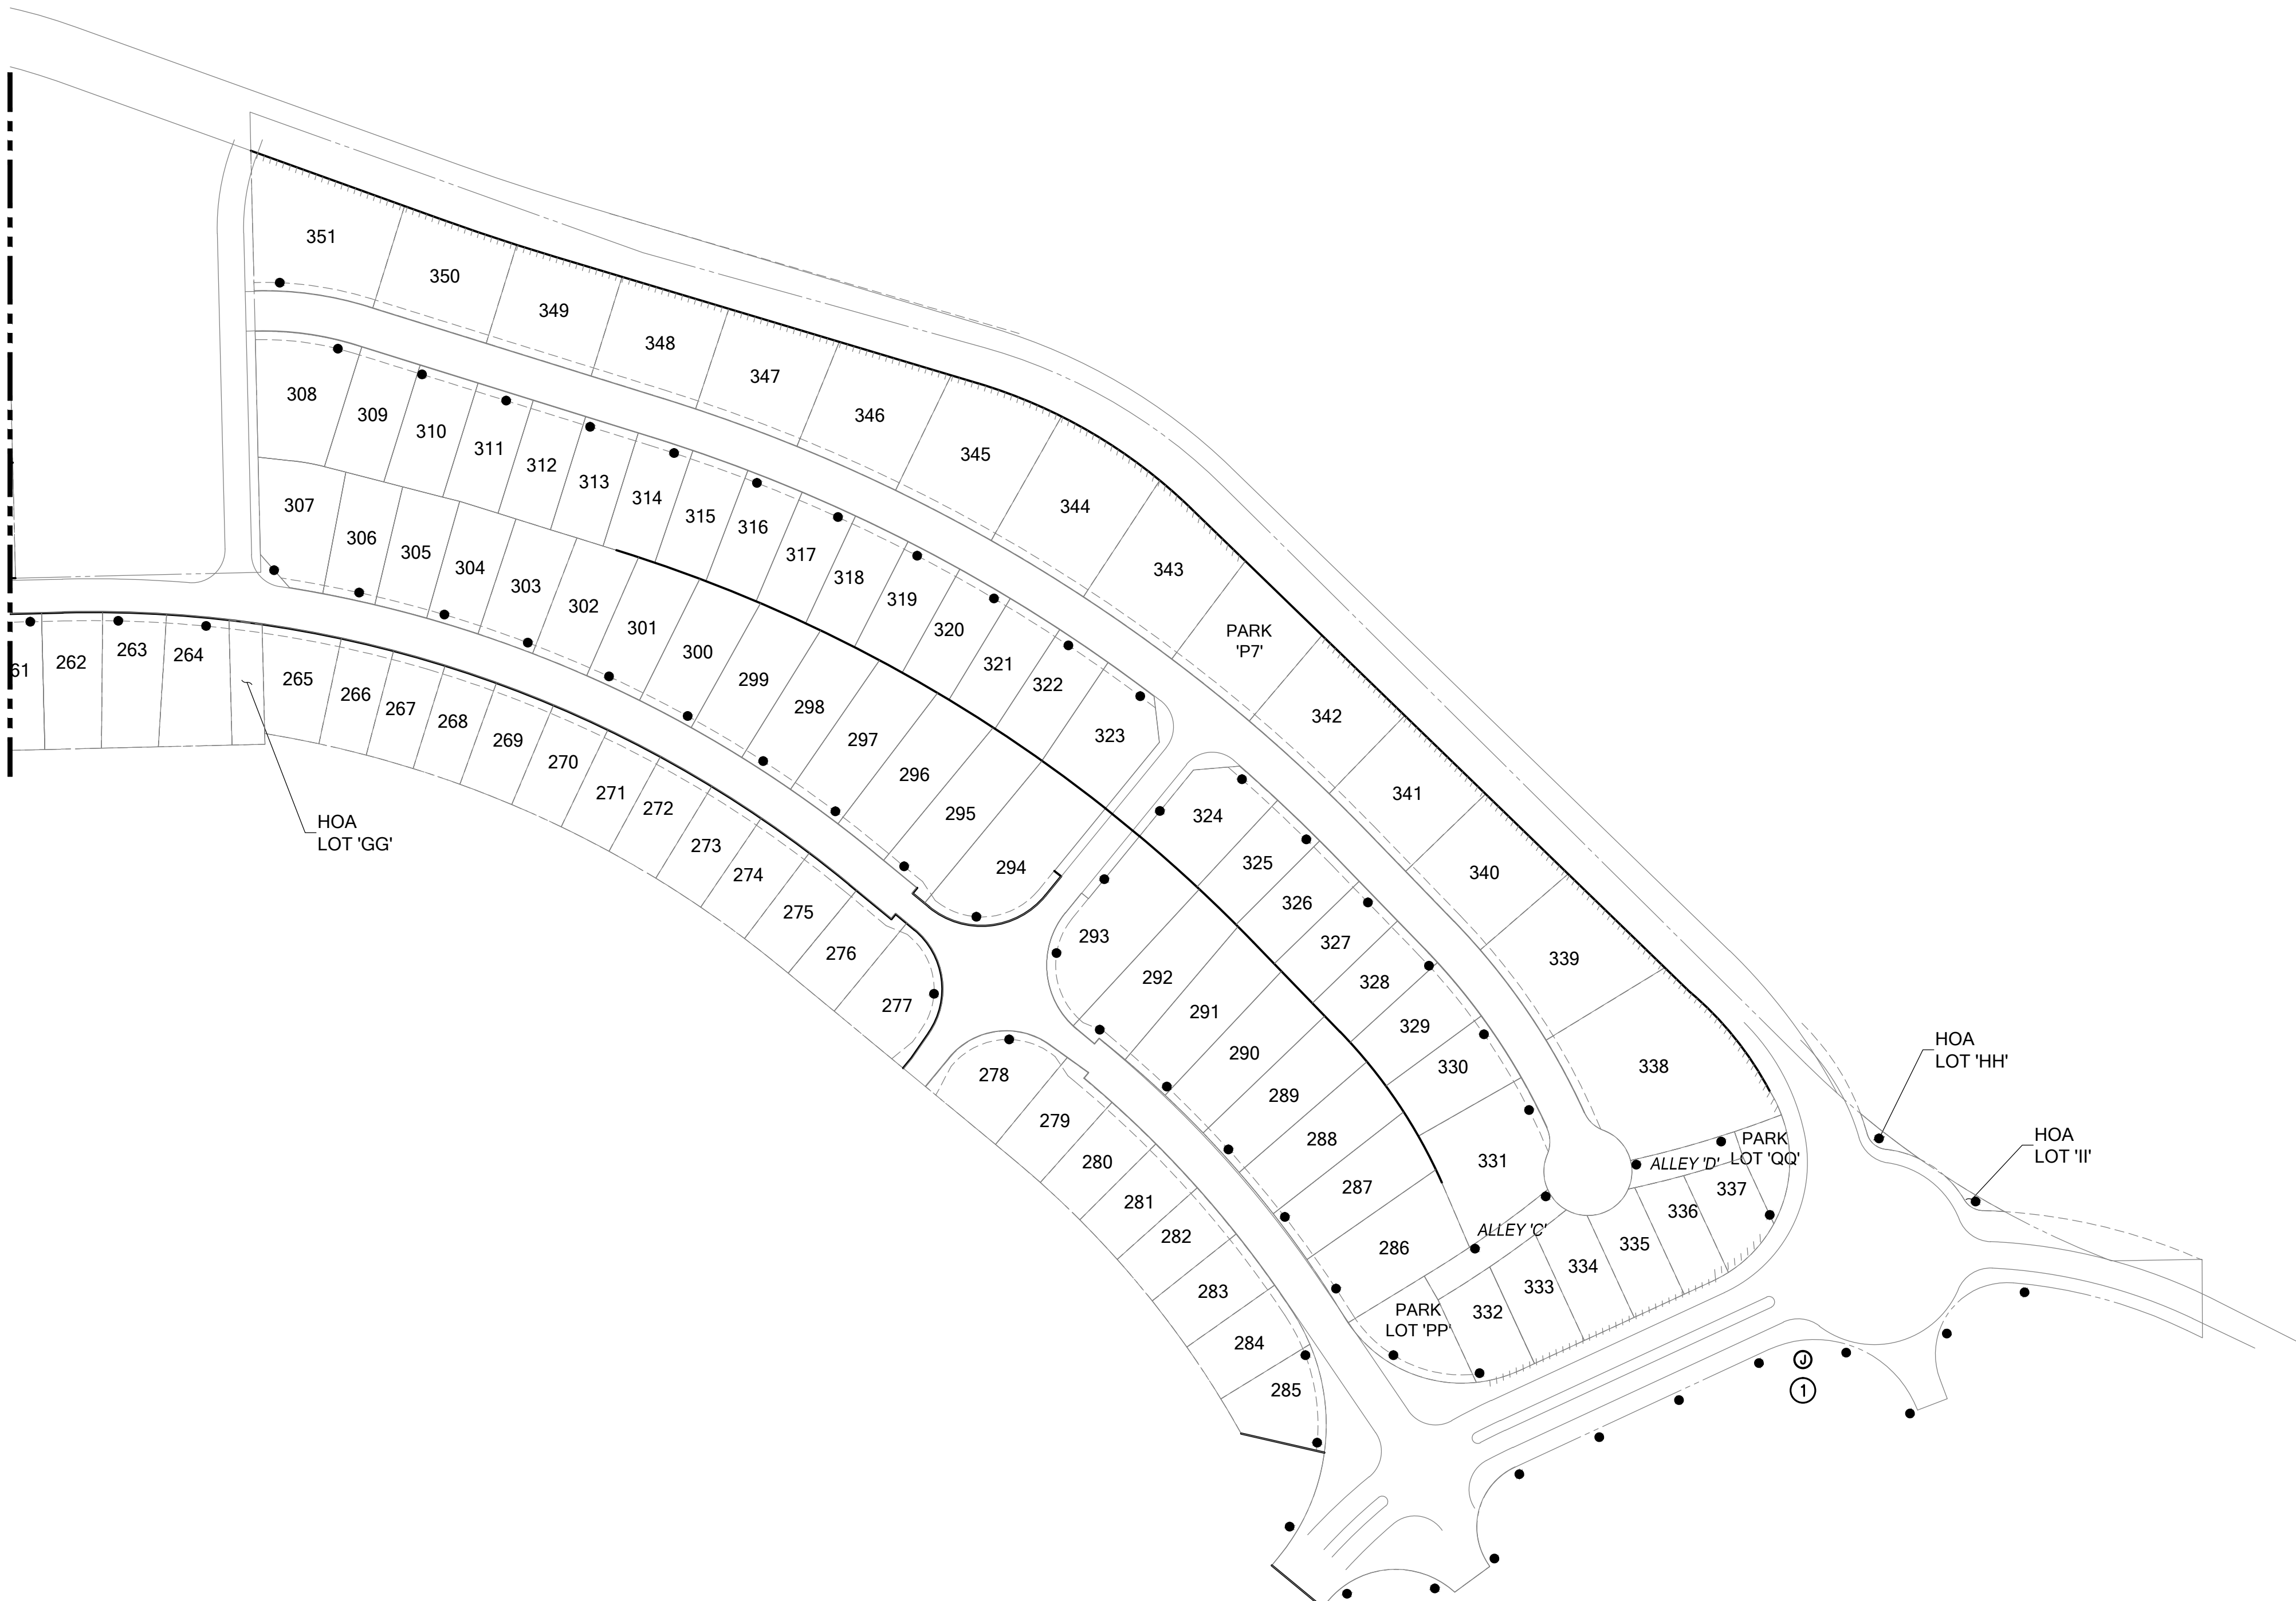

LEGEND



- SINGLE ARM POLE/FIXTURE TYPE 'A' AT ±80'-0" ON CENTER.
- DOUBLE ARM POLE/FIXTURES TYPE 'A' AT ±120'-0" ON CENTER.
- ⊠ BOLLARD TYPE 'B' AT ±30'-0" ON CENTER.

KEYNOTES

- ① PROVIDE WP JUNCTION BOX SET FLUSH WITH FINISHED GRADE AND 20 AMP 480 VOLT POWER SOURCE FOR PRIMARY ENTRY MONUMENT (TYPICAL OF 2 LOCATIONS)

PARTIAL PHASE 1 STREET LIGHTING

SCALE: 1"=100'-0"

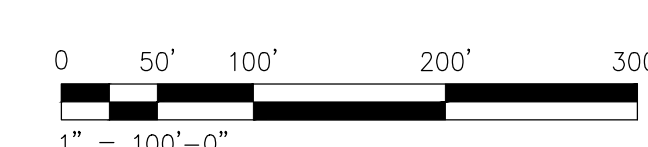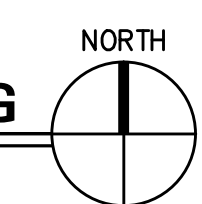

TURPIN & RATTAN
ENGINEERING, INC.
CONSULTING ENGINEERS
4719 PALM AVENUE
LA MESA, CA 91941-5221
619 / 450-1624 FAX 408 / 6233
E-MAIL: ENGINEER@TREISO.COM
TREI # 11348.01

Wimmer
Yamada
and
Caughey

LANDMARK
CONSULTING ENGINEERS
619 / 450-1624 FAX 408 / 6233
E-MAIL: ENGINEER@TREISO.COM

SHEET INDEX
NOT TO SCALE

COUNTY OF SAN DIEGO TM 5572- RPL1
IMPLEMENTING TM LANDSCAPE CONCEPT PLAN FOR:
LILAC HILL RANCH

PARTIAL PHASE 1 STREET LIGHTING

SHEET NO. 2 OF 14

FIXTURE TYPE 'A'
NO SCALE



FIXTURE TYPE 'B'

NO SCALE


Wimmer
Yamada
and
Caughey

COUNTY OF SAN DIEGO TM 5572- RPL1
IMPLEMENTING TM LANDSCAPE CONCEPT PLAN FOR:


LILAC HILL RANCH

LIGHT FIXTURE SCHEDULE


SHEET NO. 3 OF 14

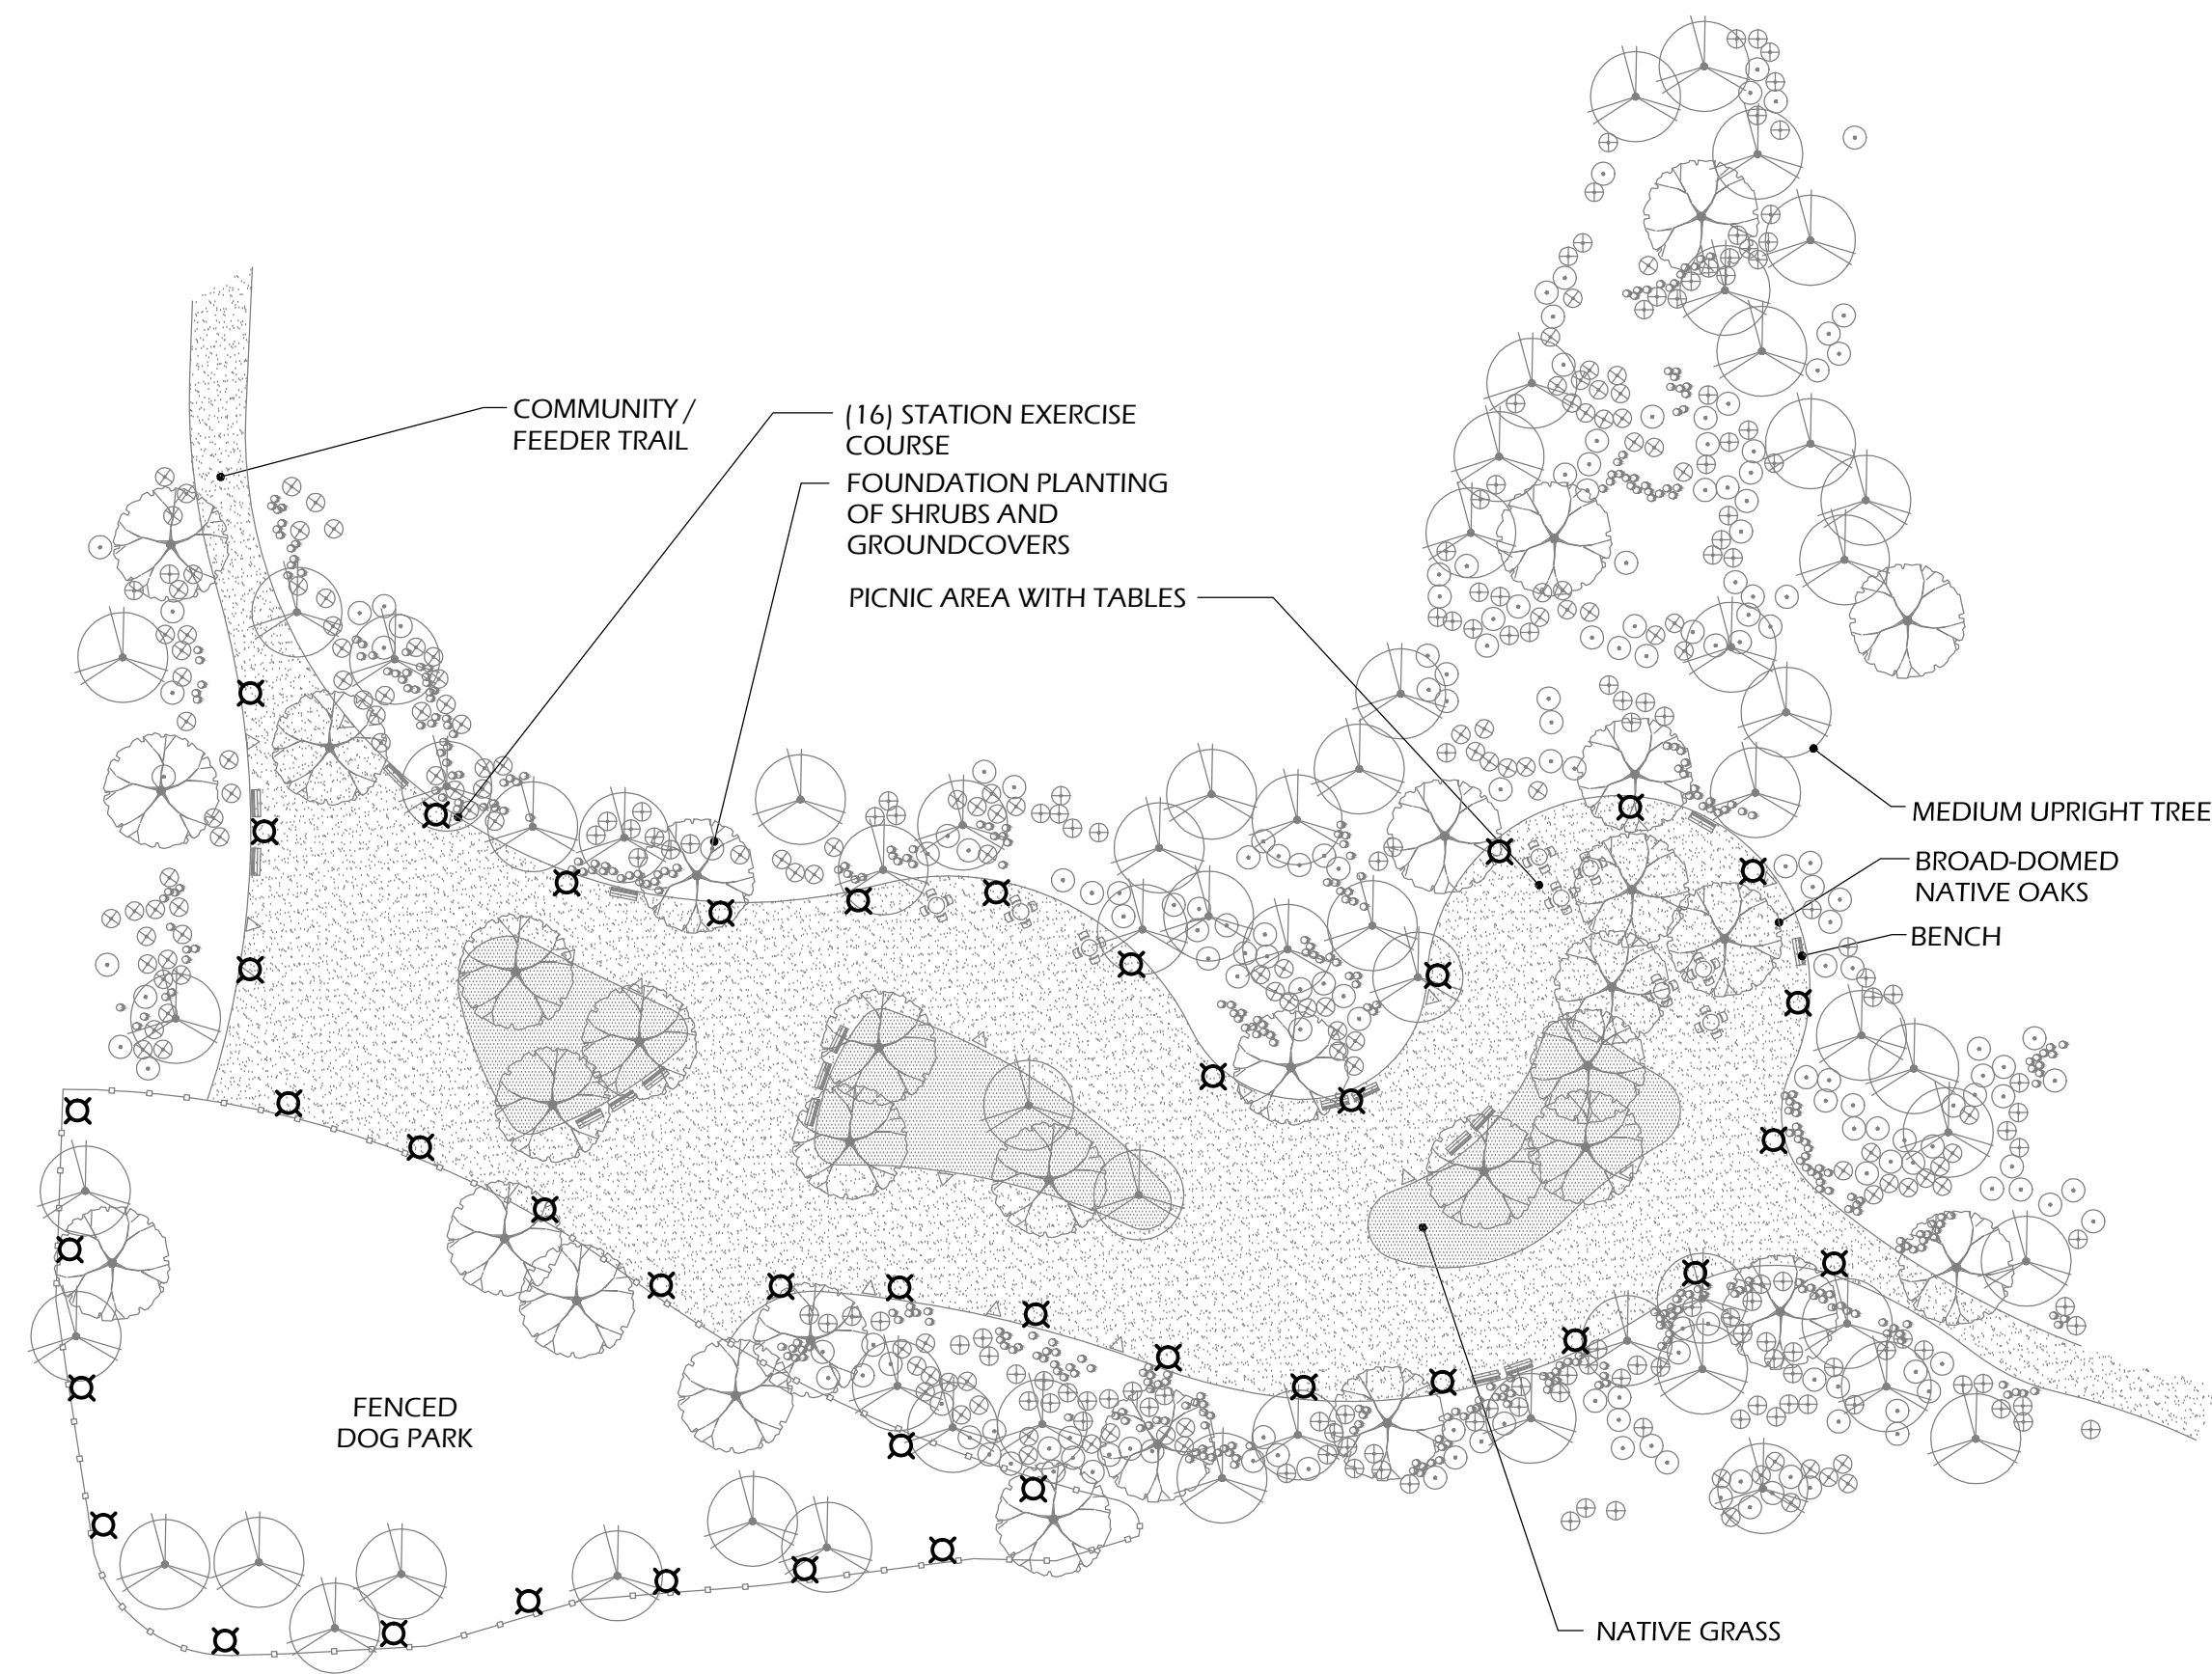


ENLARGED FITNESS CENTER PARK (P1)
SCALE: 1"=40'-0"
0 20' 40' 80' 120'
1" = 40'-0"

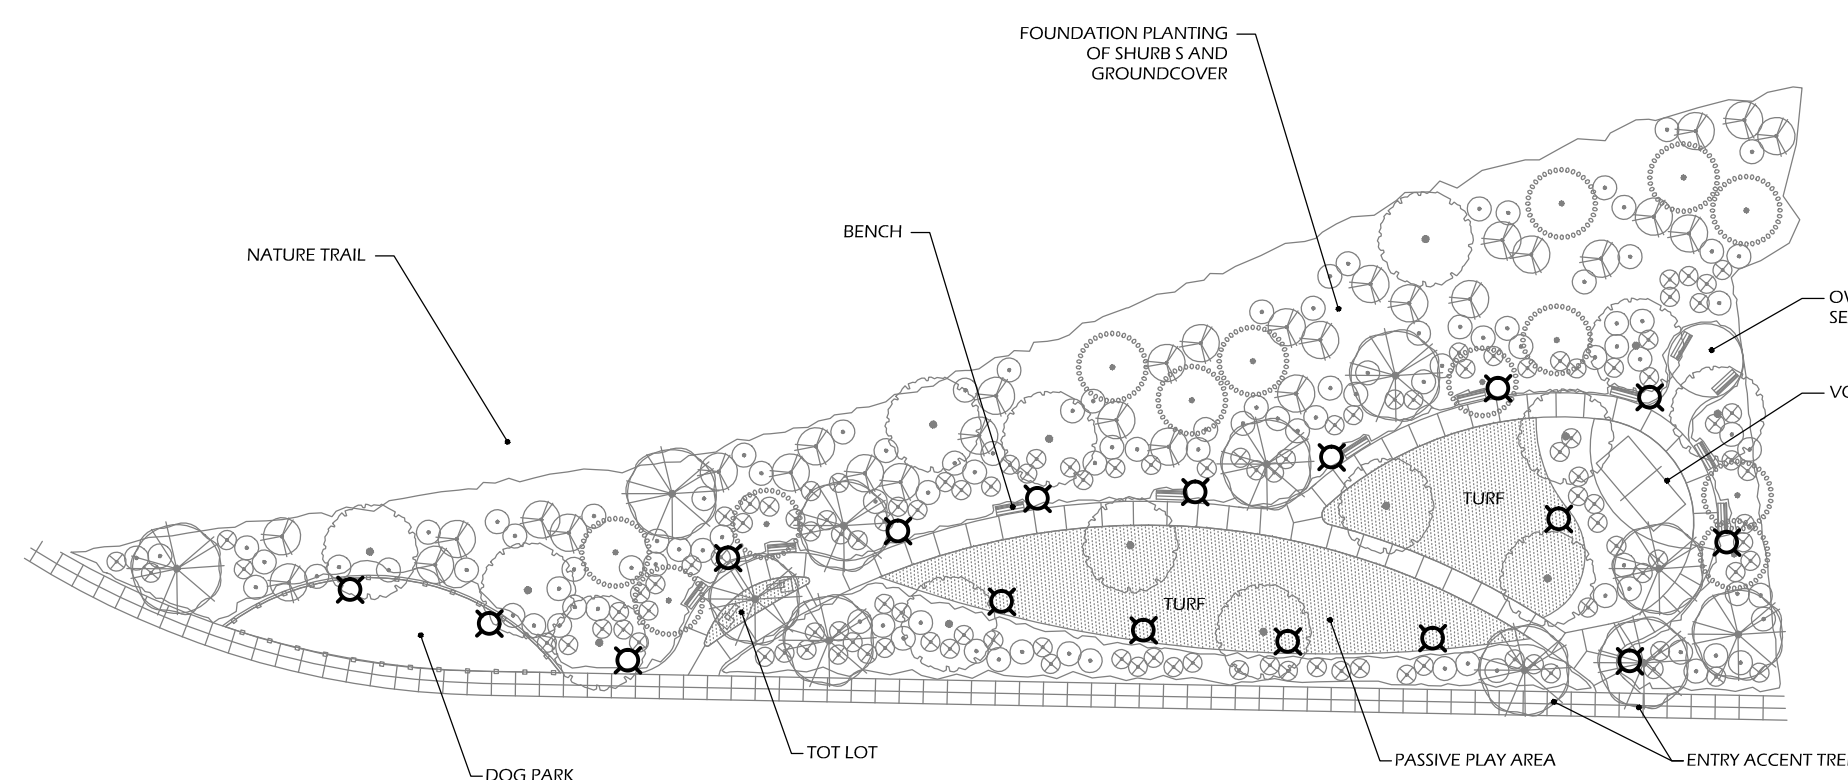


ENLARGED PORT PARK (P2)
SCALE: 1"=40'-0"
0 20' 40' 80' 120'
1" = 40'-0"

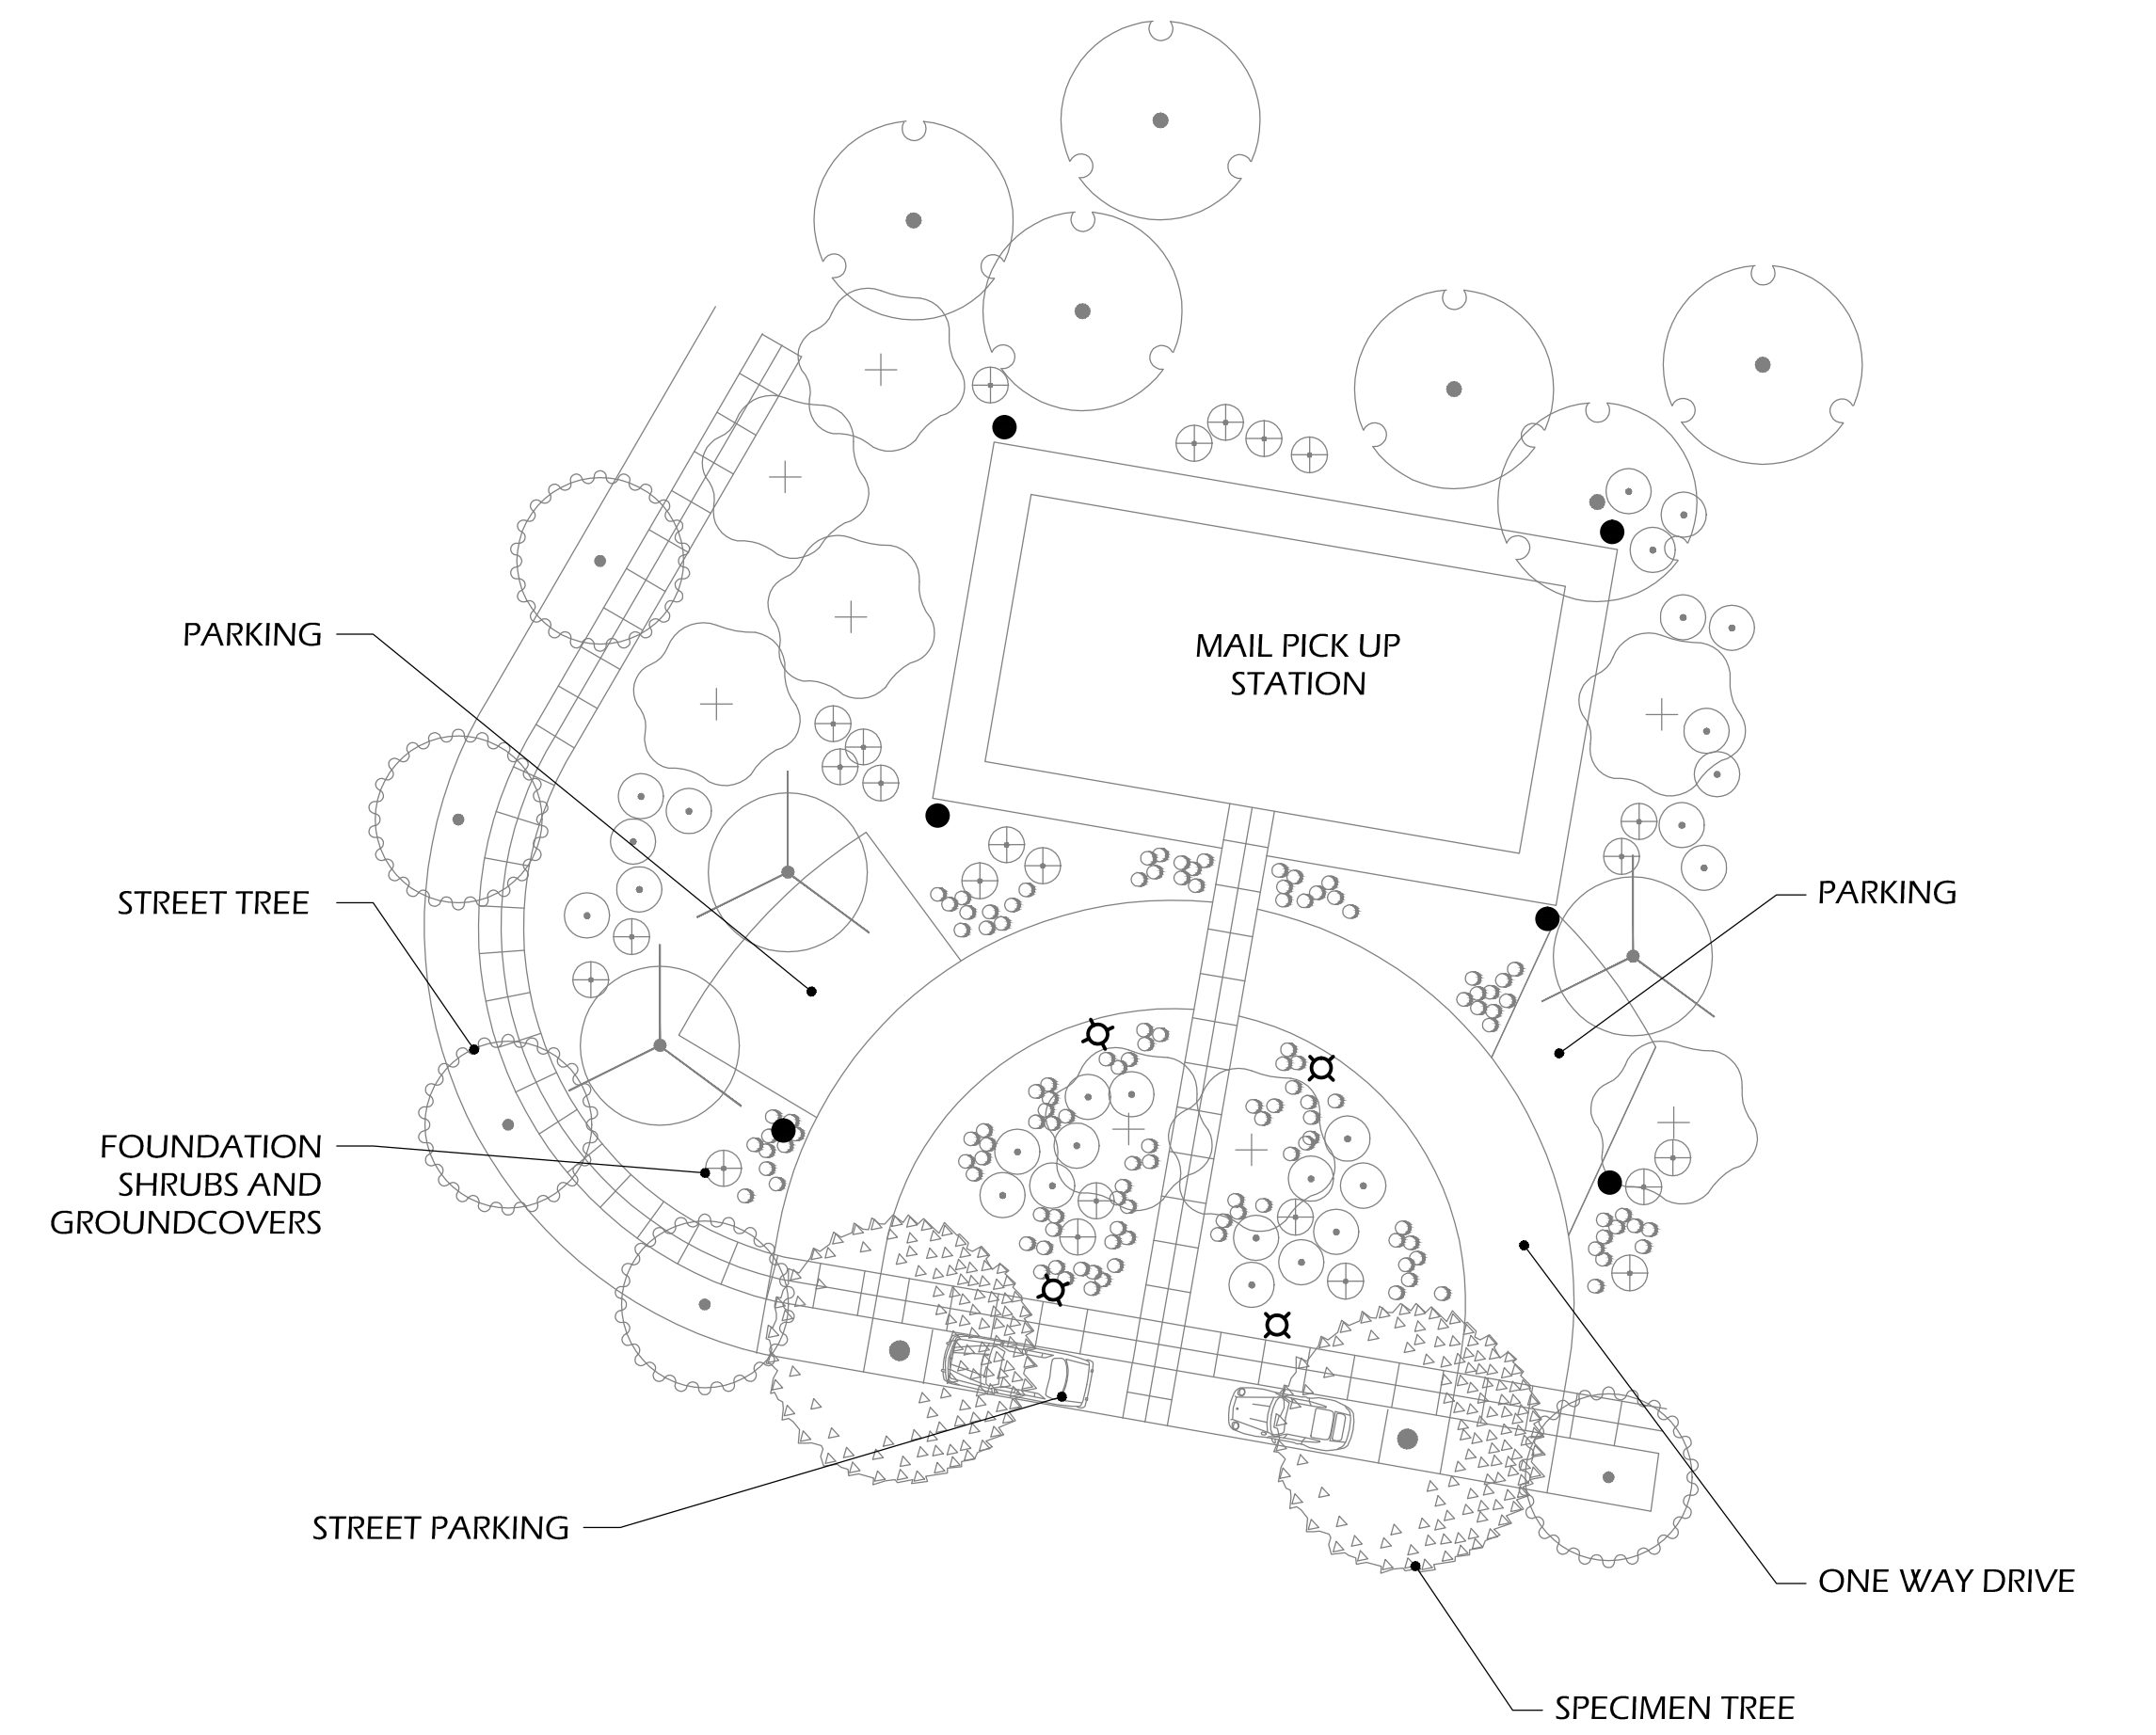

ENLARGED PICK UP STATION (P3)
SCALE: 1"=20'-0"
0 10' 20' 40' 60'
1" = 20'-0"

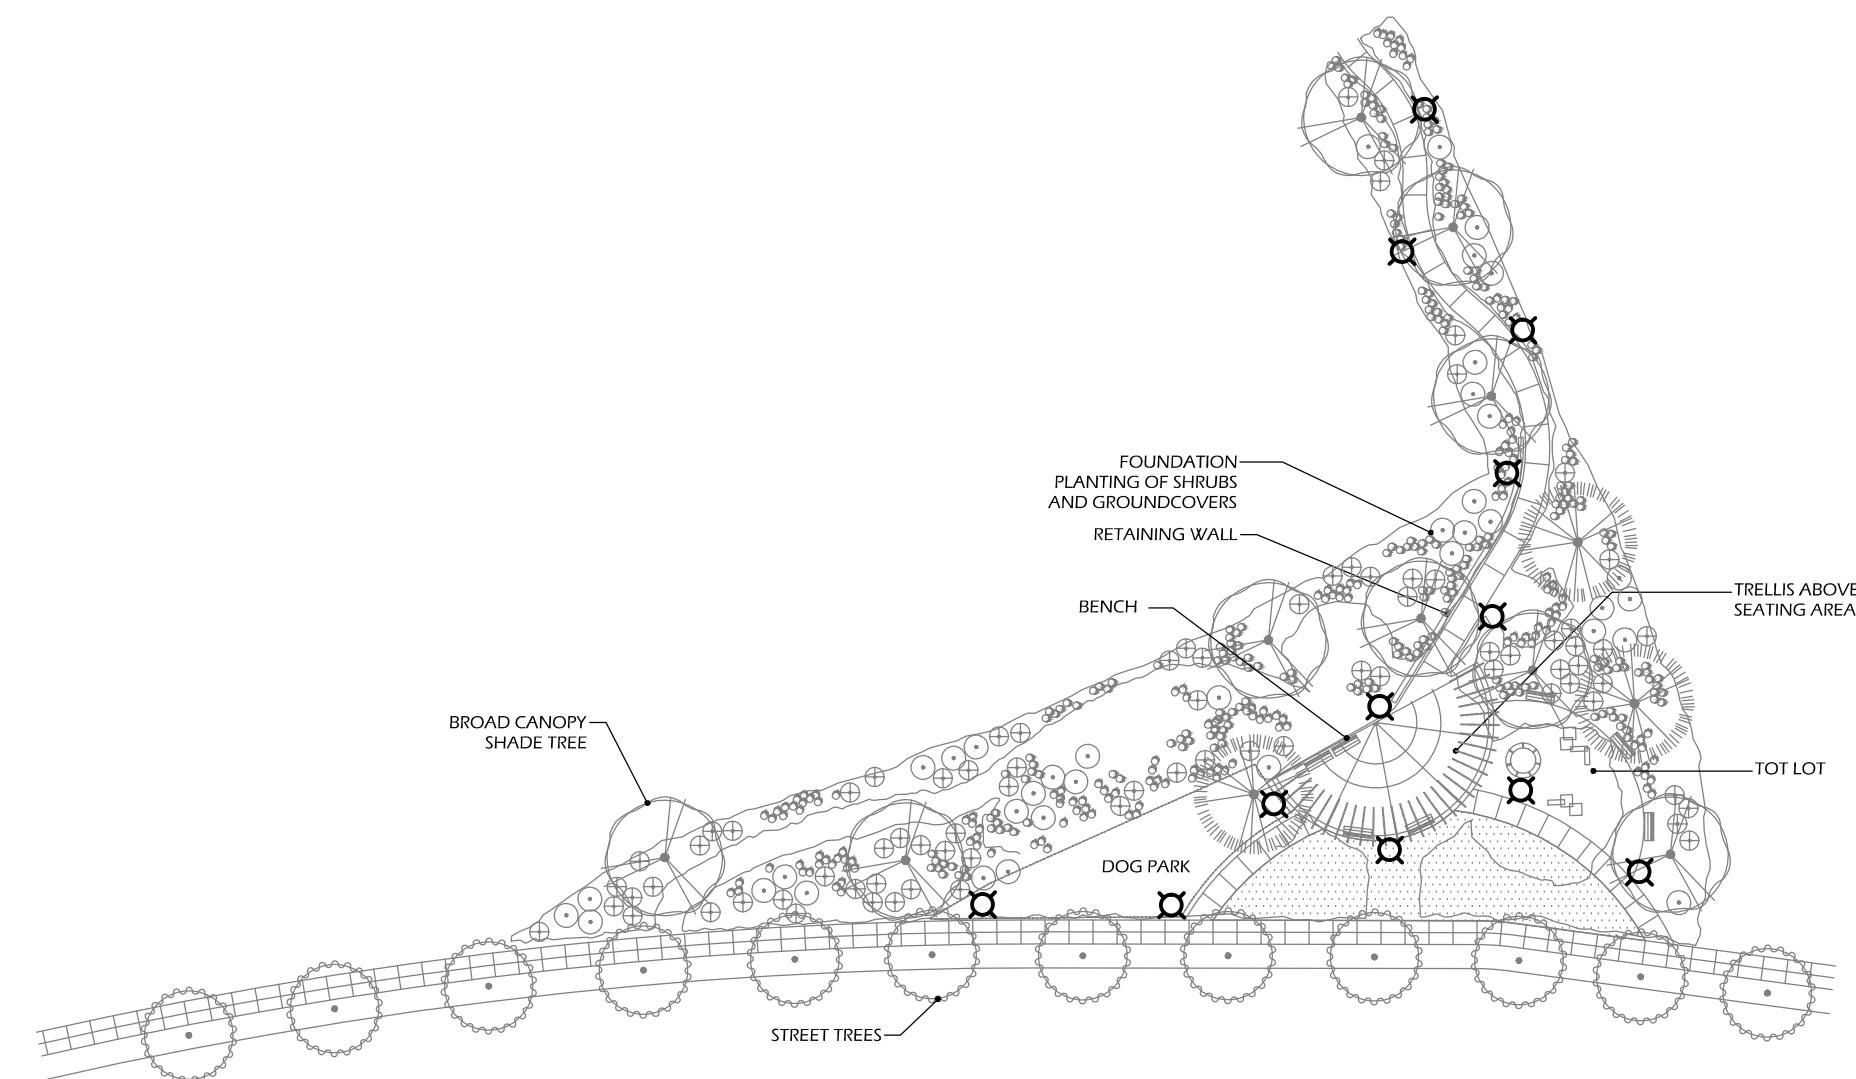


ENLARGED GARDEN PARK (P4)
SCALE: 1"=40'-0"
0 20' 40' 80' 120'
1" = 40'-0"

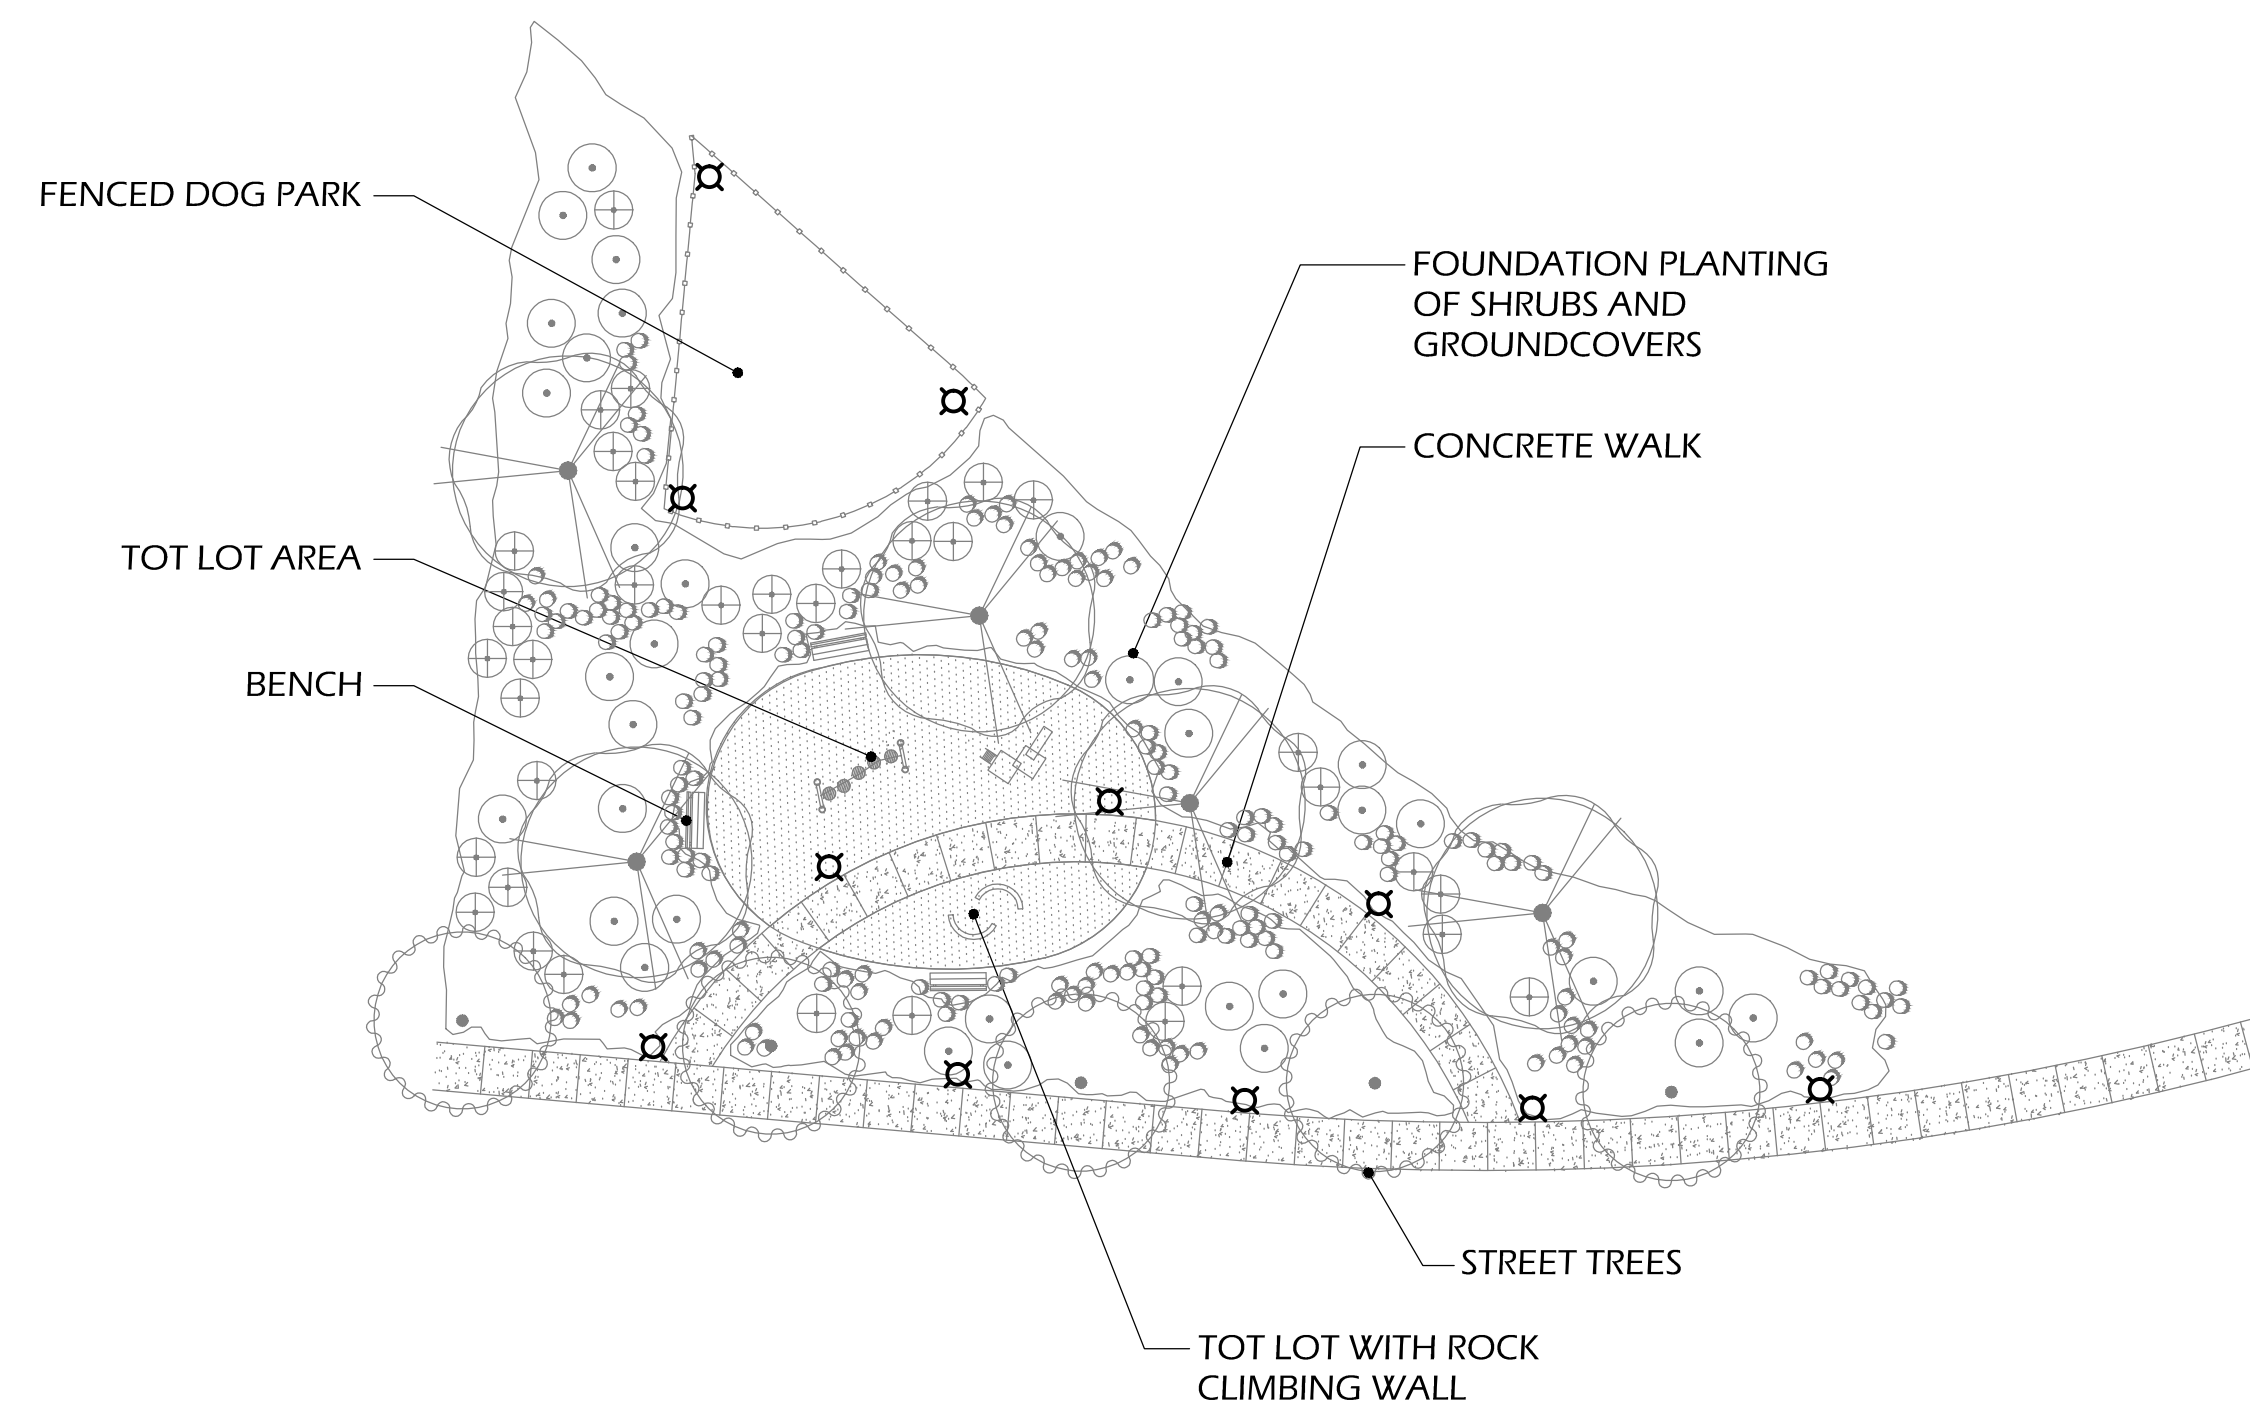

ENLARGED CLIMBER POCKET PARK (P5)
SCALE: 1"=20'-0"
0 10' 20' 40' 60'
1" = 20'-0"

TURPIN & RATTAN
ENGINEERING, INC.
CONSULTING ENGINEERS
4719 PALM AVENUE
LA MESA, CA 91941-5221
619 / 480-1622 FAX 480-1623
E-MAIL: ENGINEER@TRBIO.COM
TREI # 11348.01

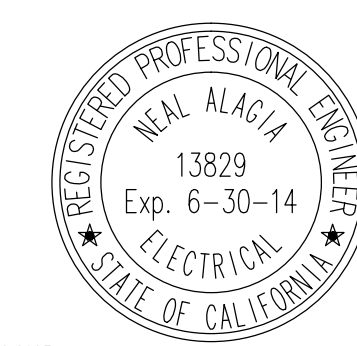


**Wimmer
Yamada
and
Caughy**

COUNTY OF SAN DIEGO TM 5572-RPL1
IMPLEMENTING TM LANDSCAPE CONCEPT PLAN FOR:

LILAC HILL RANCH



ENLARGED PARK PLANS

SHEET NO. 4 OF 14

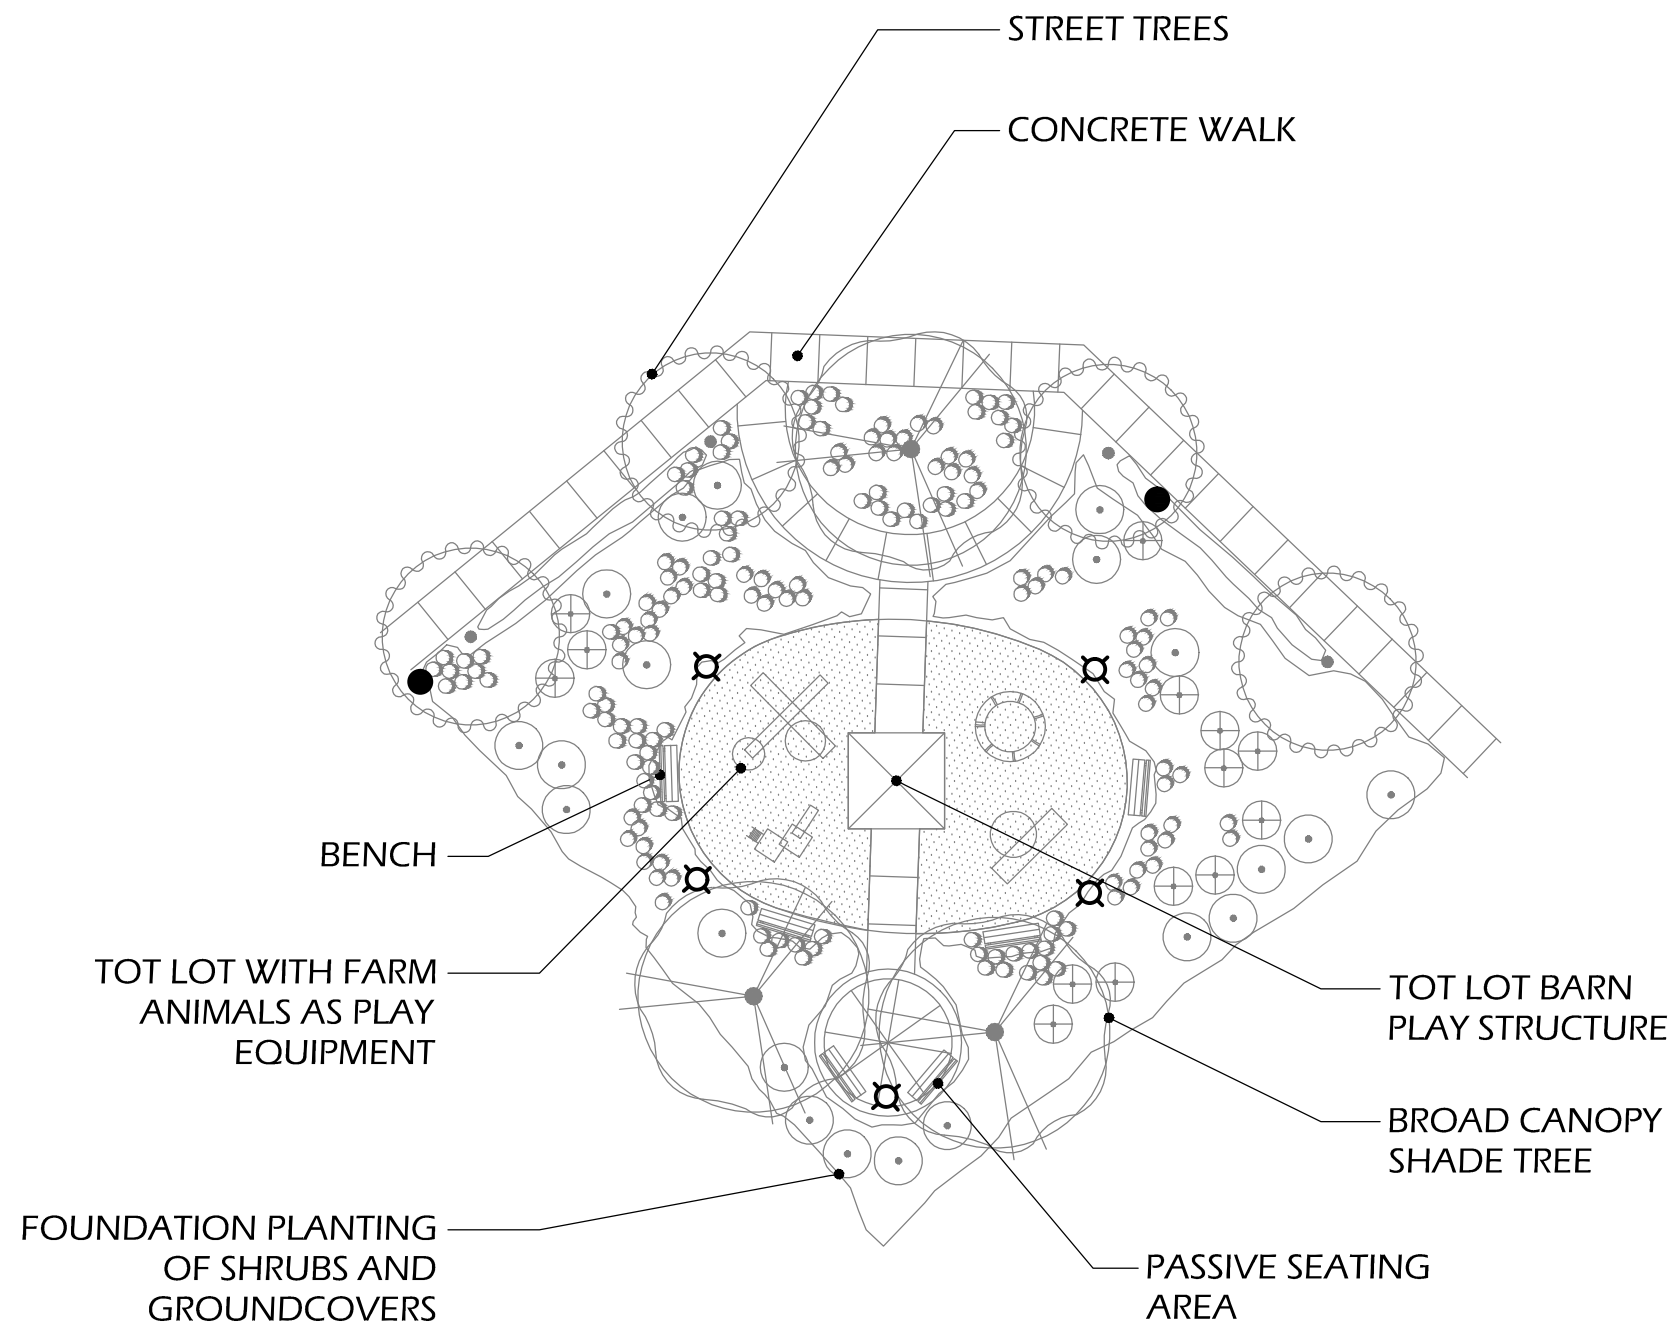


ENLARGED THE BARN (P6)

SCALE: 1"=40'-0"

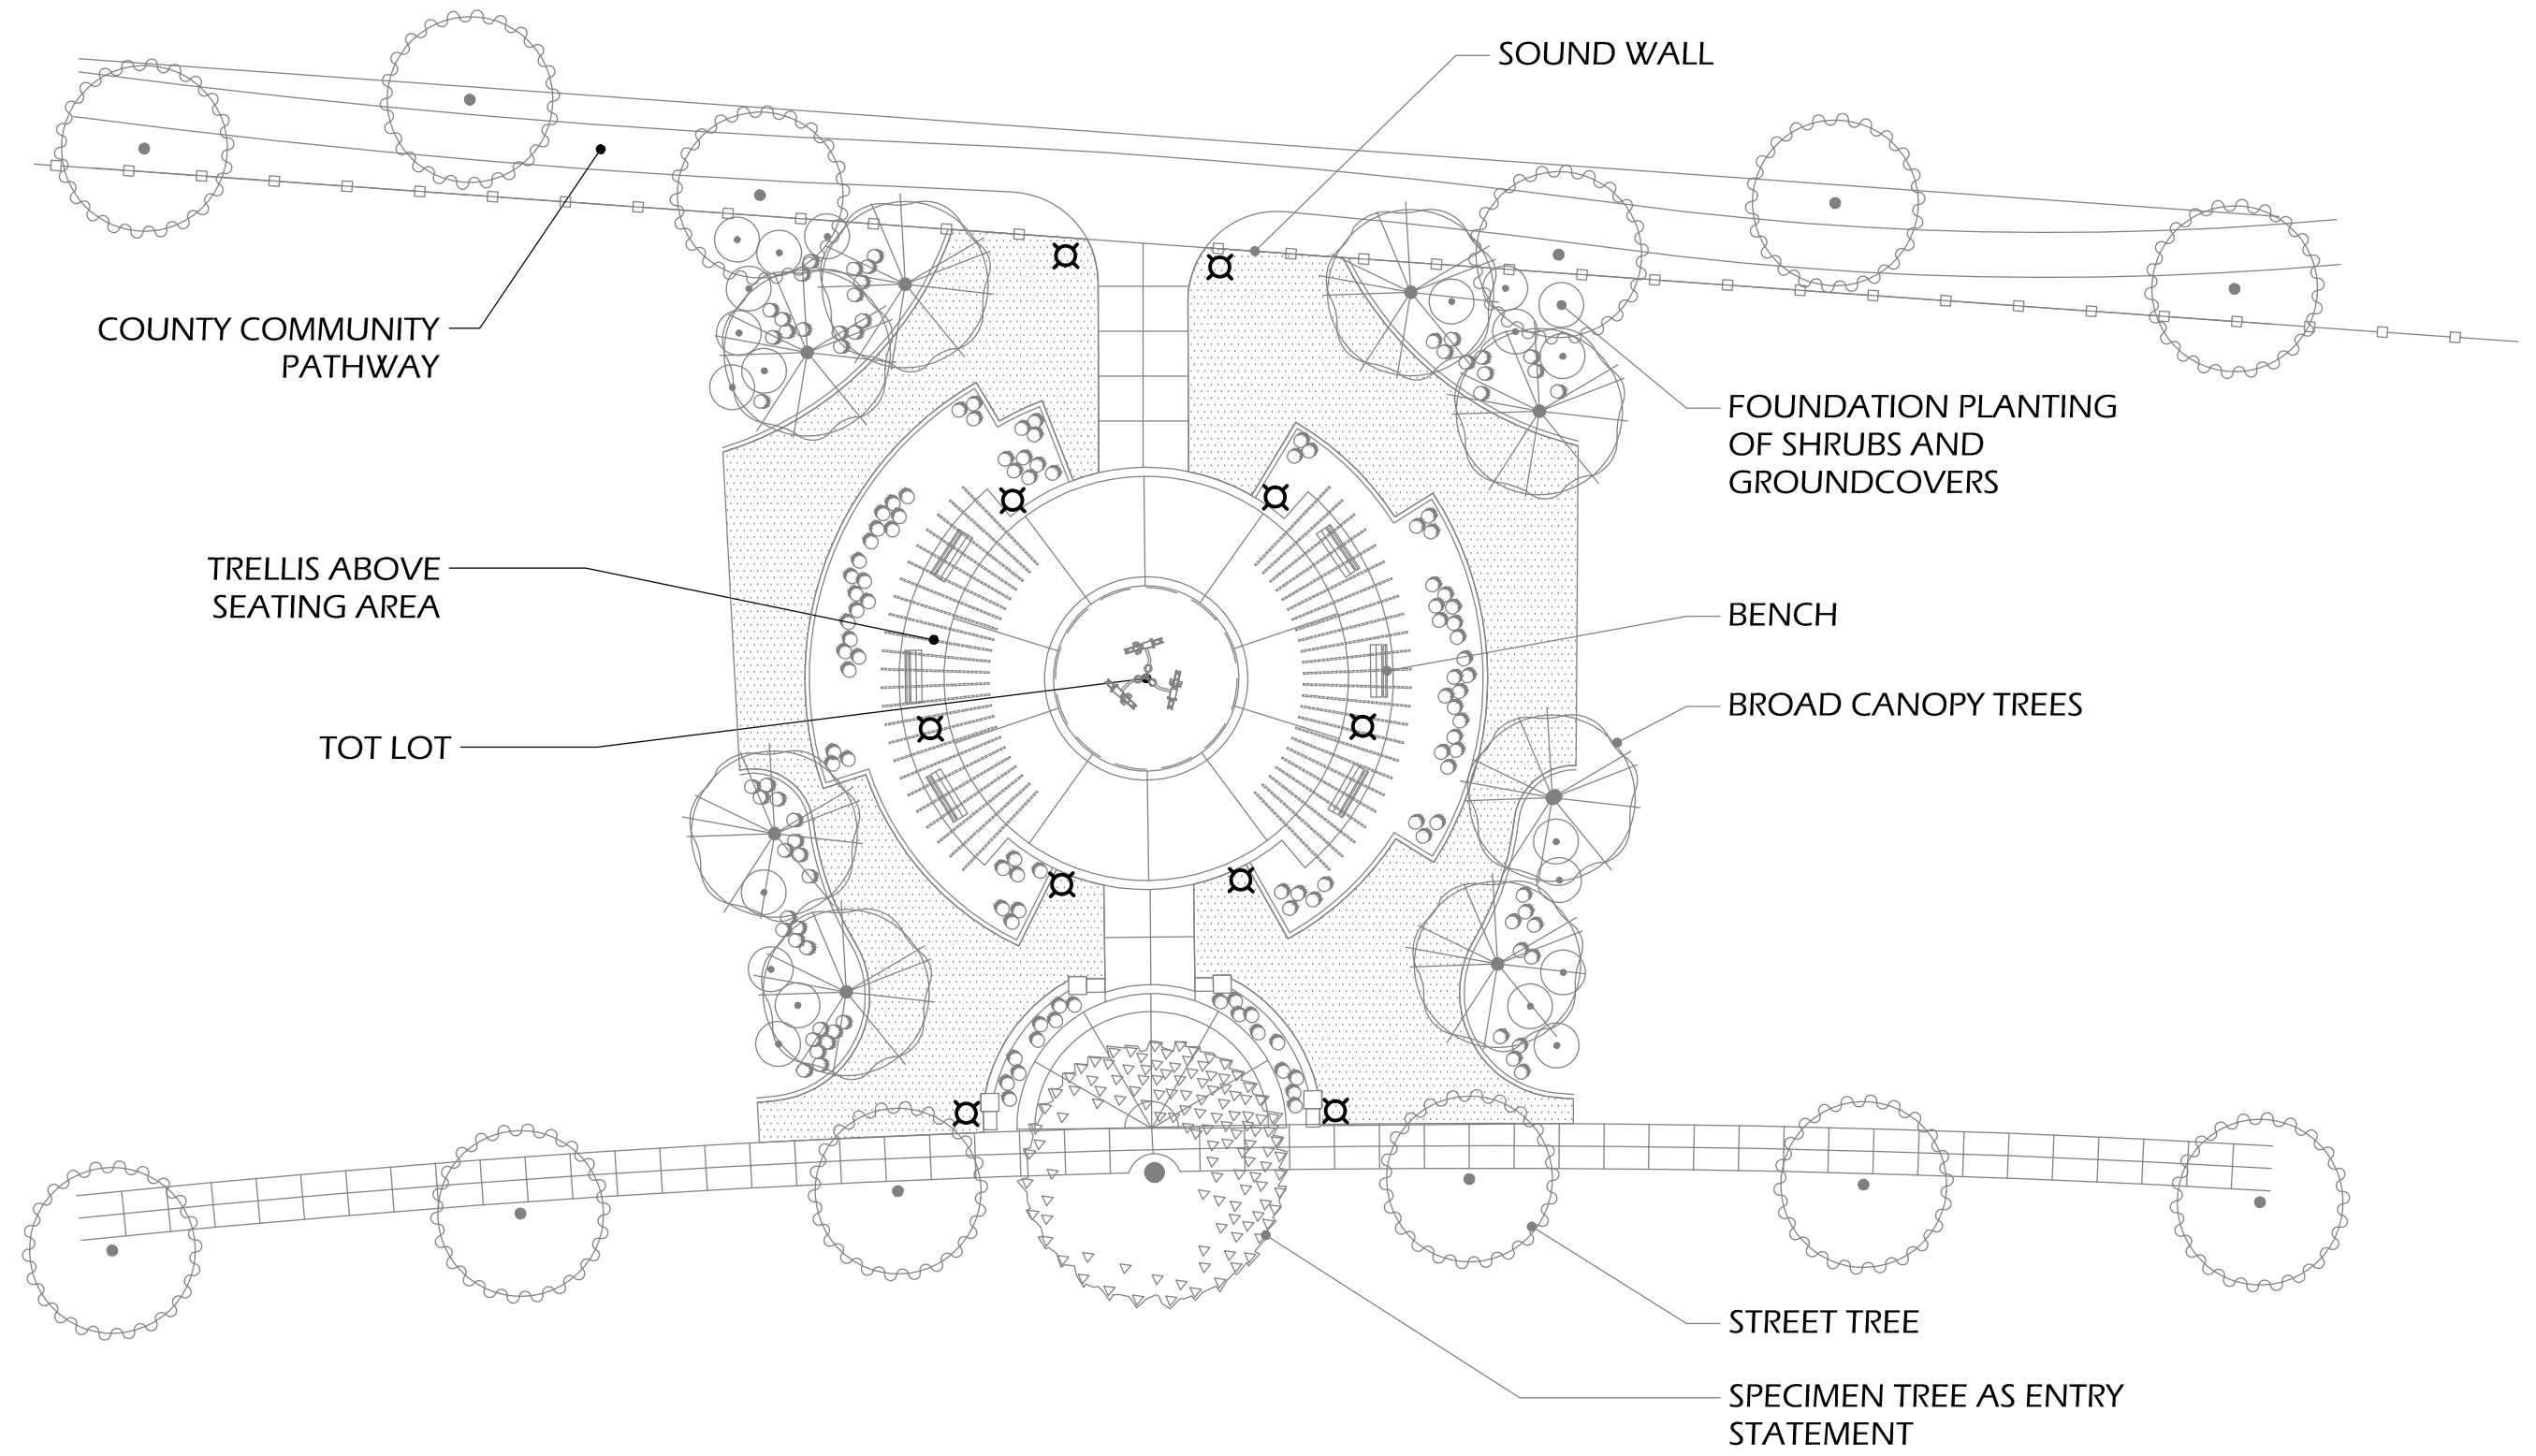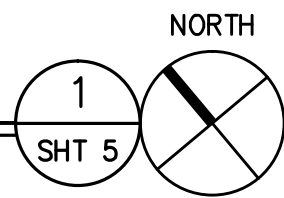


ENLARGED NEIGHBORHOOD PARK (P7)

SCALE: 1"=40'-0"

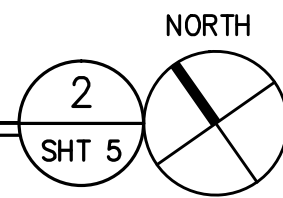

TURPIN & RATTAN
ENGINEERING, INC.
CONSULTING ENGINEERS
4719 PALM AVENUE
LA MESA, CA 91941-5221
619 / 480 / 6224 FAX 406 / 6233
E-MAIL: ENGINEER@TRRISO.COM
TREI # 11348.01

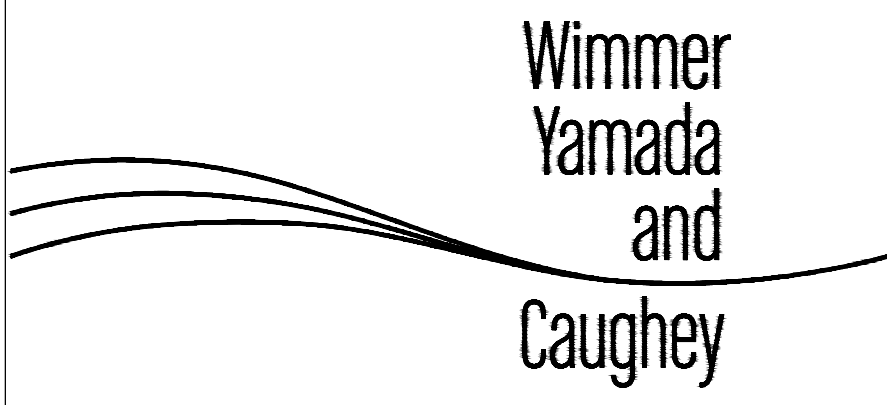

COUNTY OF SAN DIEGO TM 5572- RPL1
IMPLEMENTING TM LANDSCAPE CONCEPT PLAN FOR:

LILAC HILL RANCH

ENLARGED PARK PLANS



PARTIAL PHOTOMETRICS SHEET #1

SCALE: 1"=30'-0"



TURPIN & RATTAN
ENGINEERING, INC.
CONSULTING ENGINEERS
4719 PALM AVENUE
LA MESA, CA 91941-5221
619 / 486-6224 FAX 486-6233
E-MAIL: ENGINEER@TREISO.COM

TREI # 11348.01
6/19/13 02:14:13 0:30PM
D:\11348\11348\11348-01_SHT 6-13_Photometrics.dwg



**Wimmer
Yamada
and
Caughy**




SHEET INDEX
NOT TO SCALE

**COUNTY OF SAN DIEGO TM 5572- RPL1
IMPLEMENTING TM LANDSCAPE CONCEPT PLAN FOR:**

LILAC HILL RANCH

PARTIAL PHOTOMETRICS SHEET #1

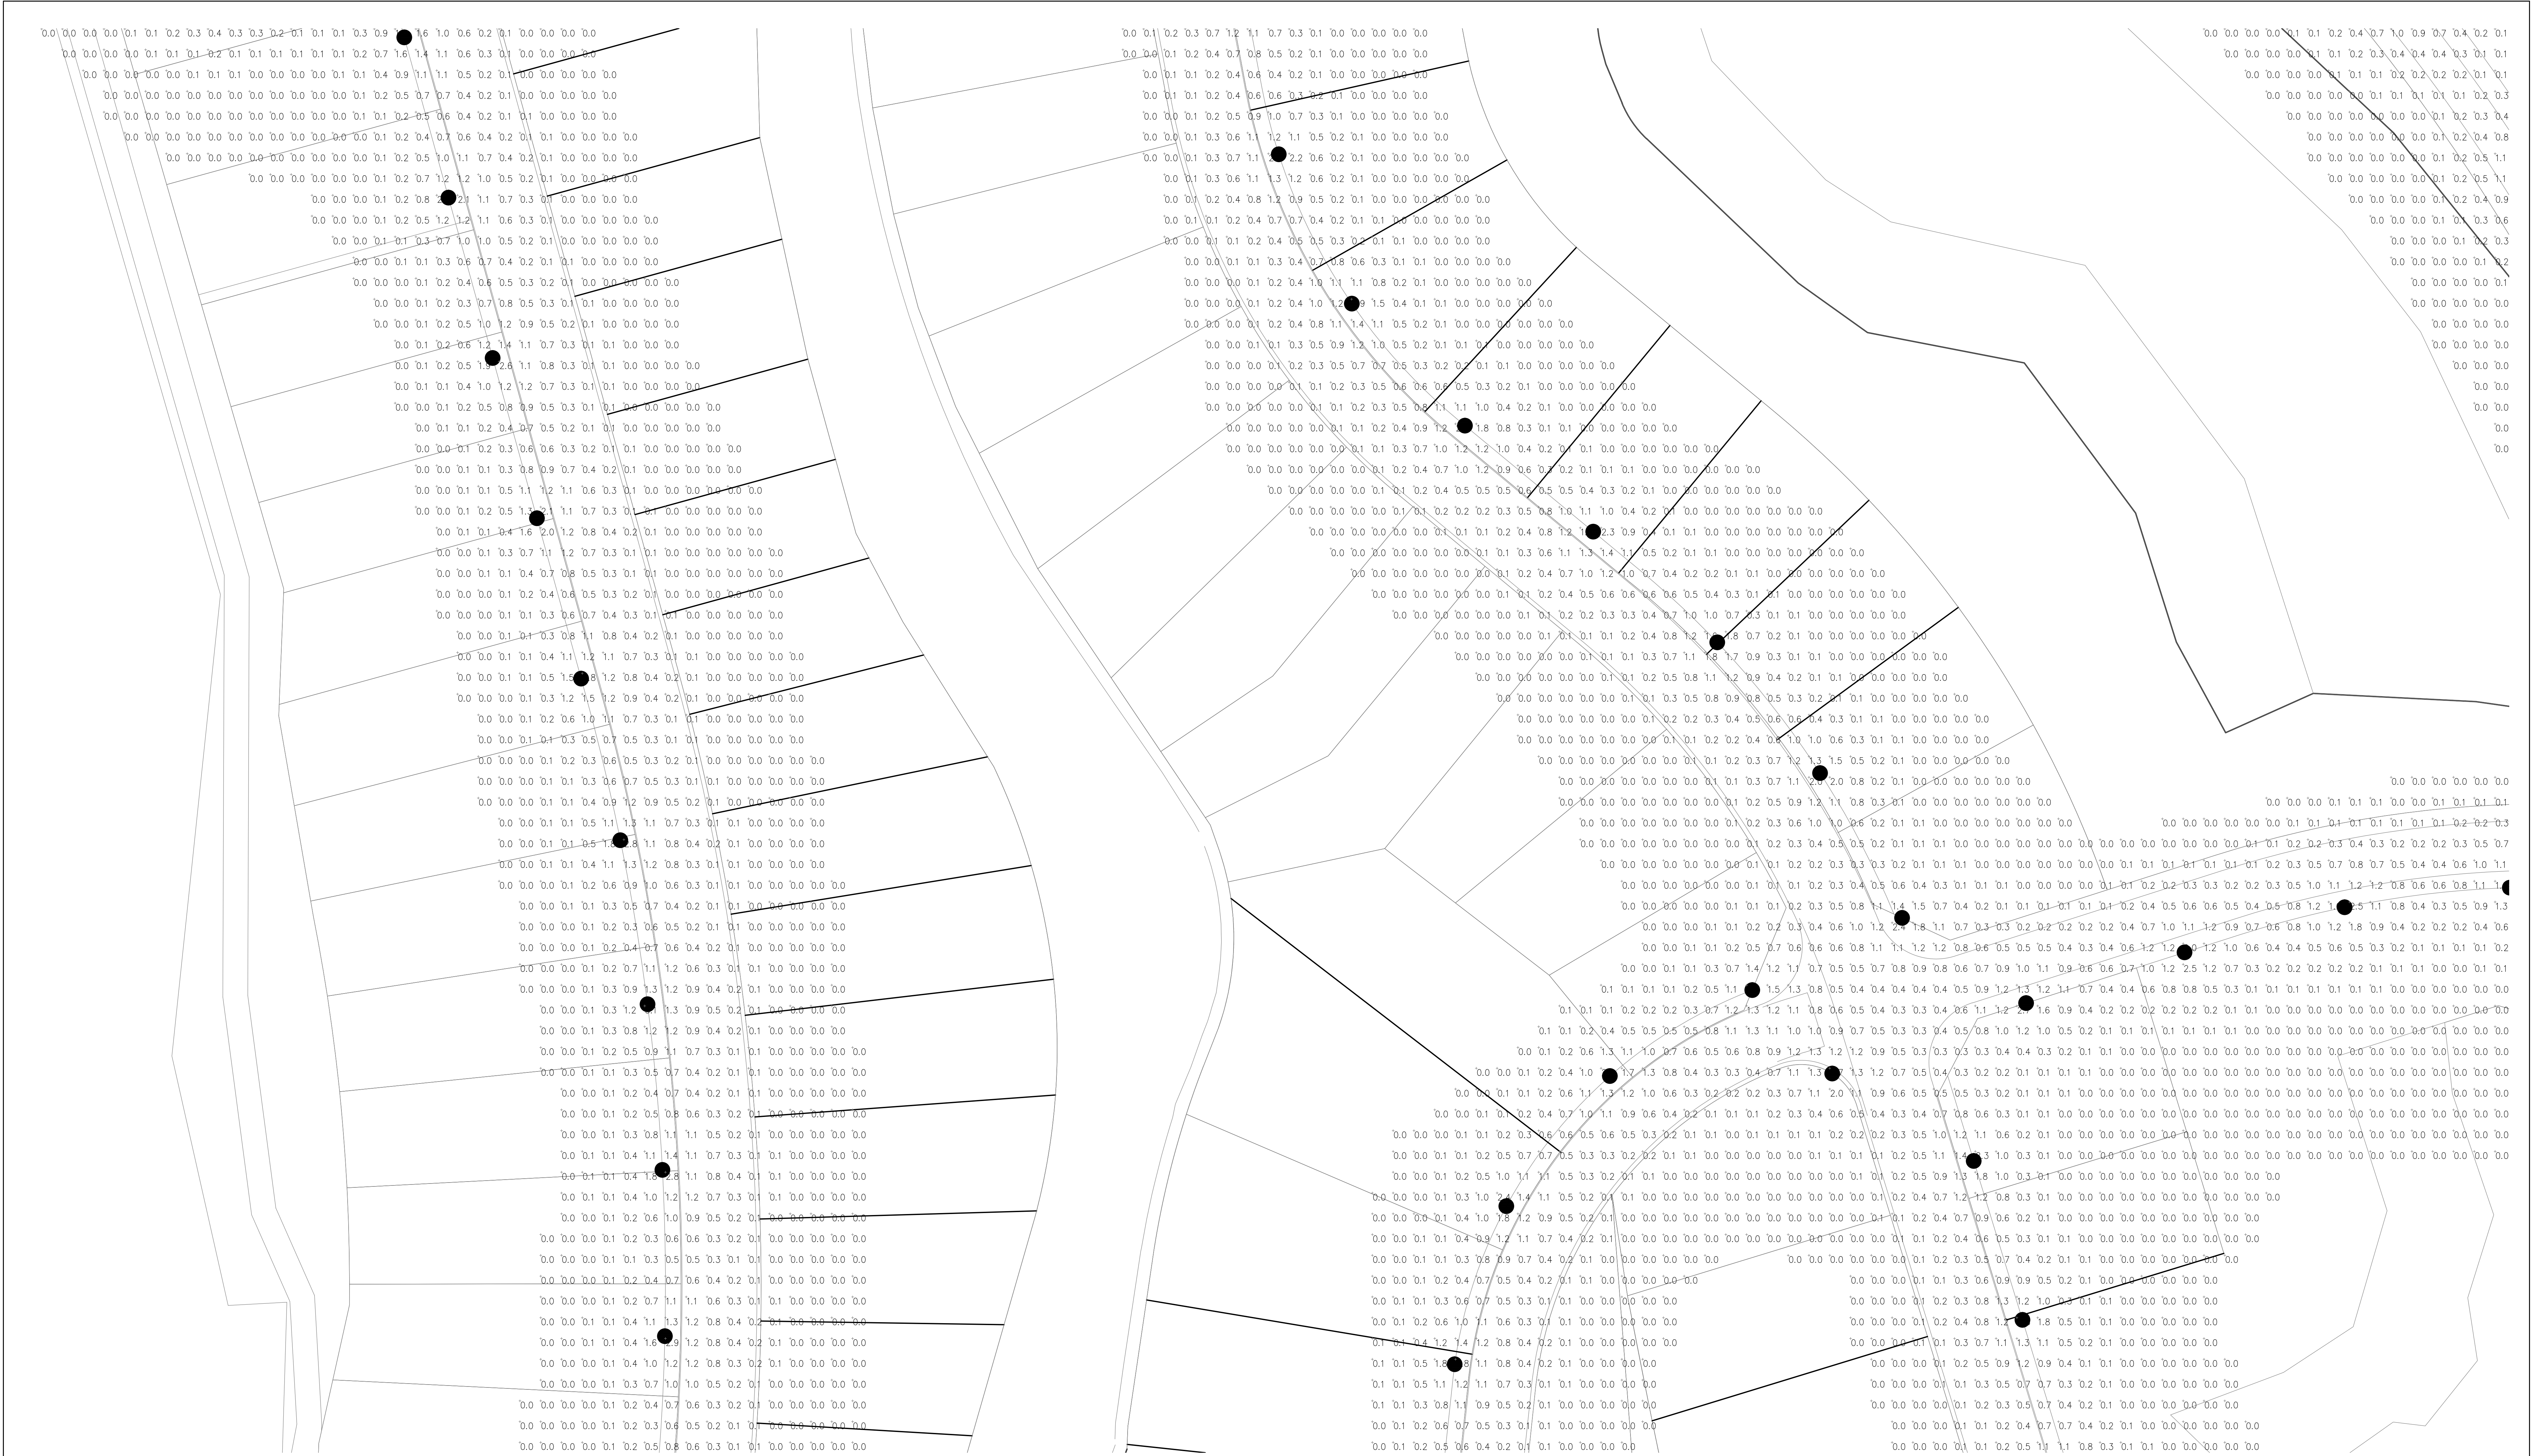

PARTIAL PHOTOMETRICS SHEET #2
SCALE: 1"=30'-0"




TURPIN & RATTAN
ENGINEERING, INC.
CONSULTING ENGINEERS
4719 PALM AVENUE
LA MESA, CA 91941-5221
619 / 486-6224 FAX 486-6233
E-MAIL: ENGINEER@TREI.COM

TREI # 11348.01
6/20/04 02:14:13 0:30PM
D:\11348\01\ACAD\TREI\11348.01_SHT 6-13_Photometrics.dwg



**Wimmer
Yamada
and
Caughy**

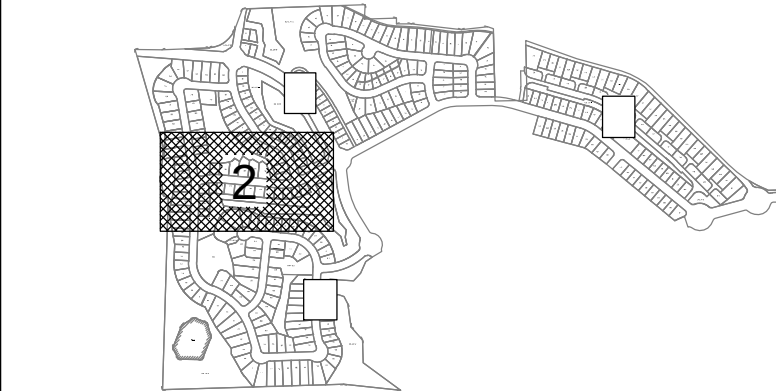


SHEET INDEX
NOT TO SCALE

COUNTY OF SAN DIEGO TM 5572- RPL1
IMPLEMENTING TM LANDSCAPE CONCEPT PLAN FOR:

LILAC HILL RANCH

PARTIAL PHOTOMETRICS SHEET #2

SHEET NO. 7 OF 14

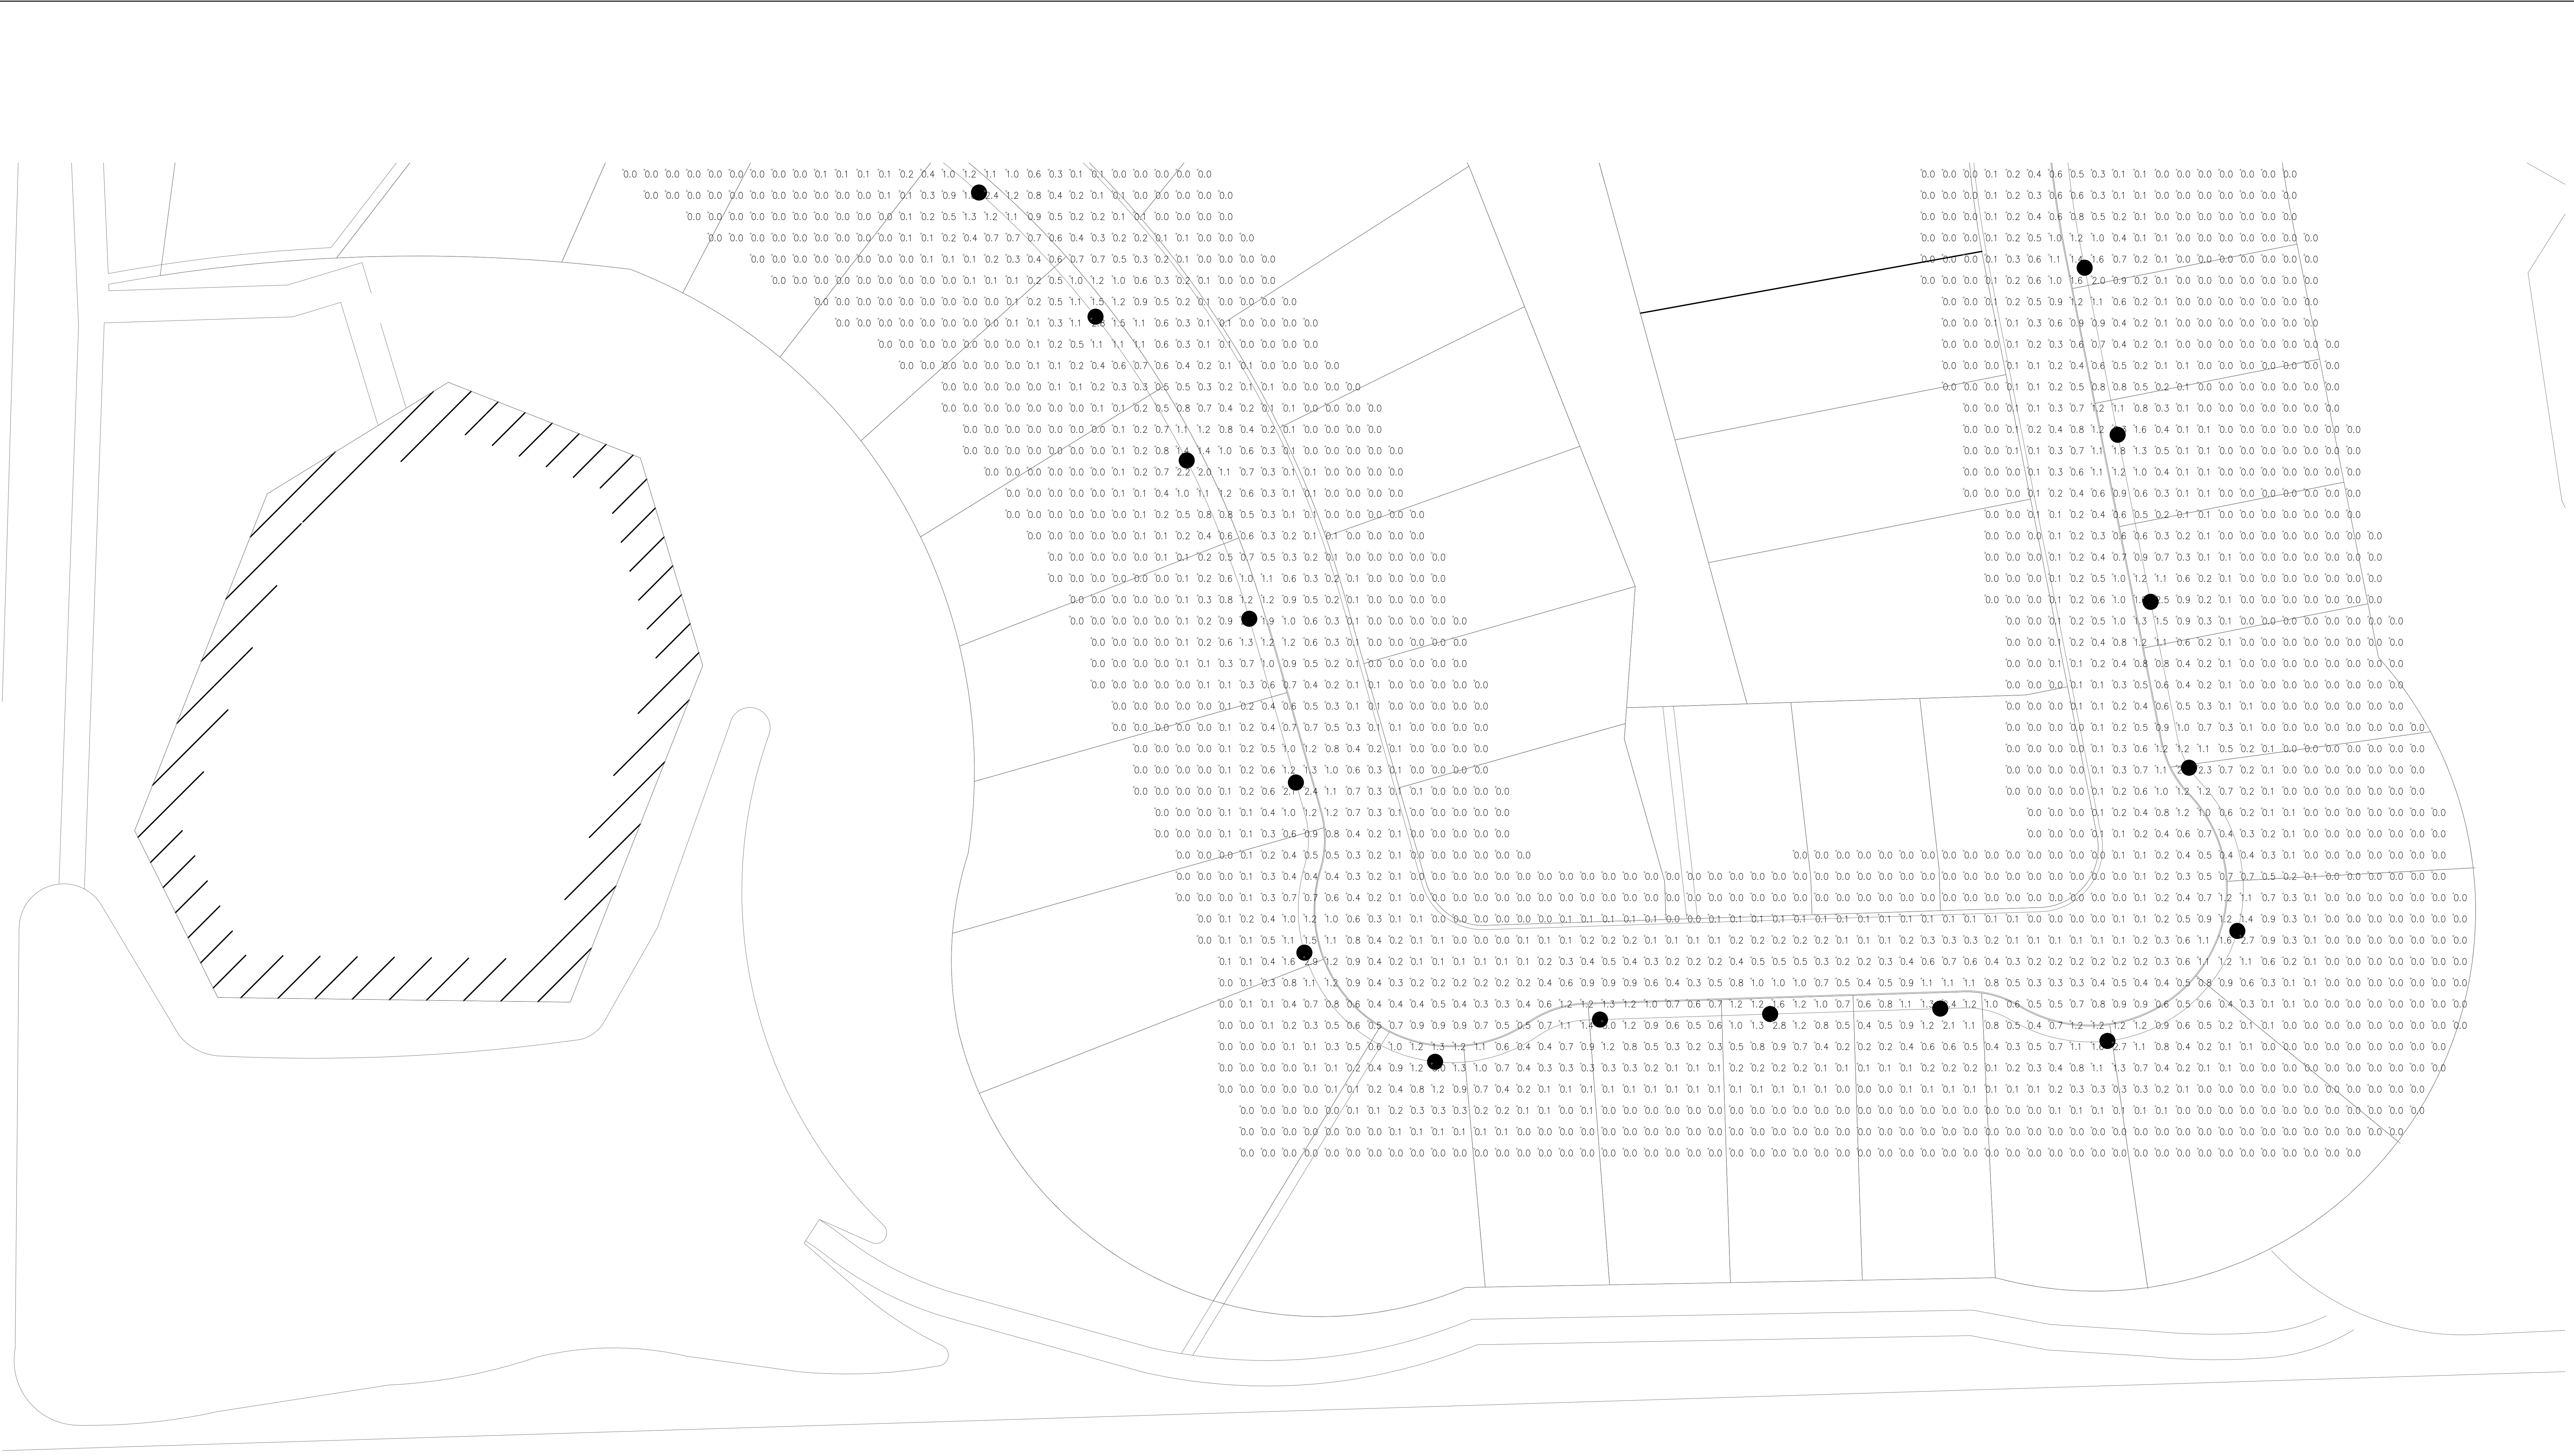


PARTIAL PHOTOMETRICS SHEET #4

SCALE: 1"=30'-0"




TURPIN & RATTAN
ENGINEERING, INC.
CONSULTING ENGINEERS
4719 PALM AVENUE
LA MESA, CA 91941-5221
619 / 480-1622 FAX 480-1623
E-MAIL: ENGINEER@TRBIO.COM
TREI # 11348.01

6/20/2014 11:13 AM 5/20/2014
0111134801ACADPHOTO11348.01_SHT 4-13_Photometrics.dwg

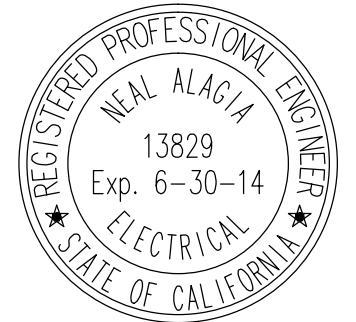

**Wimmer
Yamada
and
Caughy**

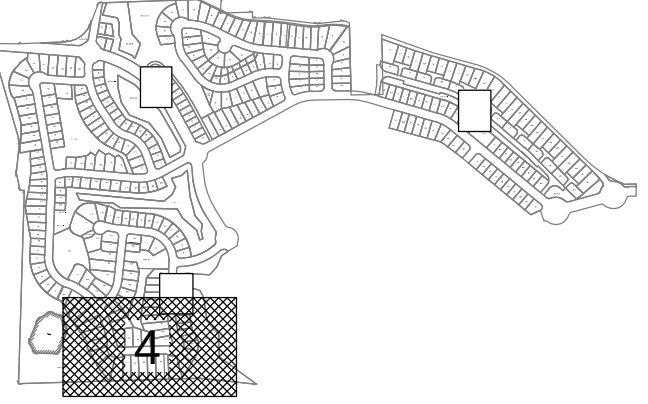

SHEET INDEX
NOT TO SCALE

**COUNTY OF SAN DIEGO TM 5572- RPL1
IMPLEMENTING TM LANDSCAPE CONCEPT PLAN FOR:**

LILAC HILL RANCH

PARTIAL PHOTOMETRICS SHEET #4